






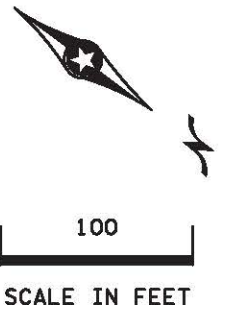



LEGEND

-  LIGHTING UNIT
-  PAD MOUNTED FD. PT. CABINET 120/240 VOLT
-  DIRECT BURIED LIGHTING CABLE 4/C 4 AWG
-  PERMANENT GROUND ROD (25 OHMS OR LESS)
-  3" PVC (UNLESS NOTED OTHERWISE)
-  LIGHTING UNIT IDENTIFIER
-  INPLACE UTILITY POLE




PLOTTED/REVISED: 25-JAN-2021

DISTRICT #: Metro
 IPLOT NAME: 1926-22_It_0
 PATH & FILENAME: Projects\DM_R05\316\1926\022\Traffic\Lighting\1926-22_It_0.dgn

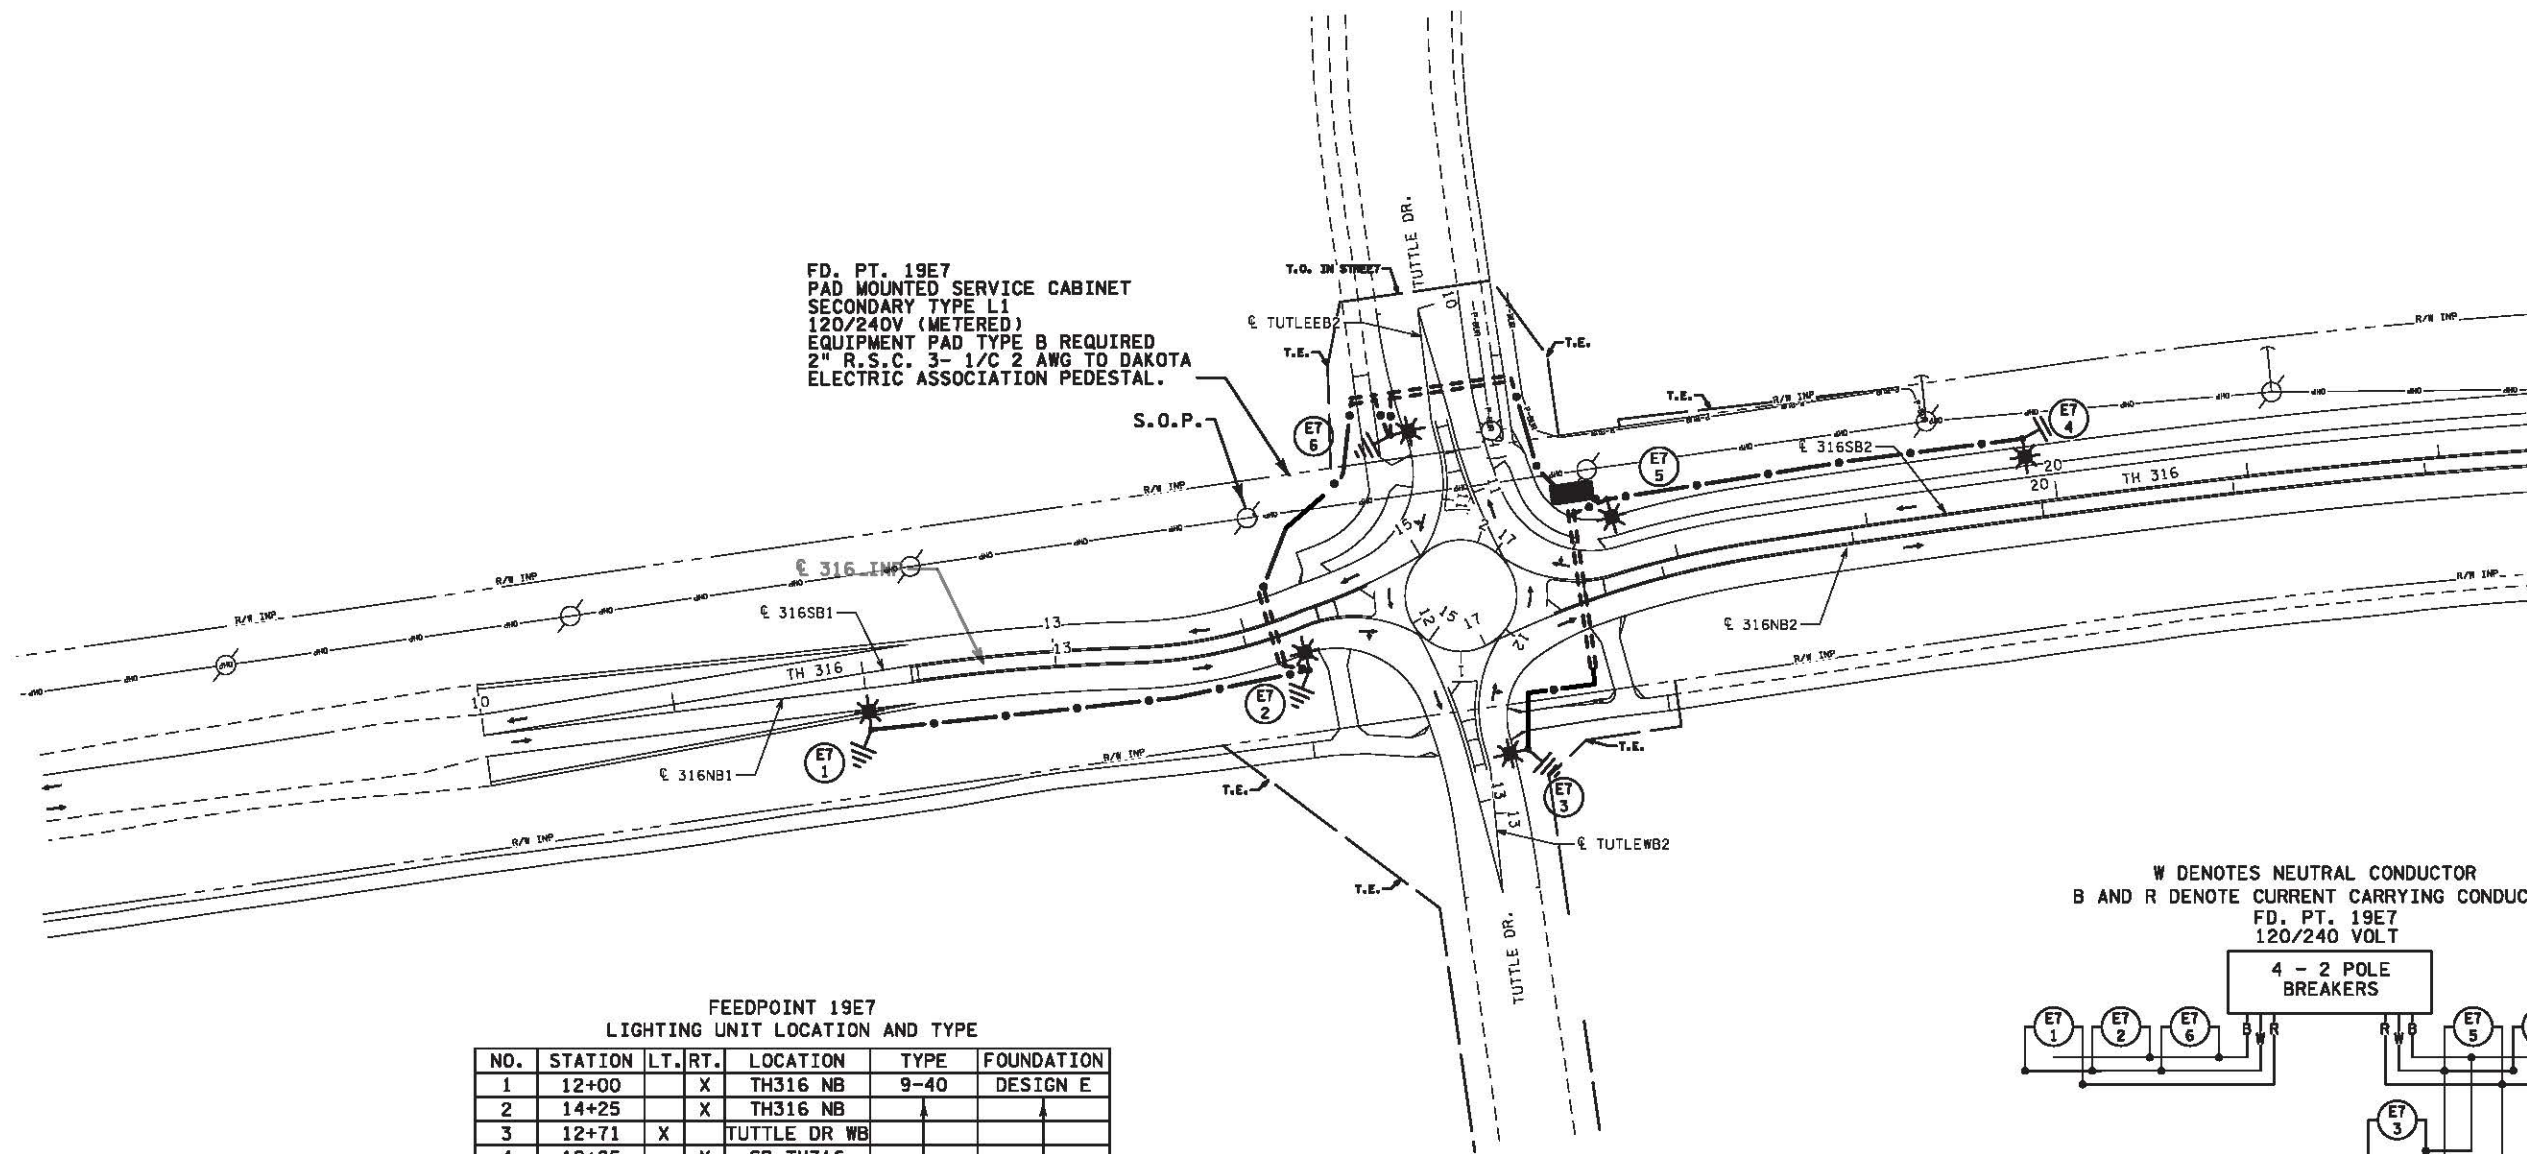

FEEDPOINT 19E7
 LIGHTING UNIT LOCATION AND TYPE

NO.	STATION	LT.	RT.	LOCATION	TYPE	FOUNDATION
1	12+00	X		TH316 NB	9-40	DESIGN E
2	14+25		X	TH316 NB		
3	12+71	X		TUTTLE DR WB		
4	19+85	X		SB TH316		
5	17+72	X		SB TH316		
6	10+60		X	TUTTLE DR WB	9-40	DESIGN E

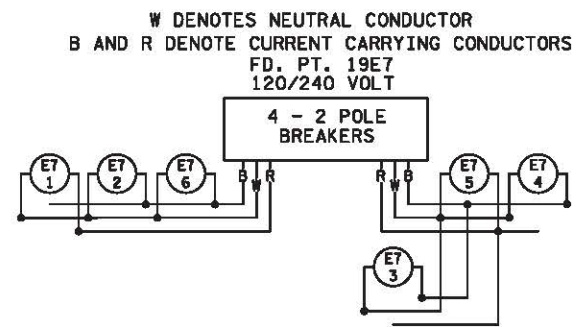

S.A.P. 130-010-013

AS-BUILT

BY	DATE	REVISIONS	FEEDPOINT: 19E7 LOCATION: TUTTLE DR.	LIGHTING PLAN
			METER ADDRESS: 3799 MN-316 HASTINGS, MN 55033	
DRAWN BY: PB CKD BY: JC			CERTIFIED BY: <i>Michael P. Dubinsky</i> LIC. NO. 19863 DATE: 25-JAN-2021	STATE PROJ. NO. 1926-22 (T.H. 316) SHEET NO. SL3 OF SL5 SHEETS