



 
 

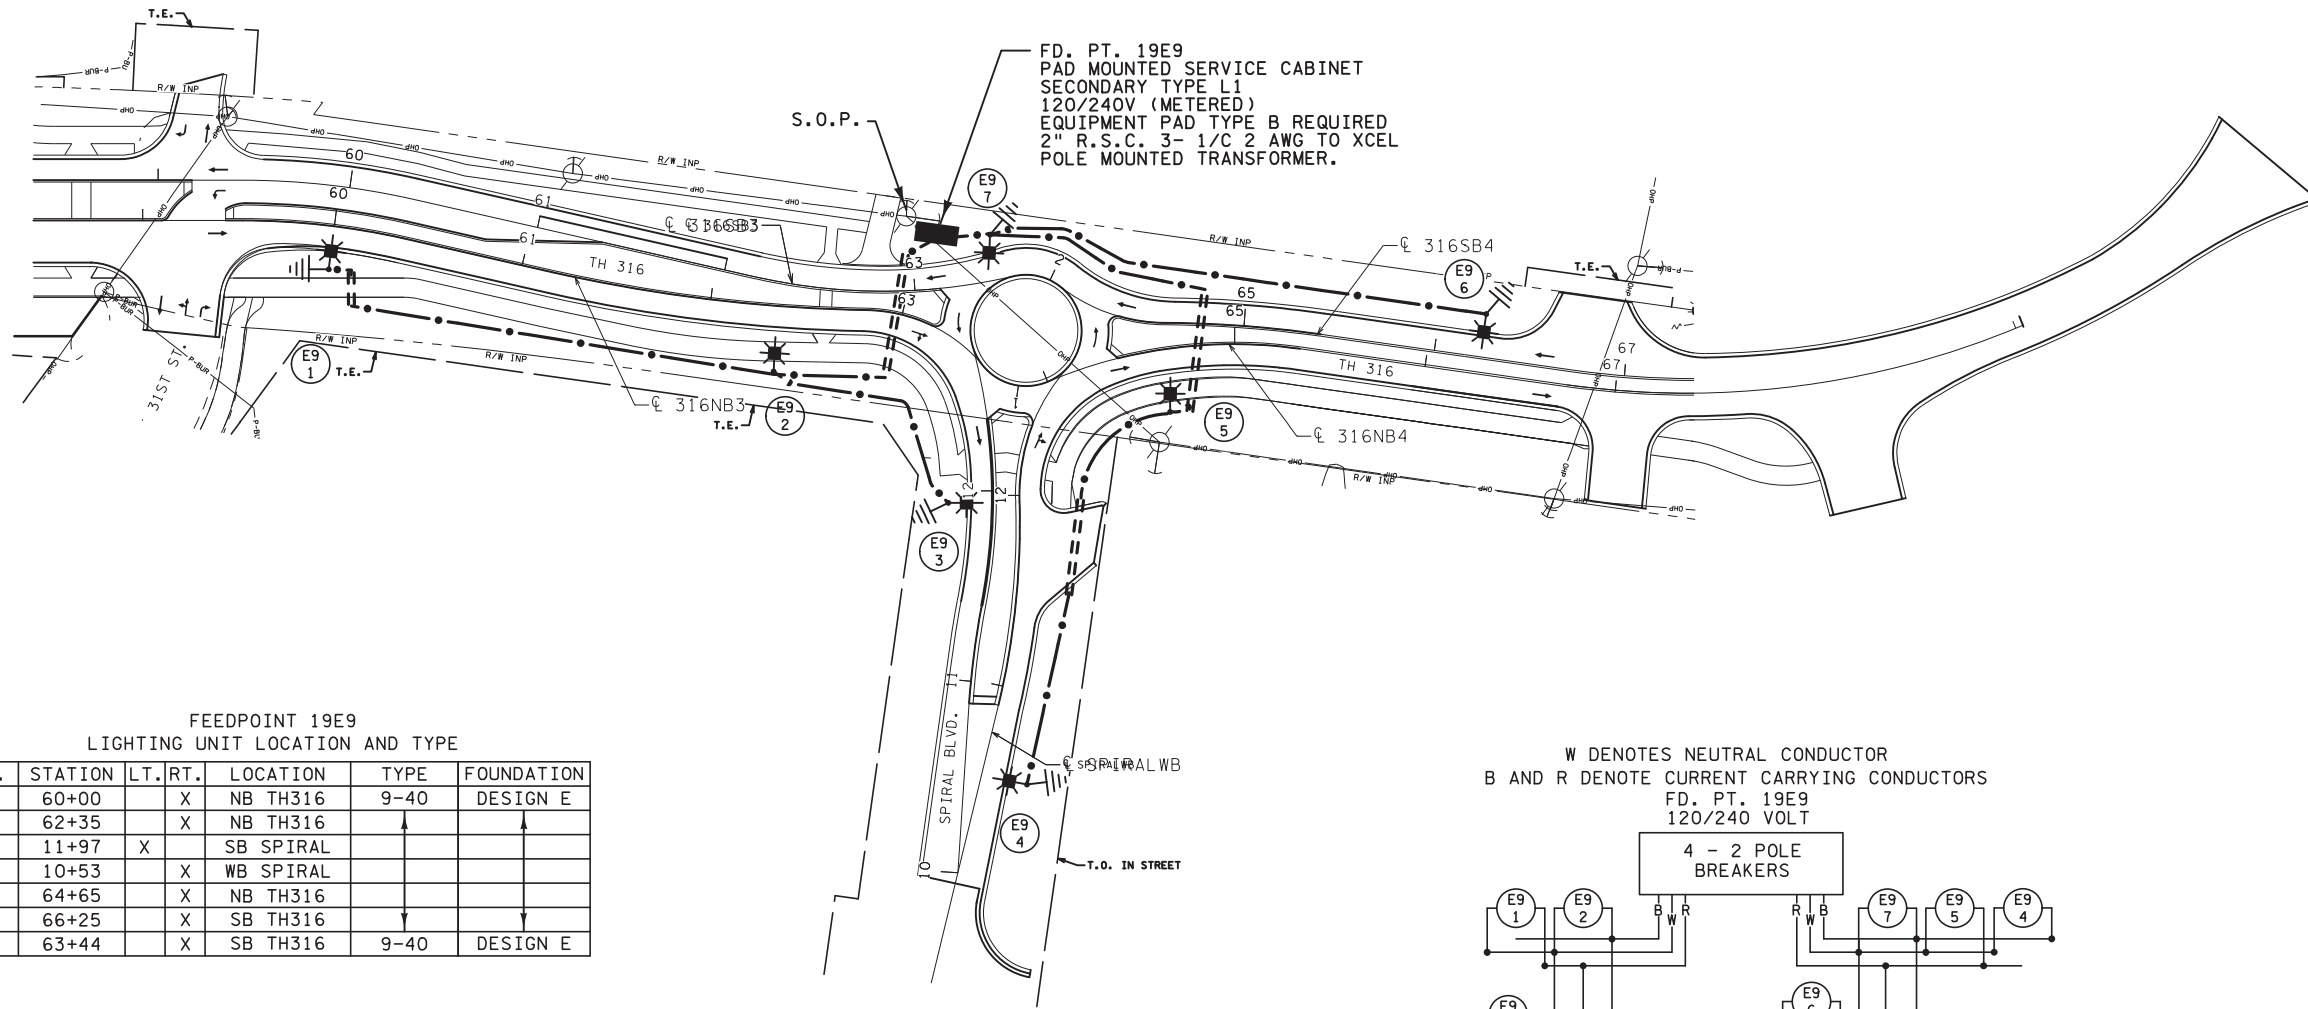
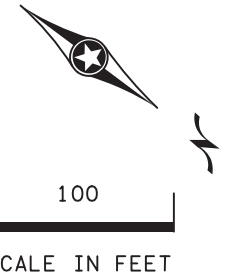


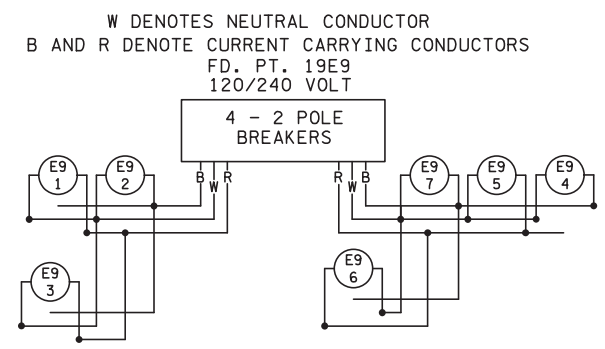
LEGEND

-  LIGHTING UNIT
-  PAD MOUNTED FD. PT. CABINET 120/240 VOLT
-  DIRECT BURIED LIGHTING CABLE 4/C 4 AWG
-  PERMANENT GROUND ROD (25 OHMS OR LESS)
-  3" PVC (UNLESS NOTED OTHERWISE)
-  LIGHTING UNIT IDENTIFIER
-  INPLACE UTILITY POLE




FEEDPOINT 19E9
LIGHTING UNIT LOCATION AND TYPE

NO.	STATION	LT.	RT.	LOCATION	TYPE	FOUNDATION
1	60+00		X	NB TH316	9-40	DESIGN E
2	62+35		X	NB TH316		
3	11+97	X		SB SPIRAL		
4	10+53		X	WB SPIRAL		
5	64+65		X	NB TH316		
6	66+25		X	SB TH316		
7	63+44		X	SB TH316	9-40	DESIGN E



DISTRICT #: Metro
 PLOT NAME: 1926-22_Lit_10
 PATH & FILENAME: Projects\DM_R05\316\1926\022\Traffic\Lighting\1926-22_Lit_10.dgn
 PLOTTED/REVISED: 25-JAN-2021

BY	DATE	REVISIONS	FEEDPOINT: 19E9 LOCATION: SPIRAL BLVD. METER ADDRESS: 3051 MN-316, HASTINGS, MN 55033	<h2 style="margin: 0;">LIGHTING PLAN</h2>
DRAWN BY: PB CKD BY: JC			CERTIFIED BY  LIC. NO. 19863 DATE: 25-JAN-2021 <small>LICENSED PROFESSIONAL ENGINEER</small>	STATE PROJ. NO. 1926-22 (T.H. 316) SHEET NO. SL5 OF SL5 SHEETS

S.A.P. 130-010-013