 




 
 

 
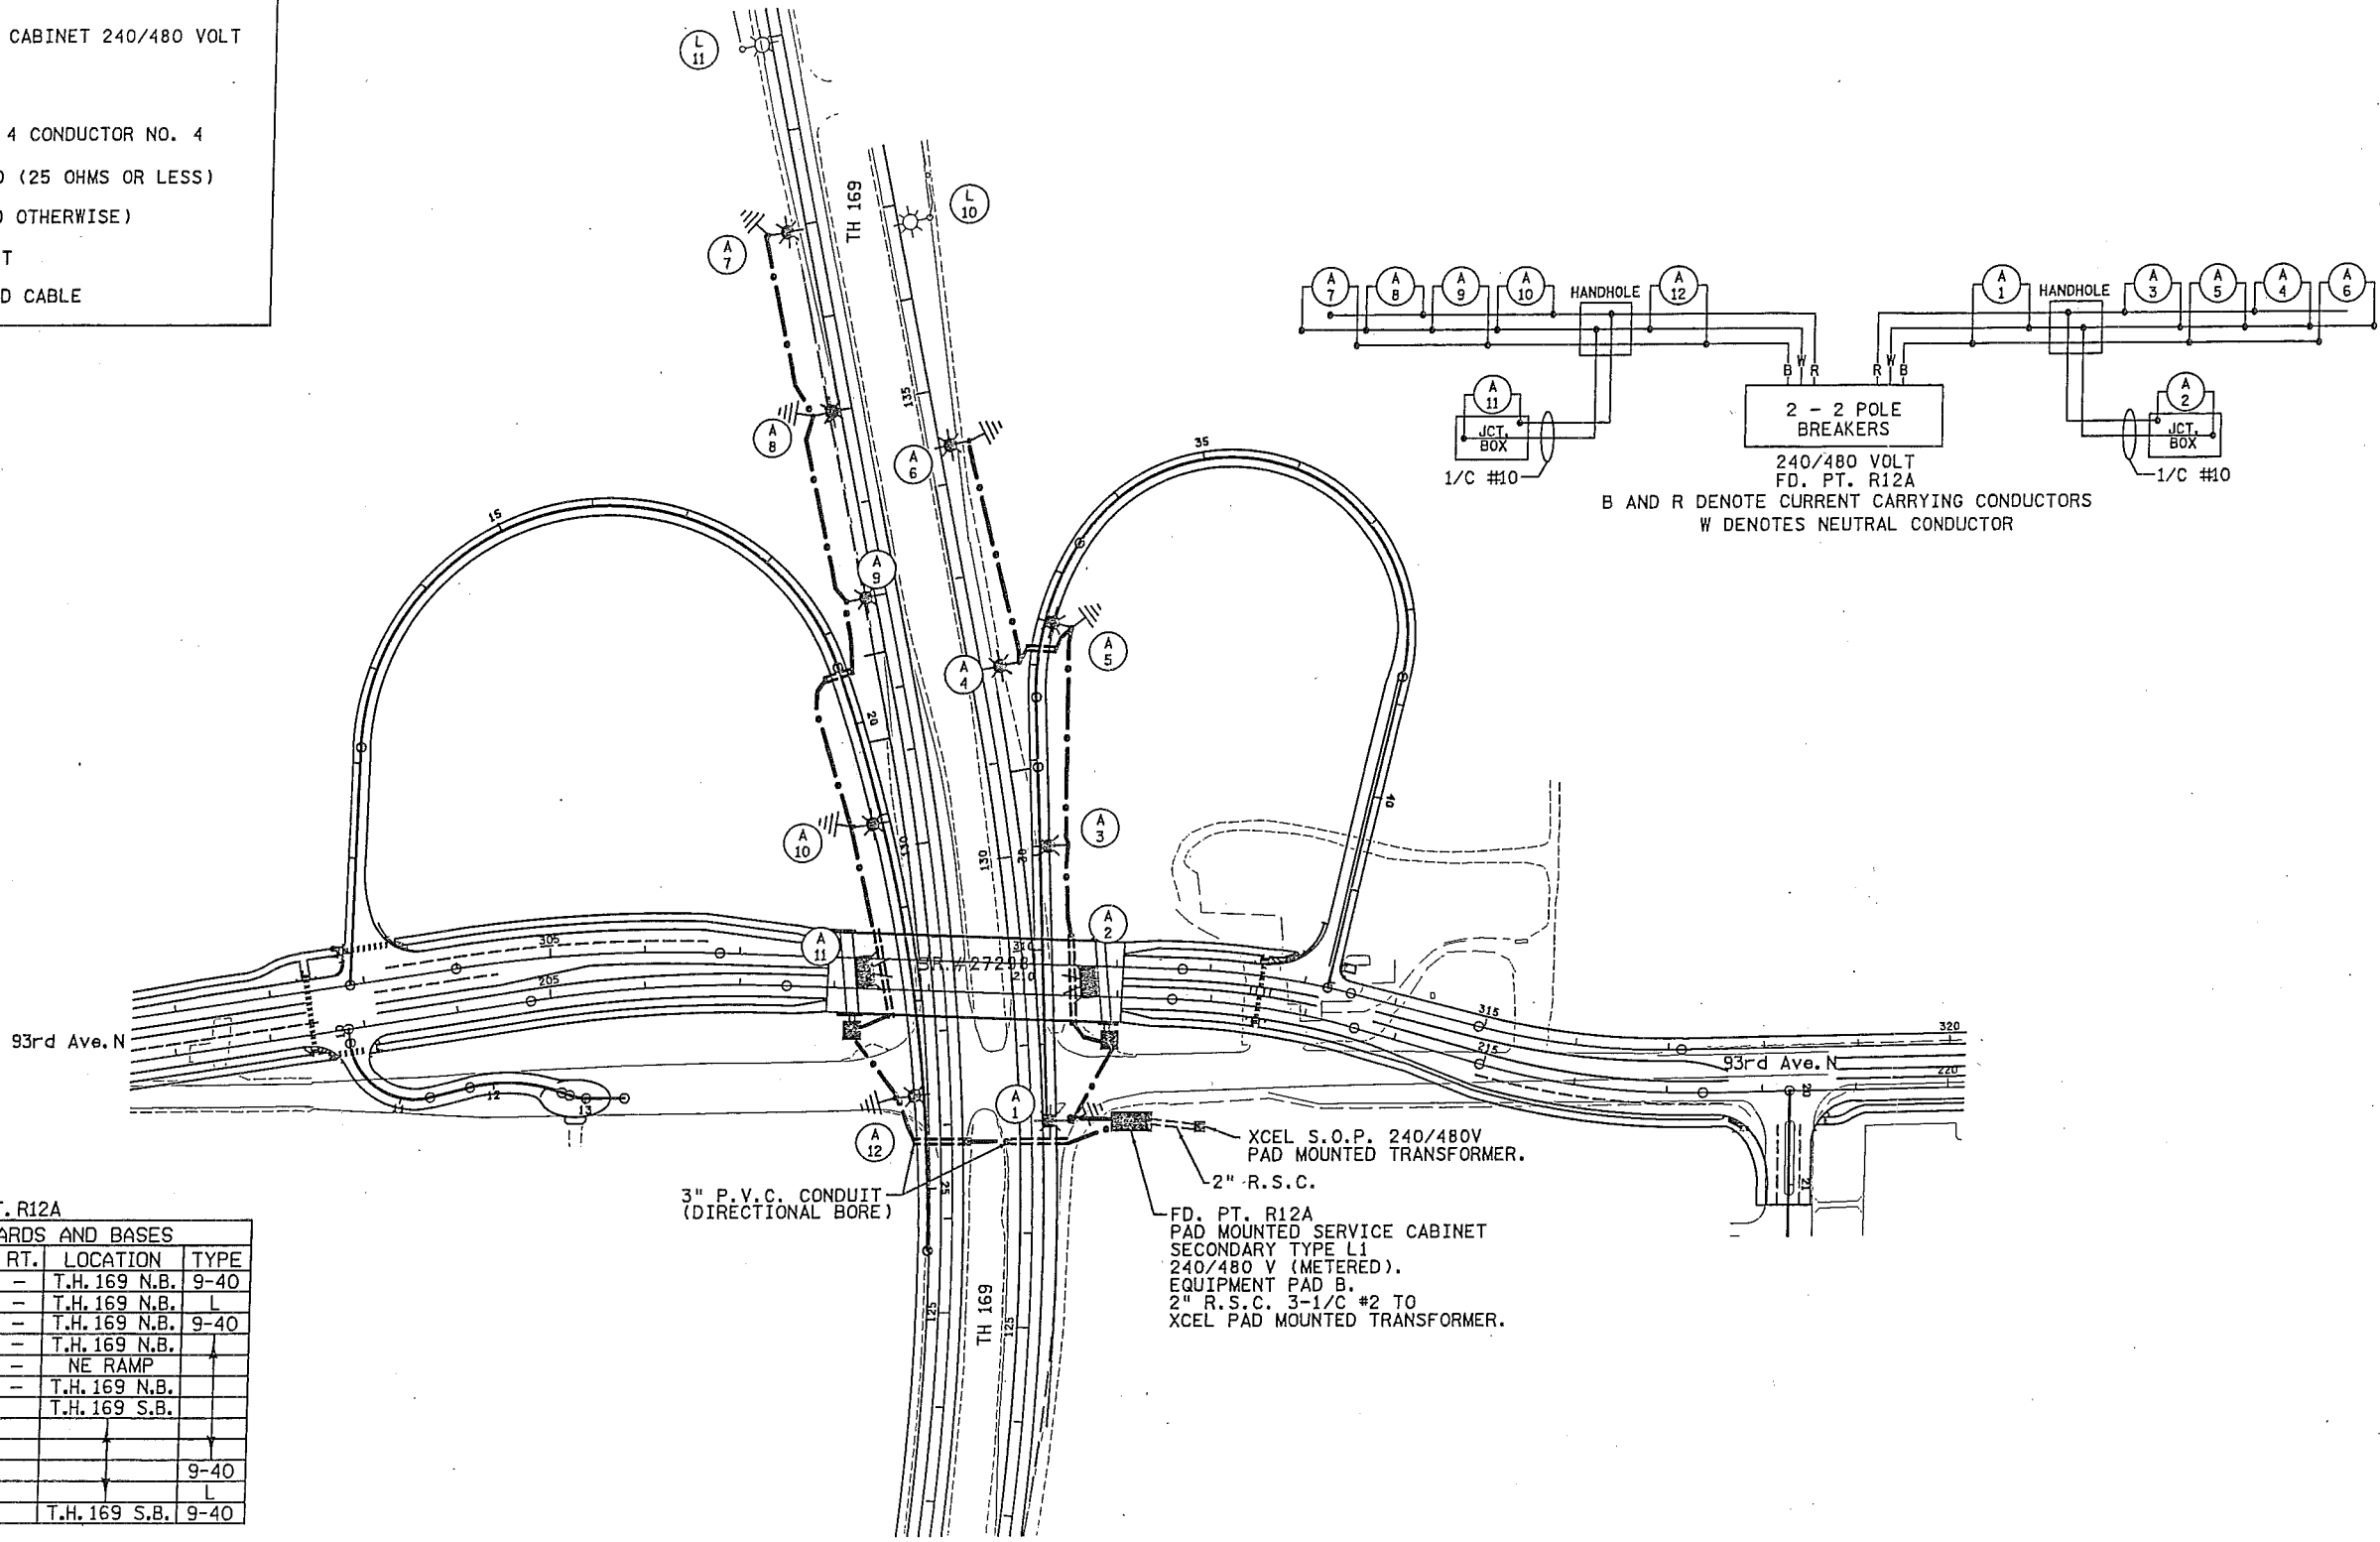


LEGEND

-  LIGHTING UNIT
-  UNDERPASS FIXTURE
-  PAD MOUNTED FD. PT. CABINET 240/480 VOLT
-  HANDHOLE
-  DIRECT BURIED CABLE 4 CONDUCTOR NO. 4
-  PERMANENT GROUND ROD (25 OHMS OR LESS)
-  3" PVC (UNLESS NOTED OTHERWISE)
-  INPLACE LIGHTING UNIT
-  INPLACE DIRECT BURIED CABLE



PLOTTED/REVISED: 6/26/2012



FD. PT. R12A

LIGHTING STANDARDS AND BASES

NO.	STATION	LT.	RT.	LOCATION	TYPE
1	127+20	-	-	T.H. 169 N.B.	9-40
2	128+60	-	-	T.H. 169 N.B.	L
3	130+05	-	-	T.H. 169 N.B.	9-40
4	132+00	-	-	T.H. 169 N.B.	↑
5	32+45	-	-	NE RAMP	↑
6	134+40	-	-	T.H. 169 N.B.	↑
7	136+95	-	-	T.H. 169 S.B.	↑
8	135+00	-	-		↑
9	133+00	-	-		↑
10	130+30	-	-		9-40
11	128+70	-	-		L
12	127+30	-	-	T.H. 169 S.B.	9-40

FEED POINT R12A

BY	DATE	REVISIONS	FEEDPOINT: R12A	LOCATION: T.H. 169 & 93rd Ave.	LIGHTING PLAN
			METER ADDRESS: 8303 93rd Ave, Brooklyn Park 55445		
DRAWN BY: PB			CERTIFIED BY <i>Michael P. Gubusky</i>		STATE PROJ. NO. 2750-75 (T.H. 169)
CKD BY: GB			LIC. NO. 19863		SHEET NO. SL4 OF SL4 SHEETS
DATE: 6/2012			DATE: 6/26/2012		S.A.P. 027-630-014

DISTRICT: METRO
 IPLOT NAME: 12750-75.IJ
 PATH & FILENAME: IP_PWP-d\385435\2750-75.IJ.dgn