

 
 
 

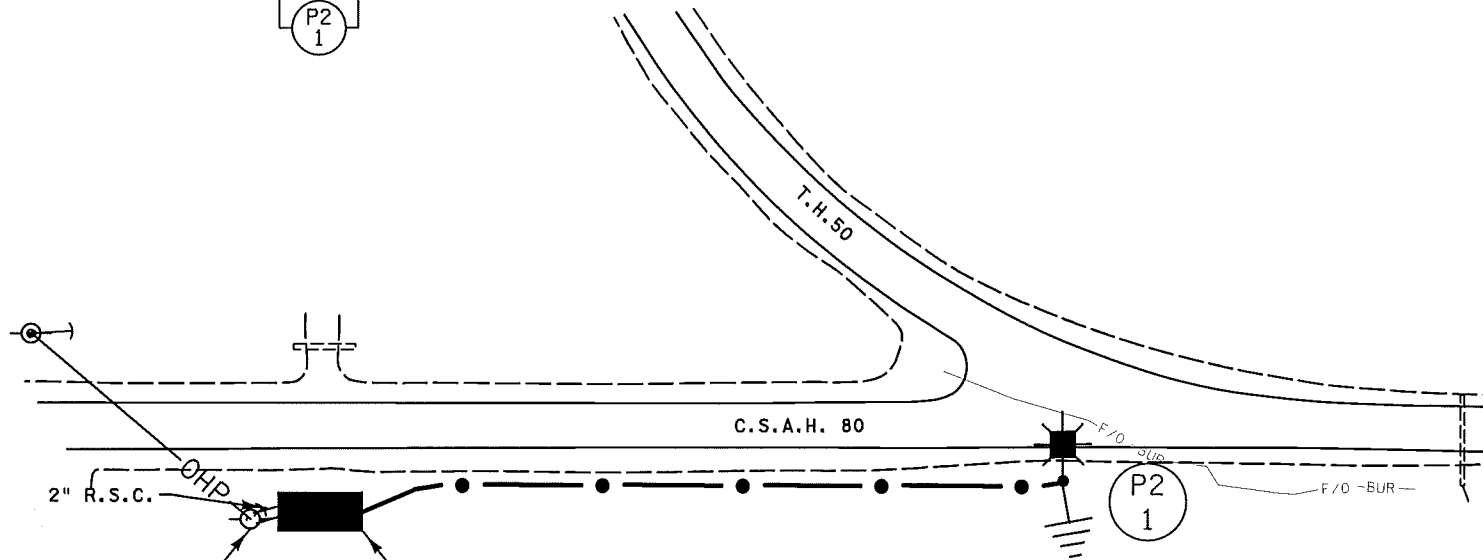
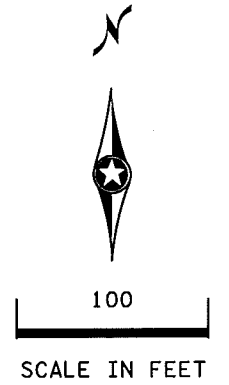
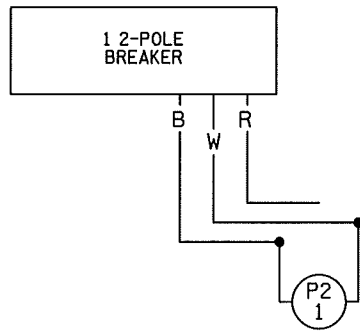


# LEGEND

-  LIGHTING UNIT
-  PAD MOUNTED FD. PT. CABINET 120/240 VOLT EQUIPMENT PAD
-  DIRECT BURIED CABLE 4 CONDUCTOR #4
-  PERMANENT GROUND ROD (25 OHMS OR LESS)
-  2" RIGID STEEL CONDUIT (R.S.C.)
-  INPLACE POWER POLE

UTILITY OWNERSHIP	
OVERHEAD ELECTRIC — OHP —	DAKOTA ELECTRIC ASSOC.
BURIED FIBER — F/O -BUR —	CHARTER COMMUNICATIONS

B AND R DENOTE CURRENT CARRYING CONDUCTORS  
W DENOTES NEUTRAL CONDUCTOR  
FD. PT. 19P2  
120/240 VOLT



S.O.P. DAKOTA ELECTRIC ASSOC.  
POLE MOUNTED TRANSFORMER

FD. PT. 19P2  
PAD MOUNTED SERVICE CABINET  
TYPE RURAL LIGHTING AND FLASHING (RLF)  
120/240V (METERED)  
GROUND MOUNTED CAB. FOUNDATION.  
2" R.S.C. 3-1/C #2 to DAKOTA  
ELECTRIC TRANSFORMER.

FEEDPOINT 19P2  
LIGHTING STANDARDS AND FOUNDATIONS

NO.	STATION	LT.	RT.	LOCATION	TYPE
1	AS SHOWN		X	WB CSAH 80	9-40 LED

PLOTTED/REVISED: 2/5/2015

DISTRICT #: METRO  
IPLOT NAME: 18825-389-AS-BUILT  
PATH & FILENAME: IP\_PWP-d1562293V8825-389-AS-BUILT.dgn

BY	DATE	REVISIONS	FEEDPOINT: 19P2	LOCATION: T.H. 50 at C.S.A.H. 80	<b>LIGHTING PLAN</b>
EK	02/2015	ASBUILTS: NO CHANGES	METER ADDRESS: 5138 CTY RD 80, HAMPTON 55031.		
DRAWN BY: PB    CKD BY: GB    DATE: 10/2013			CERTIFIED BY: <i>Michael P. Gubensky</i> LIC. NO. 19863    DATE: 2/5/2015		STATE PROJ. NO. 8825-389
					SHEET NO. 7 OF 13 SHEETS