 


 
 

 
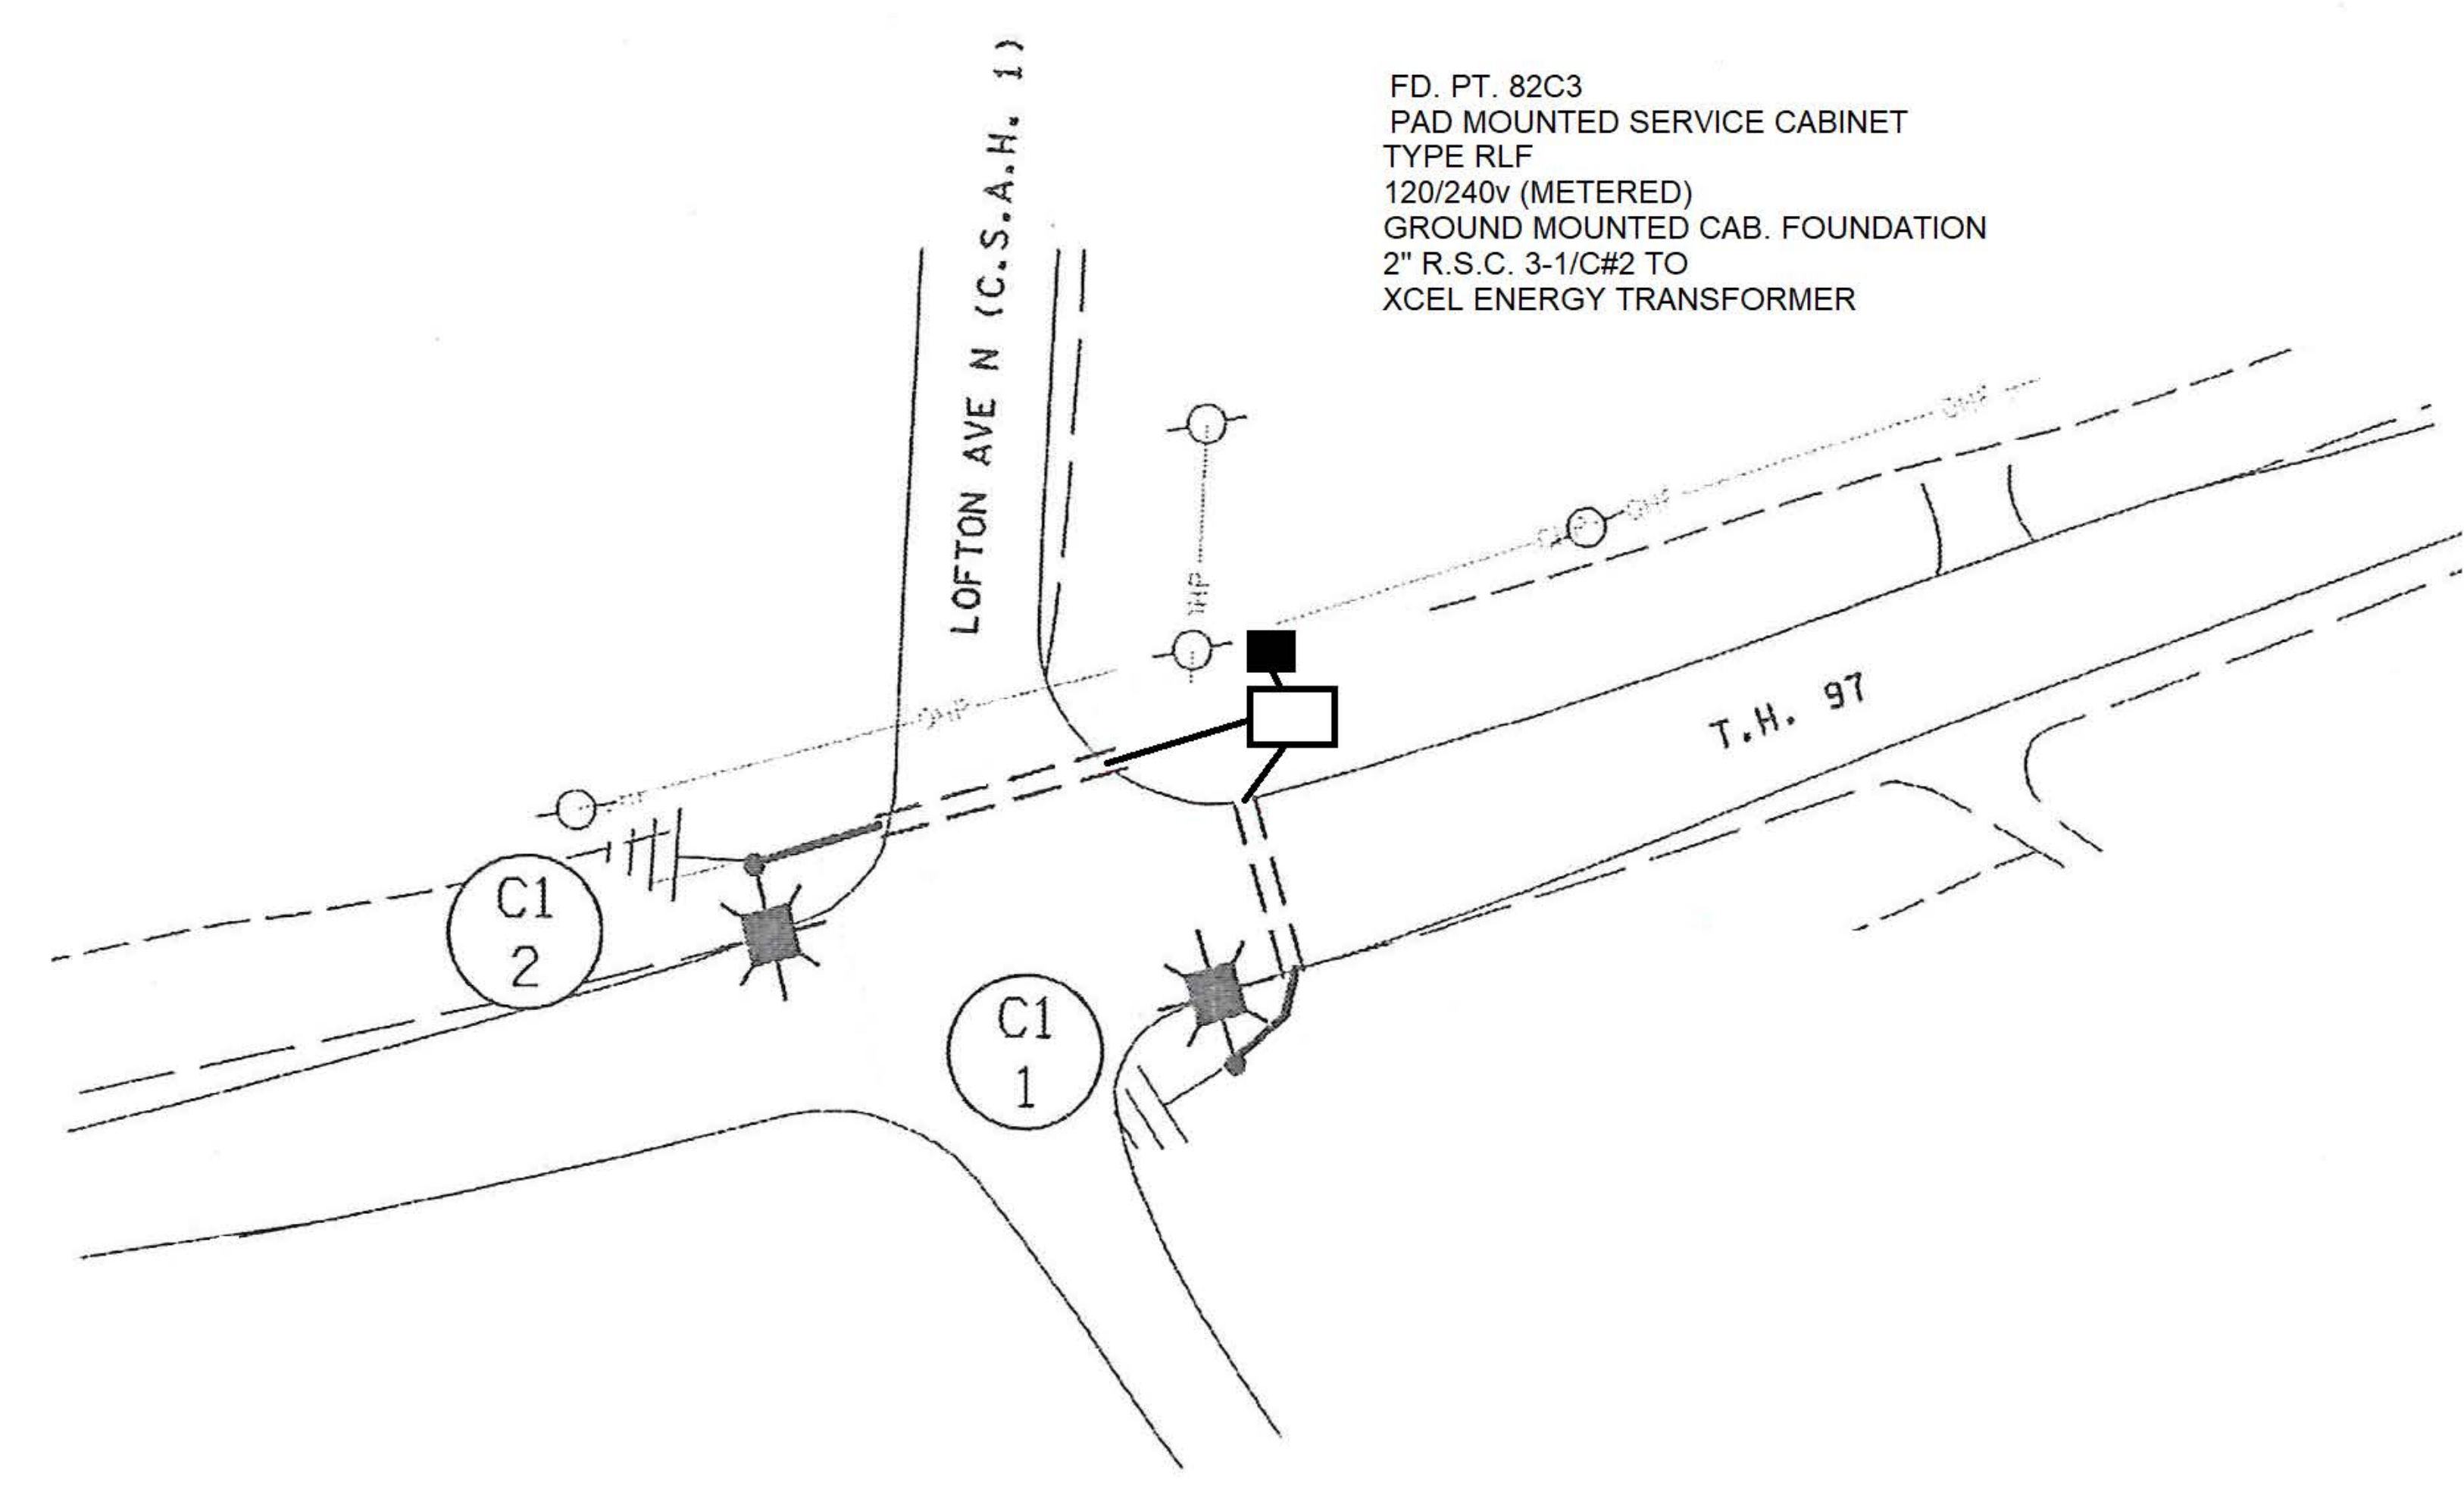
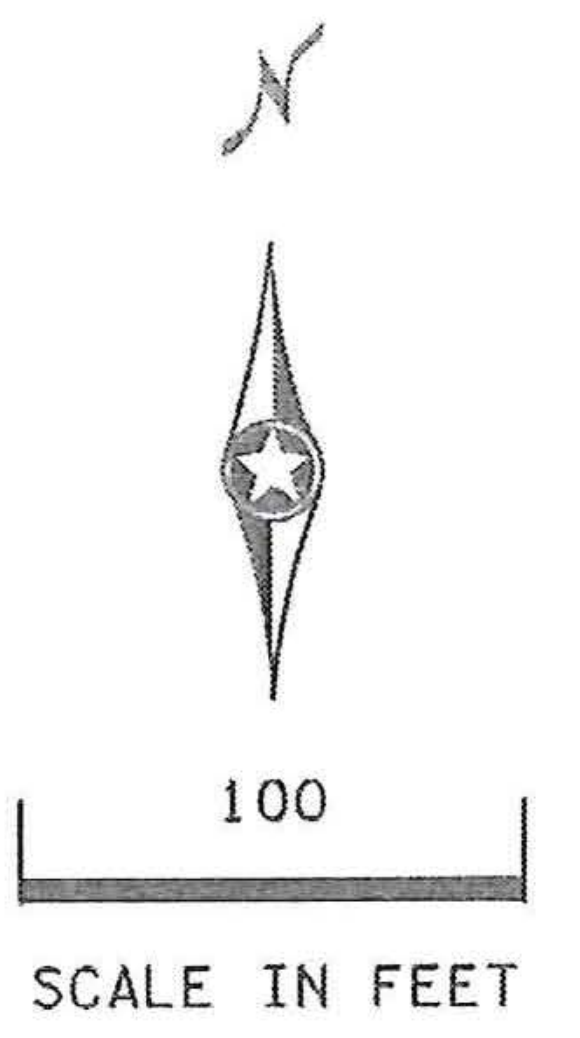
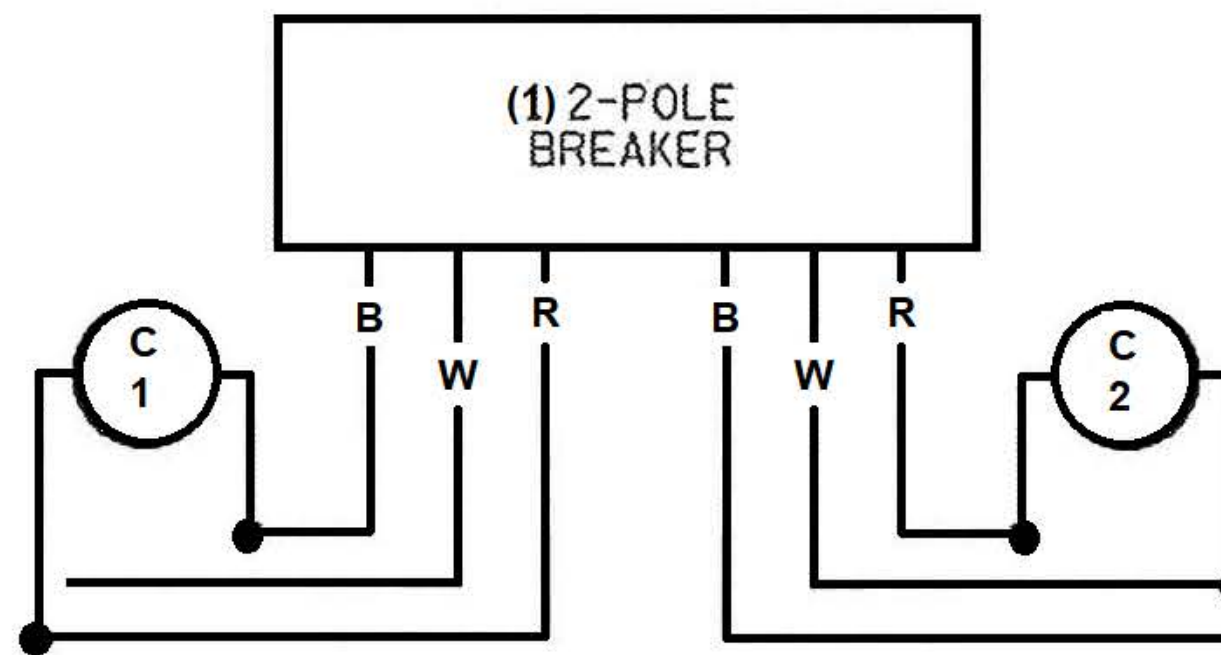


LEGEND

-  LIGHTING UNIT
-  PAD MOUNTED FD. PT. CABINET 120/240 VOLT EQUIPMENT PAD
-  DIRECT BURIED CABLE 4 CONDUCTOR #4
-  PERMANENT GROUND ROD (25 OHMS OR LESS)
-  3" CONTINUOUS NMC BORED (UNLESS NOTED OTHERWISE)
-  INPLACE POWER POLE
-  OVERHEAD POWER LINES

UTILITY OWNERSHIP	
BURIED GAS — G —	XCEL ENERGY
BURIED FIBER — F/O -BUR —	FRONTIER COMMUNICATIONS OF MINNESOTA
OVERHEAD ELECTRIC — OHP —	CONNEXUS ENERGY
BURIED ELECTRIC — P-BUR —	XCEL ENERGY

B AND R DENOTE CURRENT CARRYING CONDUCTORS  
W DENOTES NEUTRAL CONDUCTOR  
82C1  
120/240 VOLT



FD. PT. 82C3  
PAD MOUNTED SERVICE CABINET  
TYPE RLF  
120/240v (METERED)  
GROUND MOUNTED CAB. FOUNDATION  
2" R.S.C. 3-1/2#2 TO  
XCEL ENERGY TRANSFORMER

FEEDPOINT 82C1  
LIGHTING STANDARDS AND FOUNDATIONS

NO.	STATION	LT. RT.	LOCATION	TYPE
1	AS SHOWN	X	EB TH97	9-40 LED
2	AS SHOWN	X	WB TH97	9-40 LED

PLOTTED/REVISED: 3/13/2014

DISTRICT #: METRO  
IPLOT NAME: 18825-3891107  
PATH & FILENAME: IP\_PWP-d1562293Y8825-3891107.dgn

AS-BUILT

BY	DATE	REVISIONS	FEEDPOINT: 82C1 LOCATION: T.H. 97 at C.S.A.H. 1 (LOFTON AVE N) METER ADDRESS: 11909 SCANDIA TRAIL N., NEW SCANDIA TWP, 55073	LIGHTING PLAN & UTILITIES	
				CERTIFIED BY: <i>Michael P. Lubensky</i> LIC. NO. 19863 DATE: 3/13/2014	STATE PROJ. NO. 8825-389 SHEET NO. 11 OF 13 SHEETS
DRAWN BY: PB	CKD BY: GB	DATE: 10/2013			