 



 
 
 
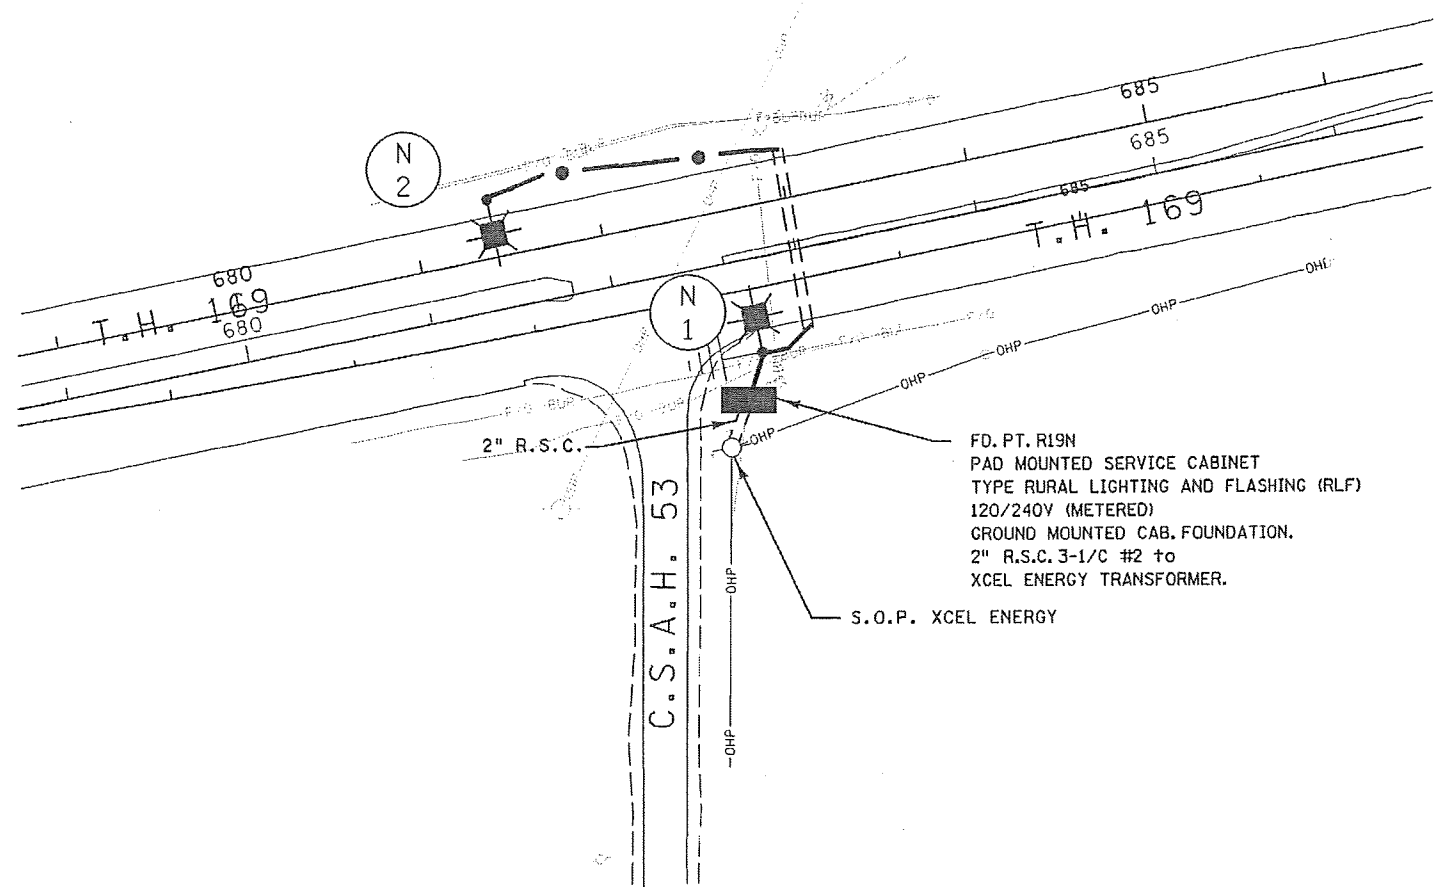
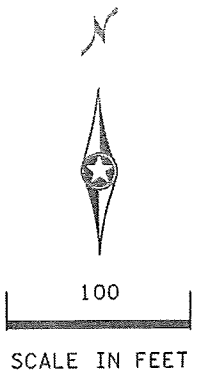
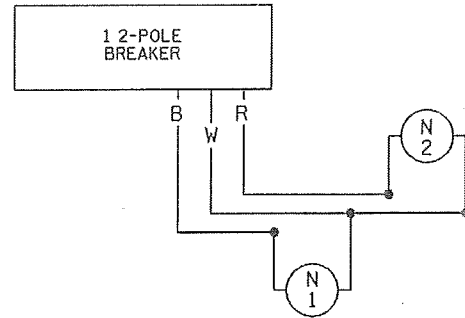


# LEGEND

-  LIGHTING UNIT
-  PAD MOUNTED FD. PT. CABINET 120/240 VOLT
-  DIRECT BURIED CABLE 4 CONDUCTOR NO. 4
-  PERMANENT GROUND ROD (25 OHMS OR LESS)
-  3" CONTINUOUS NMC BORED (UNLESS NOTED OTHERWISE)
-  INPLACE POWER POLE
-  OVERHEAD POWER LINES

UTILITY OWNERSHIP	
BURIED FIBER - F/O - BUR -	ACCESS COMMUNICATIONS CENTURYLINK FRONTIER
OVERHEAD ELECTRIC - OHP -	XCEL ENERGY
BURIED TELEPHONE - T-BUR -	HICKORYTECH

B AND R DENOTE CURRENT CARRYING CONDUCTORS  
W DENOTES NEUTRAL CONDUCTOR  
FD. PT. R19N  
120/240 VOLT



FEEDPOINT R19N  
LIGHTING STANDARDS AND FOUNDATIONS

NO.	STATION	LT.	RT.	LOCATION	TYPE
1	AS SHOWN	X		NB TH169	9-40 LED
2	AS SHOWN		X	SB TH169	9-40 LED

PLOTTED/REVISED: 3/13/2014

DISTRICT #: METRO  
I/PLOT NAME: 18825-389J1.dwg  
PATH & FILENAME: IP\_PWP-d1562293Y8825-389J1.dwg

BY	DATE	REVISIONS	FEEDPOINT: R19N LOCATION: T.H. 169 at C.S.A.H. 53 METER ADDRESS: 23975 JOHNSON MEMORIAL DR, BELLE PLAINE 56011.	LIGHTING PLAN	
			CERTIFIED BY <i>Michael P. Gubensky</i> LIC. NO. 19863 DATE: 3/13/2014	STATE PROJ. NO. 8825-389	SHEET NO. 12 OF 13 SHEETS
DRAWN BY: PB CKD BY: GB DATE: 10/2013					