


 



 
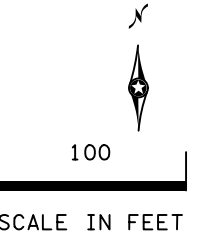



LEGEND

-  LIGHTING UNIT
-  FD. PT. CABINET
-  DIRECT BURIED CABLE 4 CONDUCTOR NO. 4
-  3" NMC DIRECTIONAL BORE (UNLESS OTHERWISE NOTED)
-  PERMANENT GROUND ROD (25 OHMS OR LESS)
-  DAKOTA ELECTRIC PEDESTAL
-  LIGHTING UNIT IDENTIFIER
-  UTILITY POLE




PLOTTED/REVISED: 22-MAR-2018

DISTRICT #: Metro
 I/PLOT NAME: 1906-65.Itr,laAB
 PATH & FILENAME: Projects\DM_R0S\052\1906-65\Traffic\Lighting\1906-65.Itr,laAB.dgn

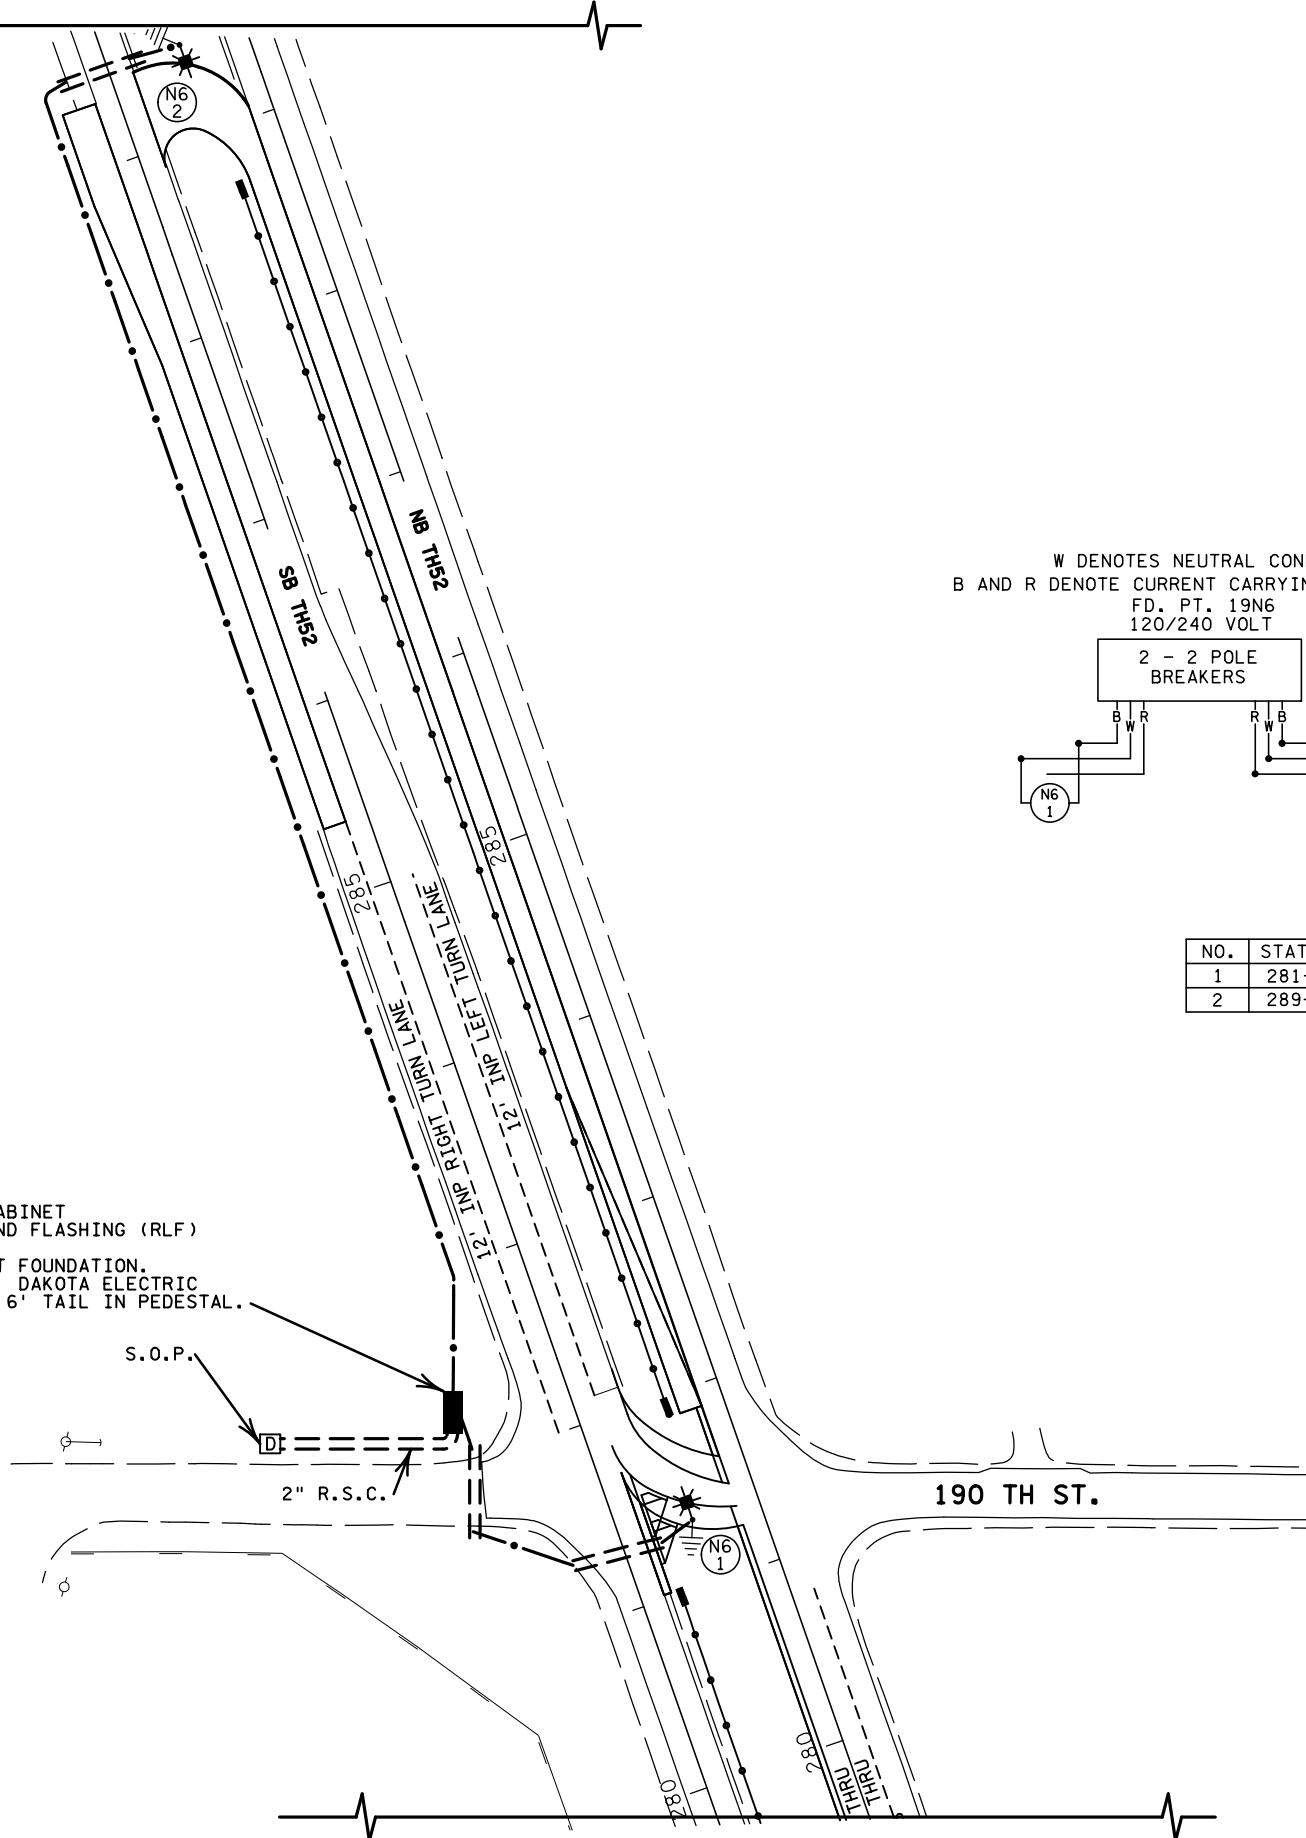

FD. PT. 19N6
 PAD MOUNTED SERVICE CABINET
 TYPE RURAL LIGHTING AND FLASHING (RLF)
 120/240V (METERED)
 GROUND MOUNTED CABINET FOUNDATION.
 2" R.S.C. 3-1/2" #2 TO DAKOTA ELECTRIC
 ASSOC PEDESTAL. LEAVE 6' TAIL IN PEDESTAL.


W DENOTES NEUTRAL CONDUCTOR
 B AND R DENOTE CURRENT CARRYING CONDUCTORS
 FD. PT. 19N6
 120/240 VOLT

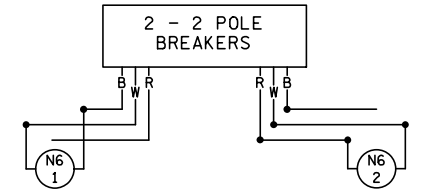

FEEDPOINT 19N6
 LIGHTING UNIT LOCATION AND TYPE

NO.	STATION	LT.	RT.	LOCATION	TYPE	FOUNDATION
1	281+35	X		NB TH52	9-40 LED	DESIGN E
2	289+48	X		NB TH52	9-40 LED	DESIGN E

FEED POINT 19N6

BY	DATE	REVISIONS	FEEDPOINT: 19N6	LOCATION: 190TH ST.	<h2>LIGHTING PLAN</h2>
JC	03-2018	UPDATE FEED POINT NUMBER	METER ADDRESS: 18975 HIGHWAY 52, VERMILLION TWP 55033 ST		
DRAWN BY: PB			CERTIFIED BY  LIC. NO. 19863 DATE: 22-MAR-2018		STATE PROJ. NO. 1906-65 (T.H. 52) SHEET NO. SL7 OF SL8 SHEETS
CKD BY: GK					