

 
 








LEGEND

-  LIGHTING UNIT
-  FD. PT. CABINET
-  DIRECT BURIED CABLE 4 CONDUCTOR NO. 4
-  3" NMC DIRECTIONAL BORE (UNLESS OTHERWISE NOTED)
-  PERMANENT GROUND ROD (25 OHMS OR LESS)
-  DAKOTA ELECTRIC PEDESTAL
-  LIGHTING UNIT IDENTIFIER
-  UTILITY POLE




PLOTTED/REVISED: 3/14/2017

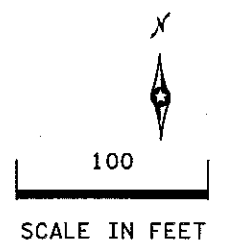DISTRICT: METRO
 PLOT NAME: 1906-65/JH.103
 PATH & FILENAME: IP_PWP-d1841325v1906-65/jf-10.dgn

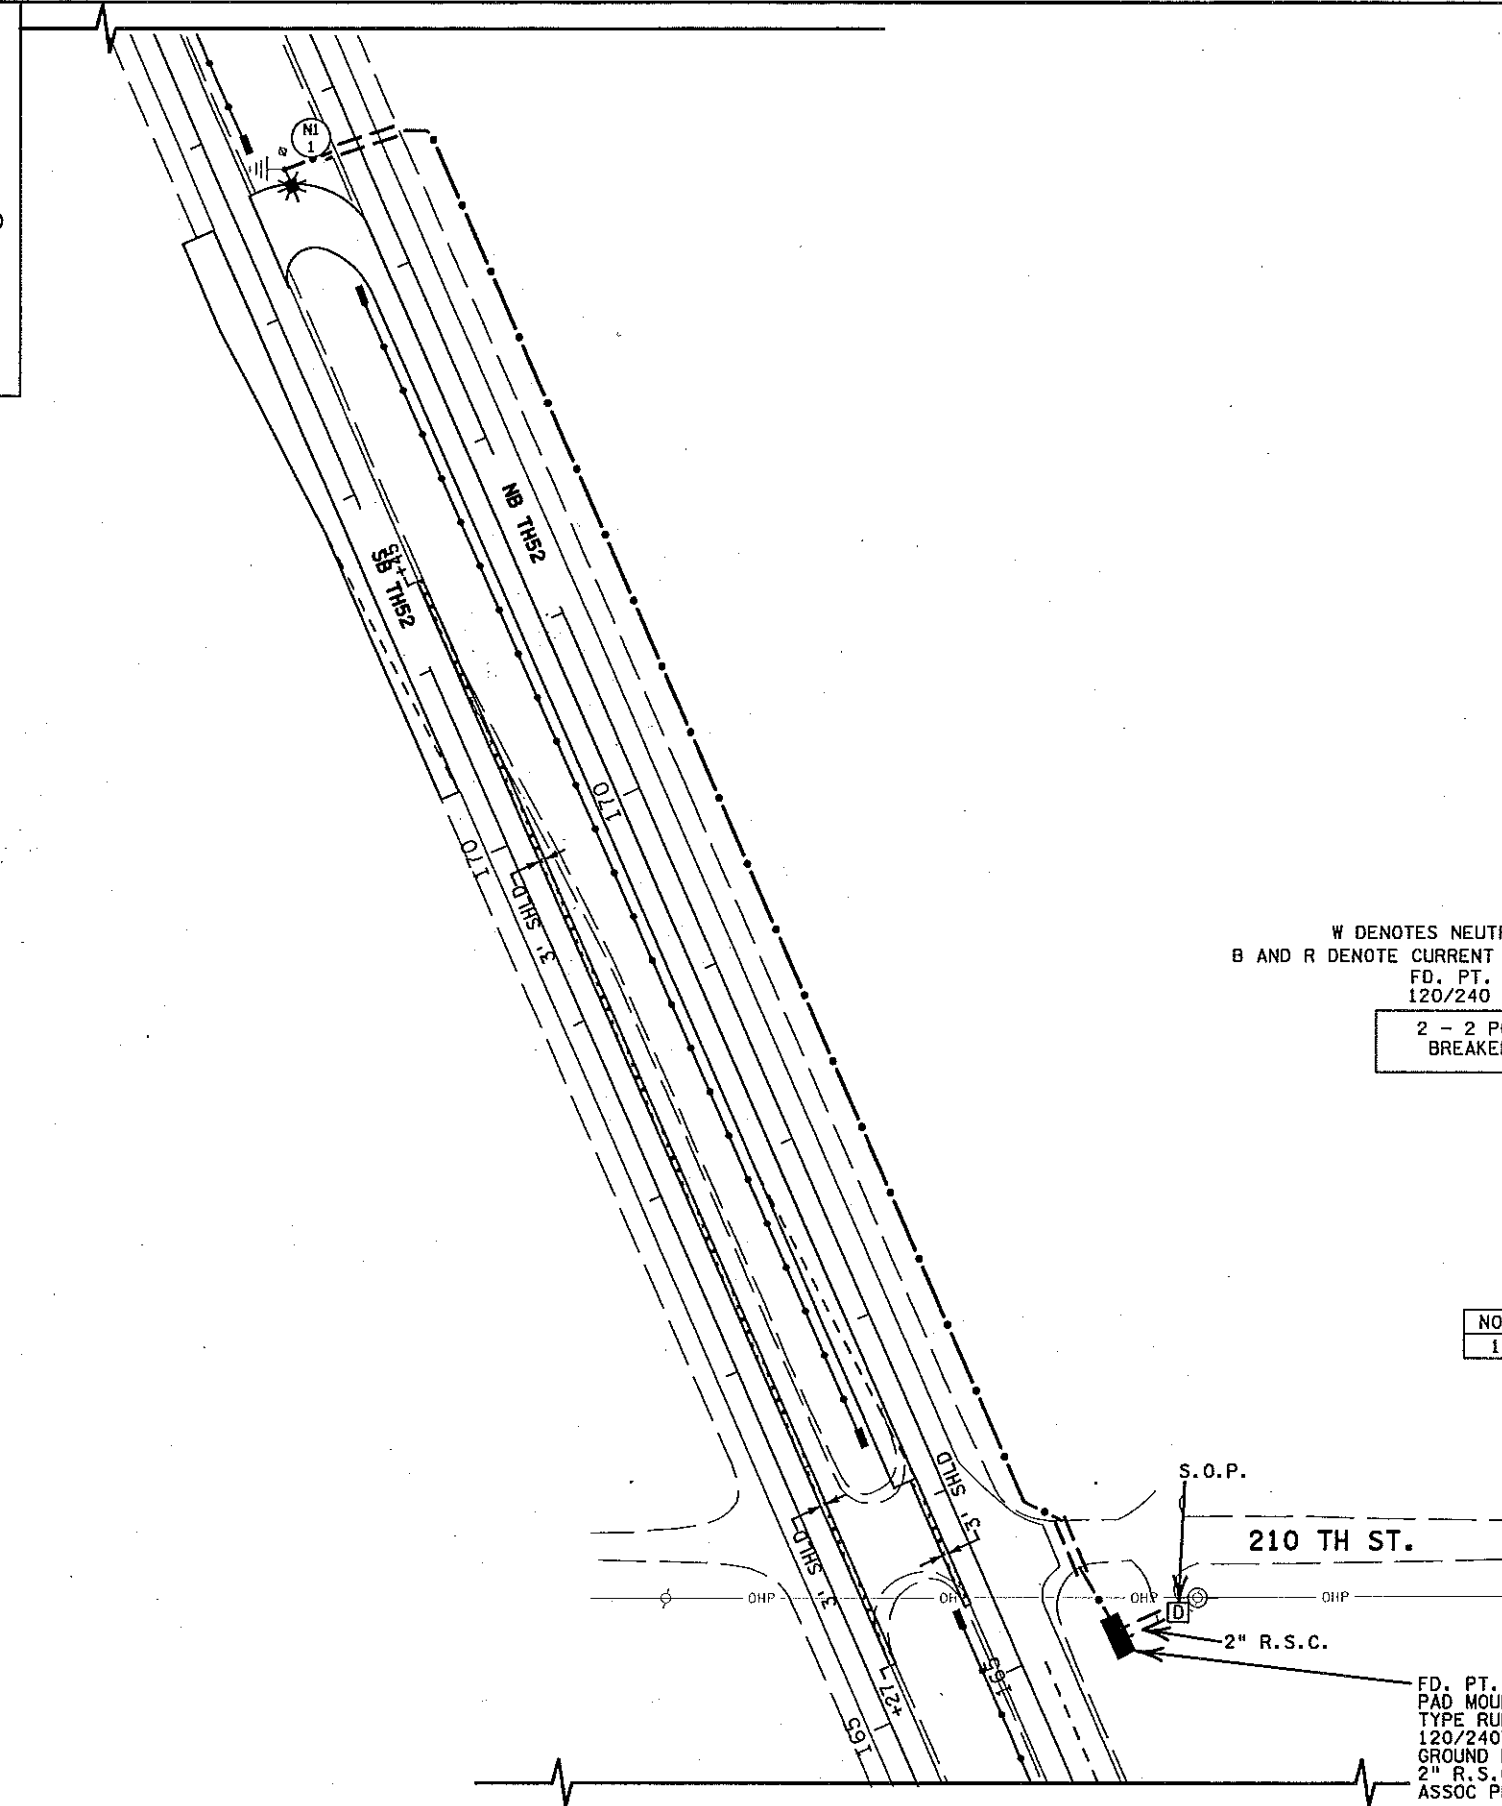

W DENOTES NEUTRAL CONDUCTOR
 B AND R DENOTE CURRENT CARRYING CONDUCTORS
 FD. PT. 19N1
 120/240 VOLT

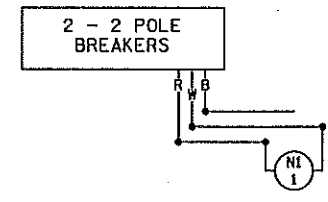

FEEDPOINT 19N1
 LIGHTING UNIT LOCATION AND TYPE

NO.	STATION	LT.	RT.	LOCATION	TYPE	FOUNDATION
1	173+70		X	SB TH52	9-40 LED	DESIGN E

FD. PT. 19N1
 PAD MOUNTED SERVICE CABINET
 TYPE RURAL LIGHTING AND FLASHING (RLF)
 120/240V (METERED)
 GROUND MOUNTED CABINET FOUNDATION.
 2" R.S.C. 3-1/C #2 TO DAKOTA ELECTRIC
 ASSOC PEDESTAL. LEAVE 6' TAIL IN PEDESTAL.

FEED POINT 19N1

	BY	DATE	REVISIONS	FEEDPOINT: 19N1 LOCATION: NEAR 210TH ST METER ADDRESS: 21010 HIGHWAY 52, VERMILLION TWP 55033	LIGHTING PLAN
				CERTIFIED BY <u>Michael P. Libensky</u> LIC. NO. <u>19863</u> DATE: <u>3/14/2017</u>	STATE PROJ. NO. 1906-65 (T.H. 52) SHEET NO. SL6 OF SL8 SHEETS
	DRAWN BY: PB CKD BY: GK				