


 

 
 
 
 
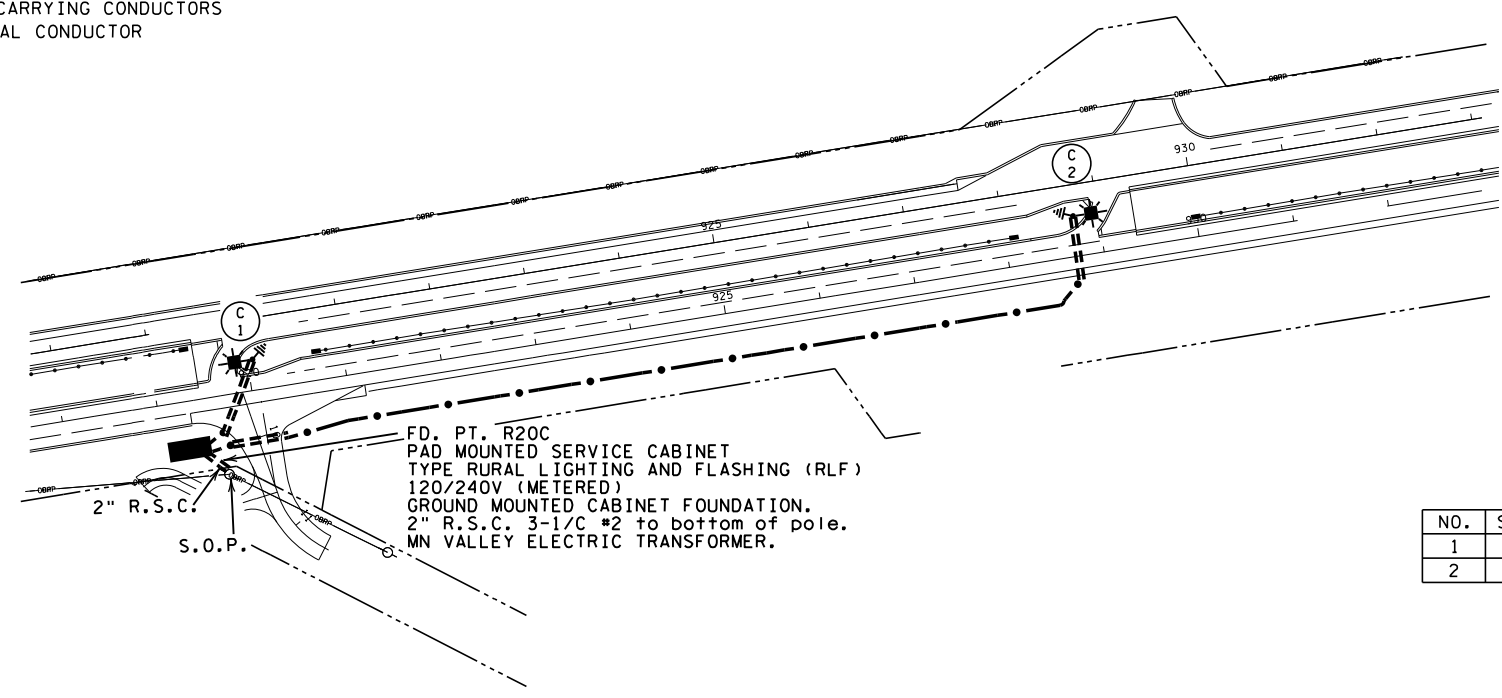
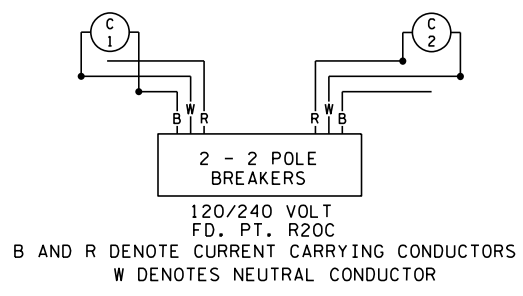
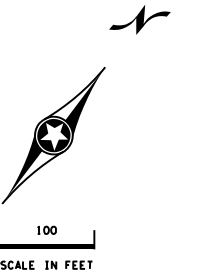


**LEGEND**

-  LIGHTING UNIT
-  FD. PT. CABINET (PROPOSED)
-  DIRECT BURIED CABLE 4 CONDUCTOR NO. 4
-  3" NMC DIRECTIONAL BORE (UNLESS OTHERWISE NOTED)
-  PERMANENT GROUND ROD (25 OHMS OR LESS)
-  LIGHTING UNIT IDENTIFIER
-  UTILITY POLE
-  OVERHEAD POWER LINES
-  INPLACE R/W



FEEDPOINT R20C LIGHTING UNIT LOCATION AND TYPE


NO.	STATION	LT.	RT.	LOCATION	TYPE	FOUNDATION
1	919+41	X		NB169	9-40 LED	DESIGN E
2	929+39	X		NB169	9-40 LED	DESIGN E

PLOTTED/REVISED: 6-FEB-2019

I/PLOT NAME: 17008-111.lit.AB  
PATH & FILENAME: Projects\DM\_R05\697008\111\Traffic\Lighting\17008-111.lit.AB.dgn

BY	DATE	REVISIONS
DRAWN BY: PB		CKD BY: GK

FEEDPOINT: R20C      LOCATION: CR 66 and PARK BLVD.  
METER ADDRESS: 21701 JOHNSON MEMORIAL ROAD, BELLE PLAINE 56011

CERTIFIED BY  LIC. NO. 19863    DATE: 6-FEB-2019  
LICENSED PROFESSIONAL ENGINEER

**LIGHTING PLAN**

STATE PROJ. NO. 7008-111 (T.H. 169) SHEET NO. SL3 OF SL4 SHEETS