
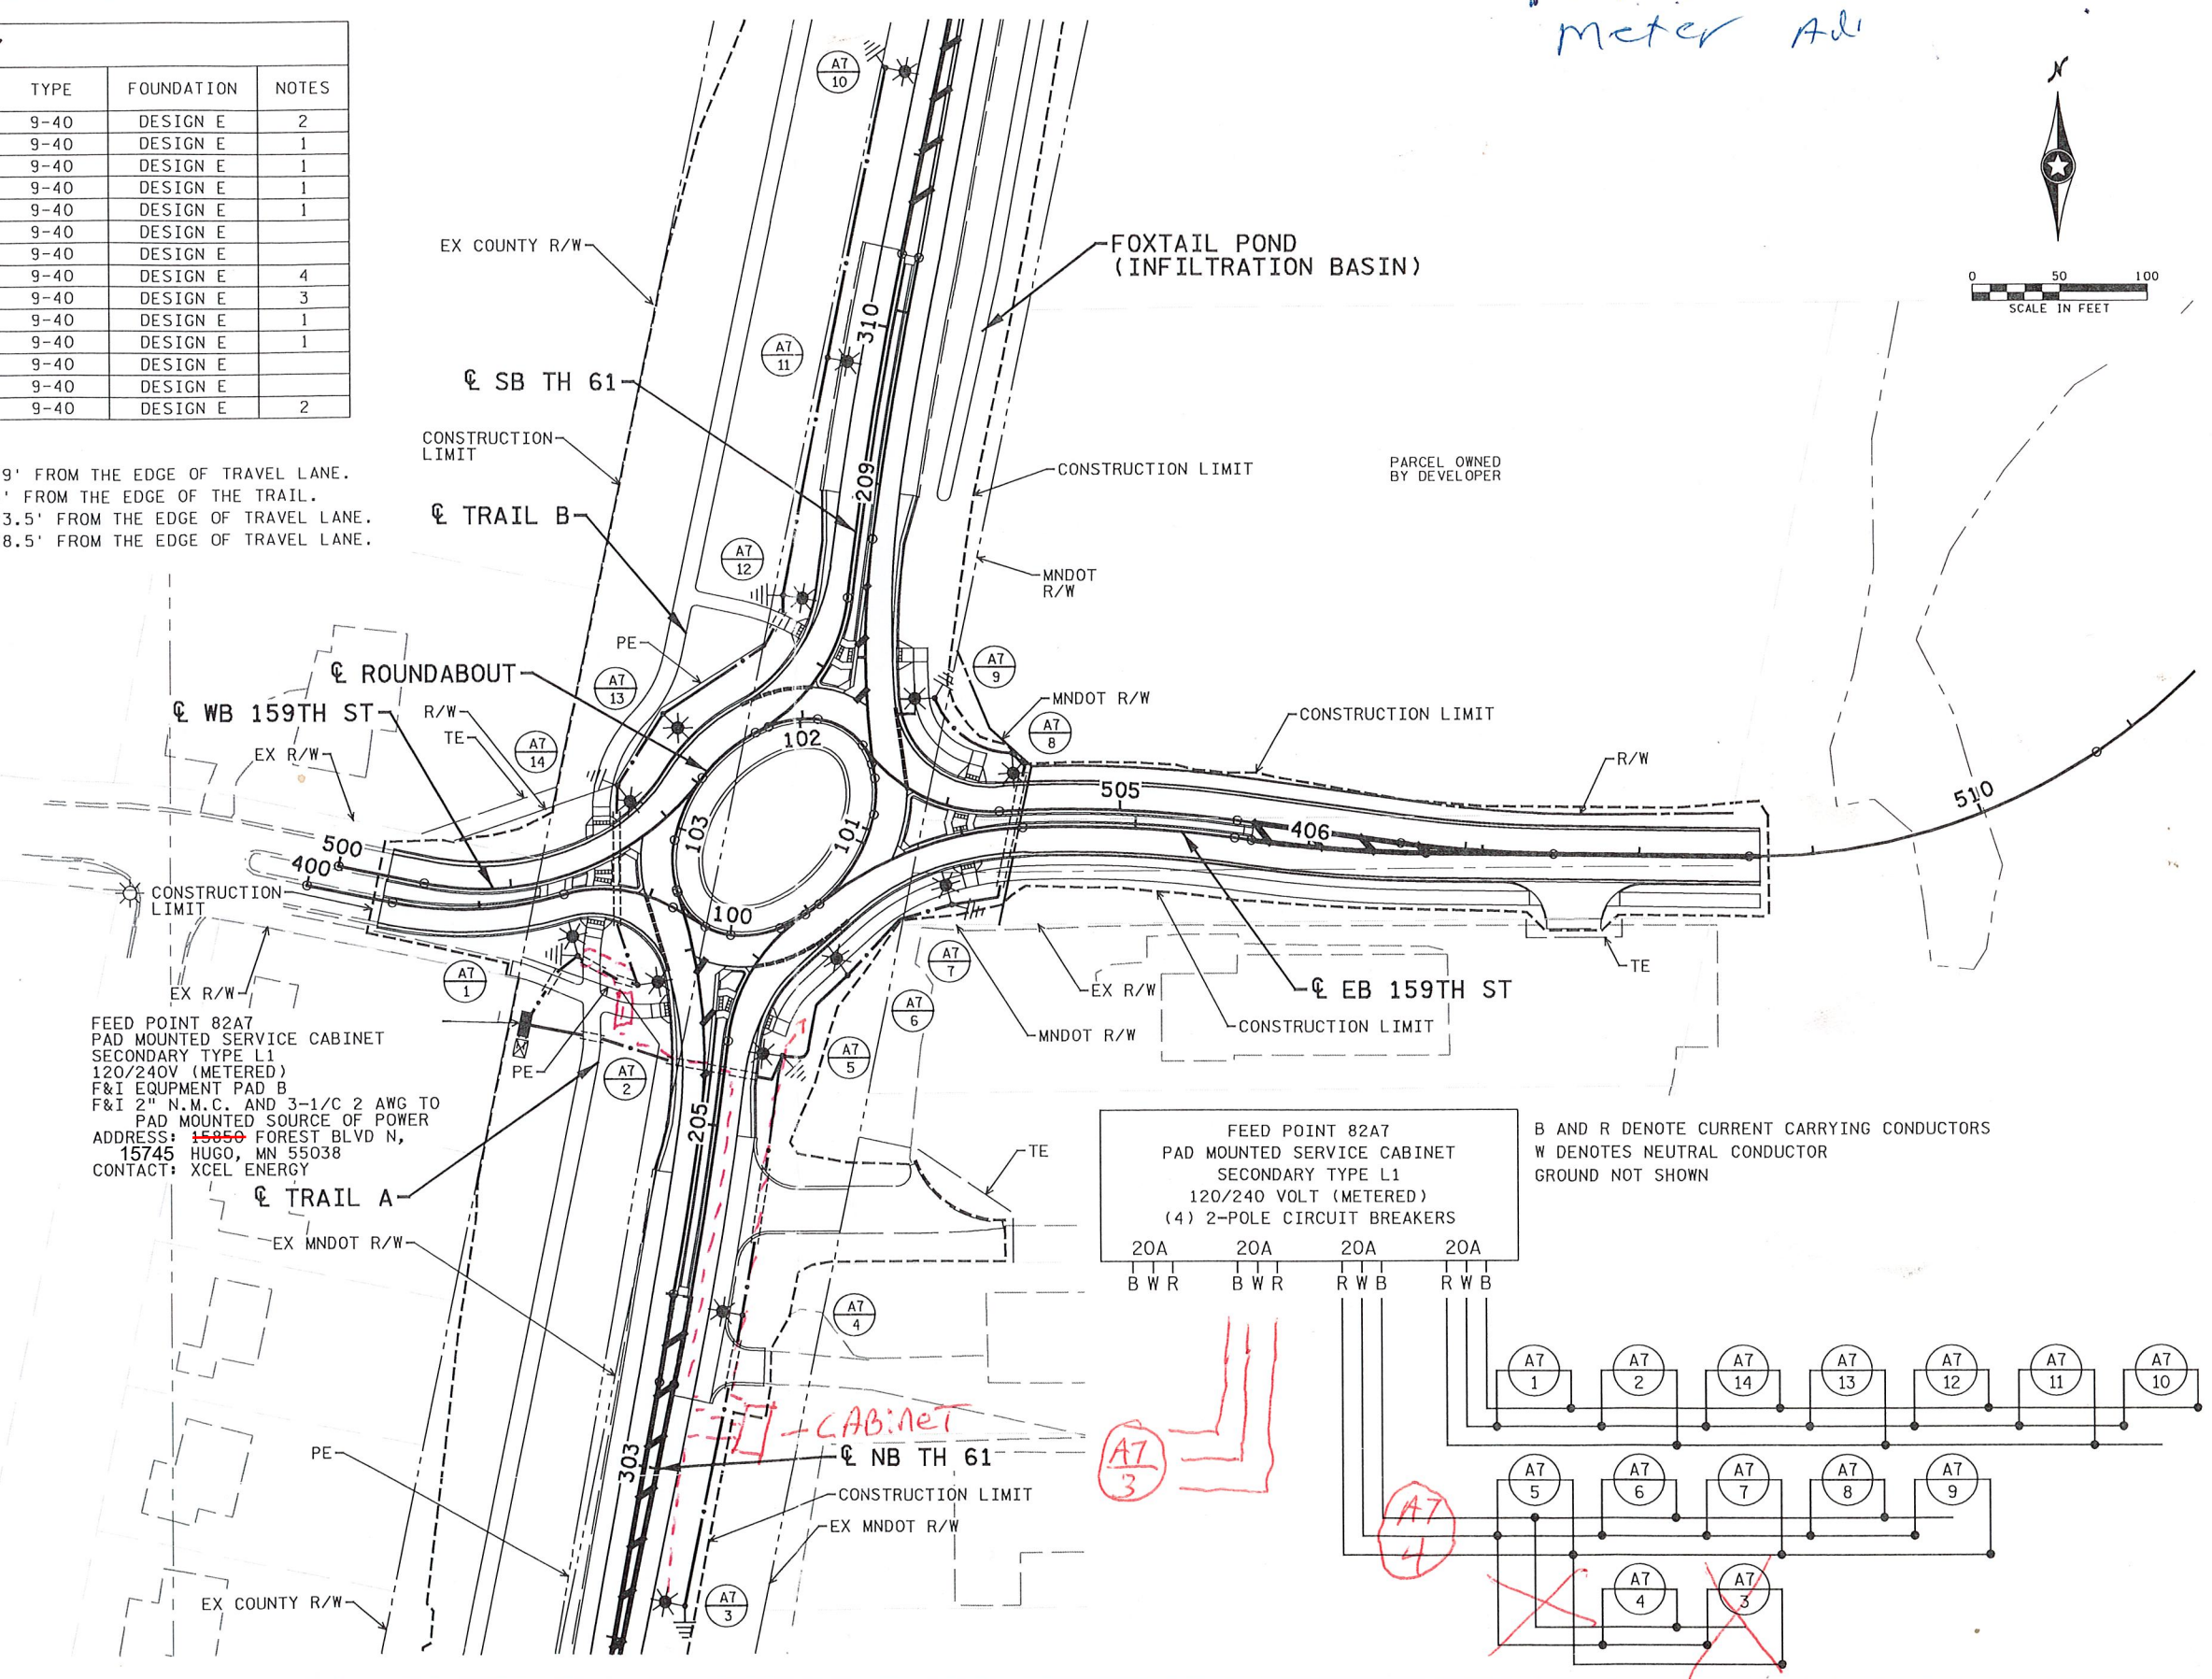


15745 Forest Blvd  
meter Adv

FEED POINT 82A7							
NO.	STATION	L	R	LOCATION	TYPE	FOUNDATION	NOTES
1	401+47		X	EB 159TH ST	9-40	DESIGN E	2
2	305+85	X		SB TH 61	9-40	DESIGN E	1
3	202+26		X	NB TH 61	9-40	DESIGN E	1
4	203+95		X	NB TH 61	9-40	DESIGN E	1
5	205+44		X	NB TH 61	9-40	DESIGN E	1
6	206+38		X	NB TH 61	9-40	DESIGN E	
7	403+82		X	EB 159TH ST	9-40	DESIGN E	
8	504+40	X		WB 159TH ST	9-40	DESIGN E	4
9	207+74		X	NB TH 61	9-40	DESIGN E	3
10	311+46	X		SB TH 61	9-40	DESIGN E	1
11	309+76	X		SB TH 61	9-40	DESIGN E	1
12	308+38	X		SB TH 61	9-40	DESIGN E	
13	307+15	X		SB TH 61	9-40	DESIGN E	
14	501+89	X		WB 159TH ST	9-40	DESIGN E	2


- FEED POINT NOTES:
1. OFFSET THE CENTER OF THE LIGHT FOUNDATION 19' FROM THE EDGE OF TRAVEL LANE.
  2. OFFSET THE CENTER OF THE LIGHT FOUNDATION 3' FROM THE EDGE OF THE TRAIL.
  3. OFFSET THE CENTER OF THE LIGHT FOUNDATION 23.5' FROM THE EDGE OF TRAVEL LANE.
  4. OFFSET THE CENTER OF THE LIGHT FOUNDATION 18.5' FROM THE EDGE OF TRAVEL LANE.

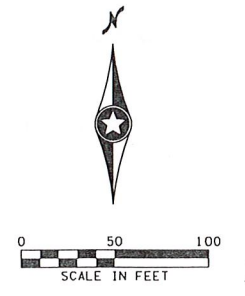

FEED POINT 82A7  
PAD MOUNTED SERVICE CABINET  
SECONDARY TYPE L1  
120/240V (METERED)  
F&I EQUIPMENT PAD B  
F&I 2" N.M.C. AND 3-1/2" C 2 AWG TO  
PAD MOUNTED SOURCE OF POWER  
ADDRESS: 15745 FOREST BLVD N,  
15745 HUGO, MN 55038  
CONTACT: XCEL ENERGY

FEED POINT 82A7  
PAD MOUNTED SERVICE CABINET  
SECONDARY TYPE L1  
120/240 VOLT (METERED)  
(4) 2-POLE CIRCUIT BREAKERS  
20A 20A 20A 20A  
B W R B W R R W B R W B

B AND R DENOTE CURRENT CARRYING CONDUCTORS  
W DENOTES NEUTRAL CONDUCTOR  
GROUND NOT SHOWN

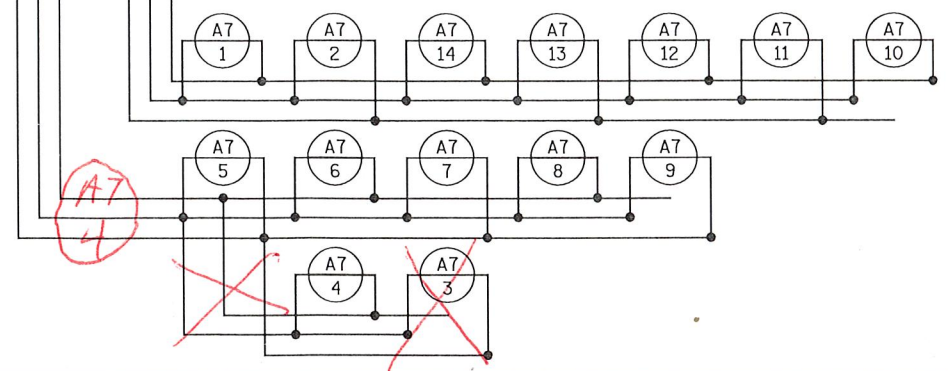

GENERAL NOTES:  
SEE SHEET 117 FOR LEGEND.

8/31/21 AM 6/8/2023 F:\Projects\14000\14824\Drawings\PlanSheets\Final\Plan\14824\_1101.dgn

NO	DATE	BY	CKD	APPR	REVISION

I hereby certify that this plan, specification, or report was prepared by me or under my direct supervision and that I am a duly Licensed Professional Engineer under the laws of the State of Minnesota.  
Print Name: STEVE MCHENRY  
Date: 05/12/2023 License #: 46710

DRAWN BY T. RICHARDSON  
DESIGNED BY T. RICHARDSON  
CHECKED BY S. MCHENRY  
COMM. NO. 02114824



CITY OF HUGO  
LIGHTING PLANS AND DETAILS  
TH 61 & 159TH ST RECONSTRUCTION  
SP 8206-53 (TH 61)

SHEET 119 OF 176