


- LEGEND**
- PAD MOUNTED SOURCE OF POWER
  - 250 WATT HPS LIGHTING UNIT
  - 3" CONDUIT UNLESS OTHERWISE NOTED
  - PERMANENT GROUND ROD (25 OHMS OR LESS)

AS-BUILT 5/2010

T.H. 101 AT C.S.A.H. 36 LIGHTING PLAN

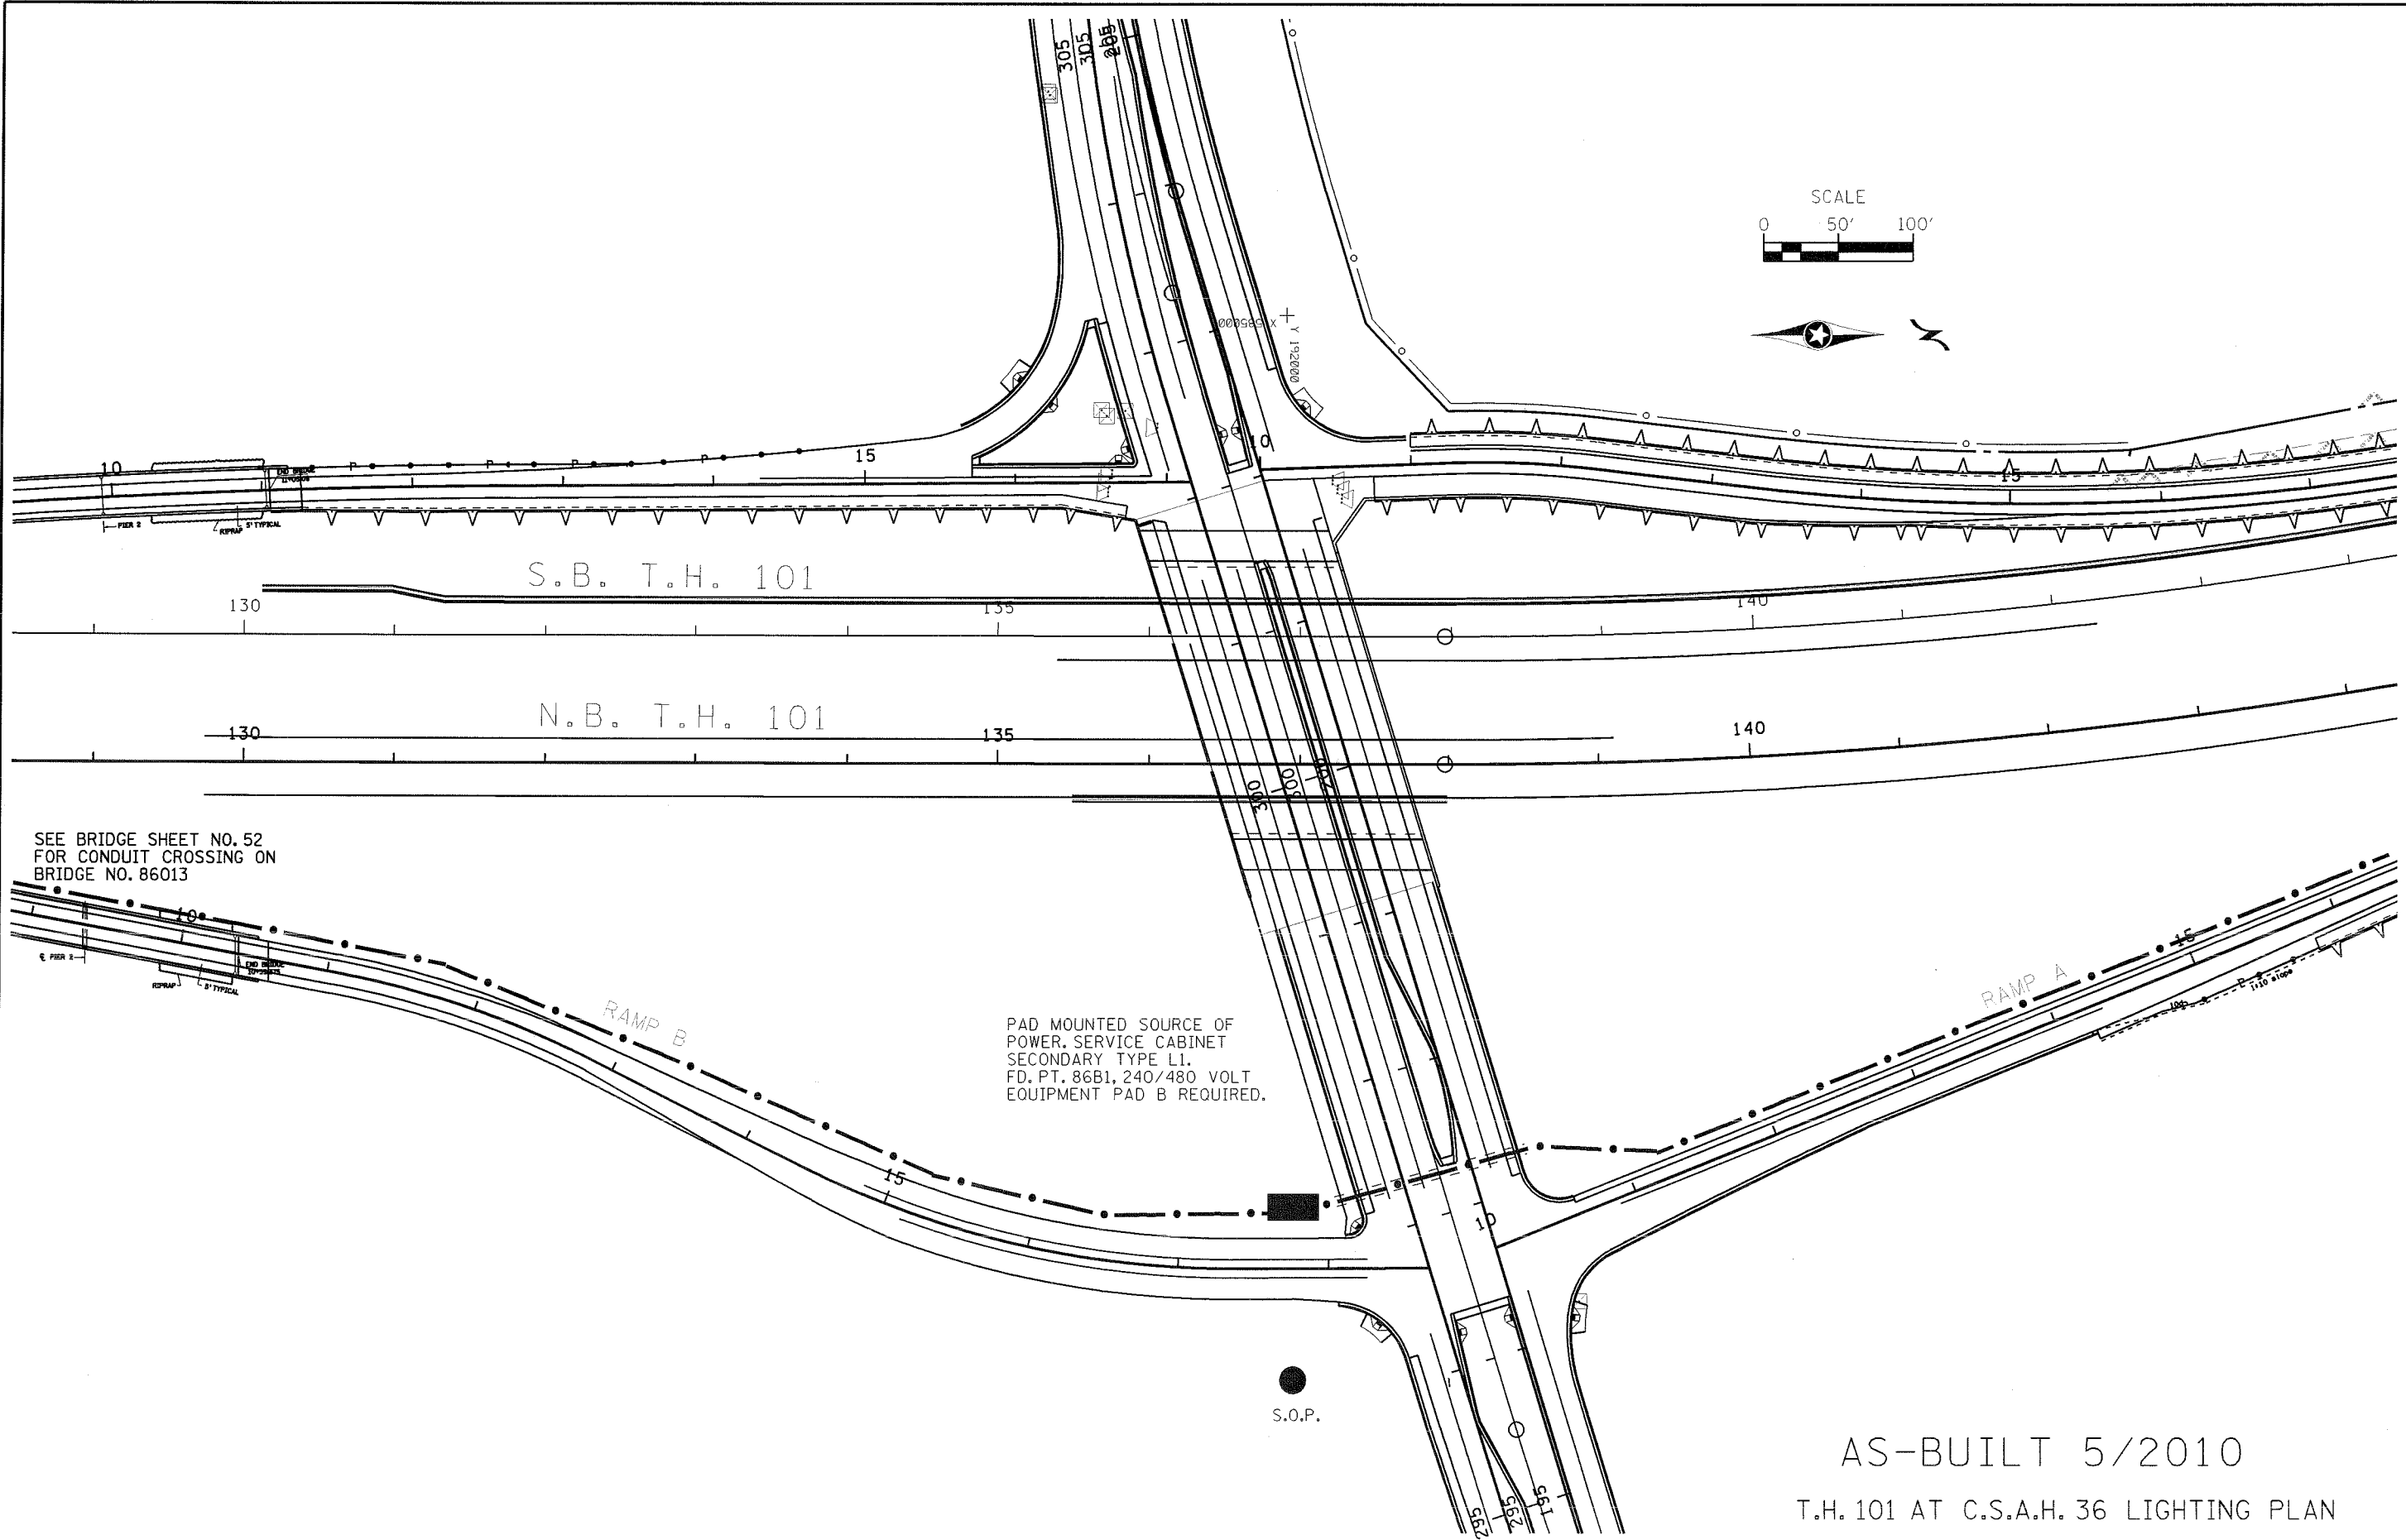


SEE BRIDGE SHEET NO. 52  
FOR CONDUIT CROSSING ON  
BRIDGE NO. 86013

PAD MOUNTED SOURCE OF  
POWER, SERVICE CABINET  
SECONDARY TYPE L1.  
FD. PT. 86B1, 240/480 VOLT  
EQUIPMENT PAD B REQUIRED.

AS-BUILT 5/2010  
T.H. 101 AT C.S.A.H. 36 LIGHTING PLAN

CERTIFIED BY \_\_\_\_\_ LIC. NO. 13296  
LICENSED PROFESSIONAL ENGINEER

FILE NAME: \*\*\*\*\*FILENAME\*\*\*\*\*  
STATE PROJ. NO. 8608-21 (T.H. 101) SHEET NO. 619 OF 741 SHEETS

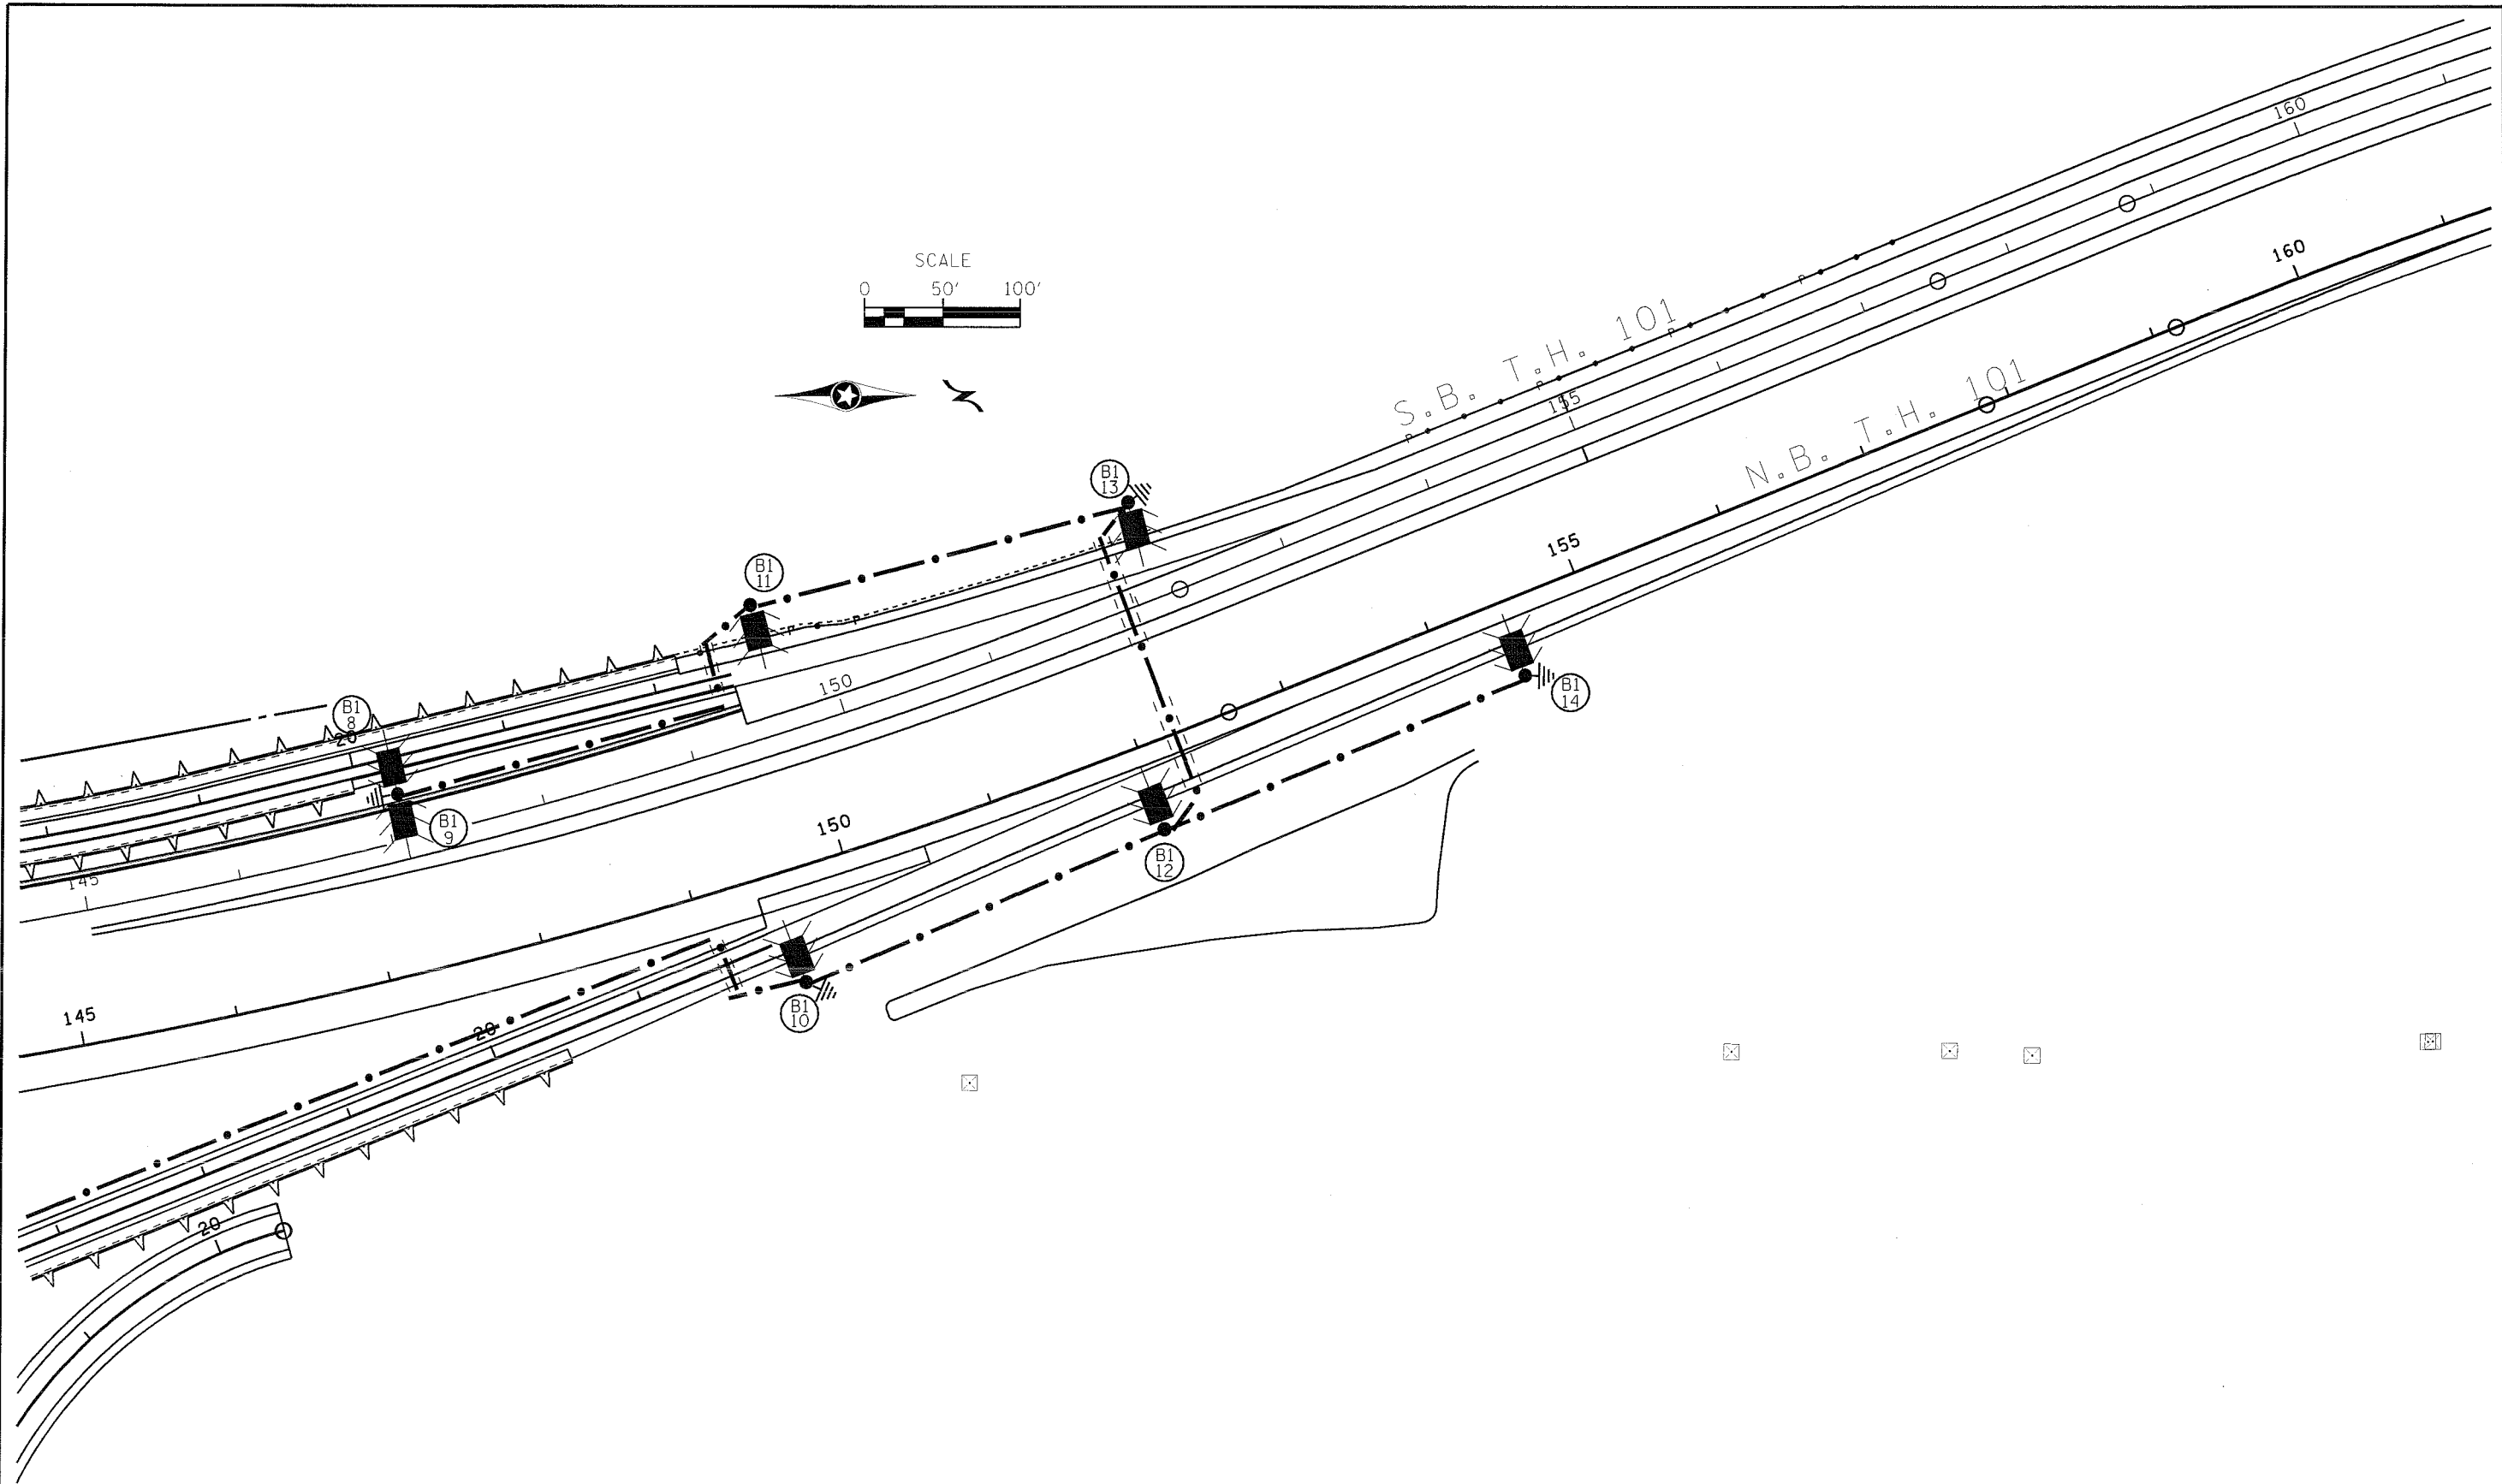

AS-BUILT 5/2010  
 T.H. 101 AT C.S.A.H. 36 LIGHTING PLAN

CERTIFIED BY \_\_\_\_\_ LIC. NO. 13296  
LICENSED PROFESSIONAL ENGINEER

FILE NAME: \*\*\*\*\*FILENAME\*\*\*\*\*

\*\*\*\*DATE\*\*\*

STATE PROJ. NO. 8608-21 (T.H. 101)

SHEET NO. 620 OF 741 SHEETS