


B AND R DENOTE CURRENT CARRYING CONDUCTORS
W DENOTES NEUTRAL CONDUCTOR

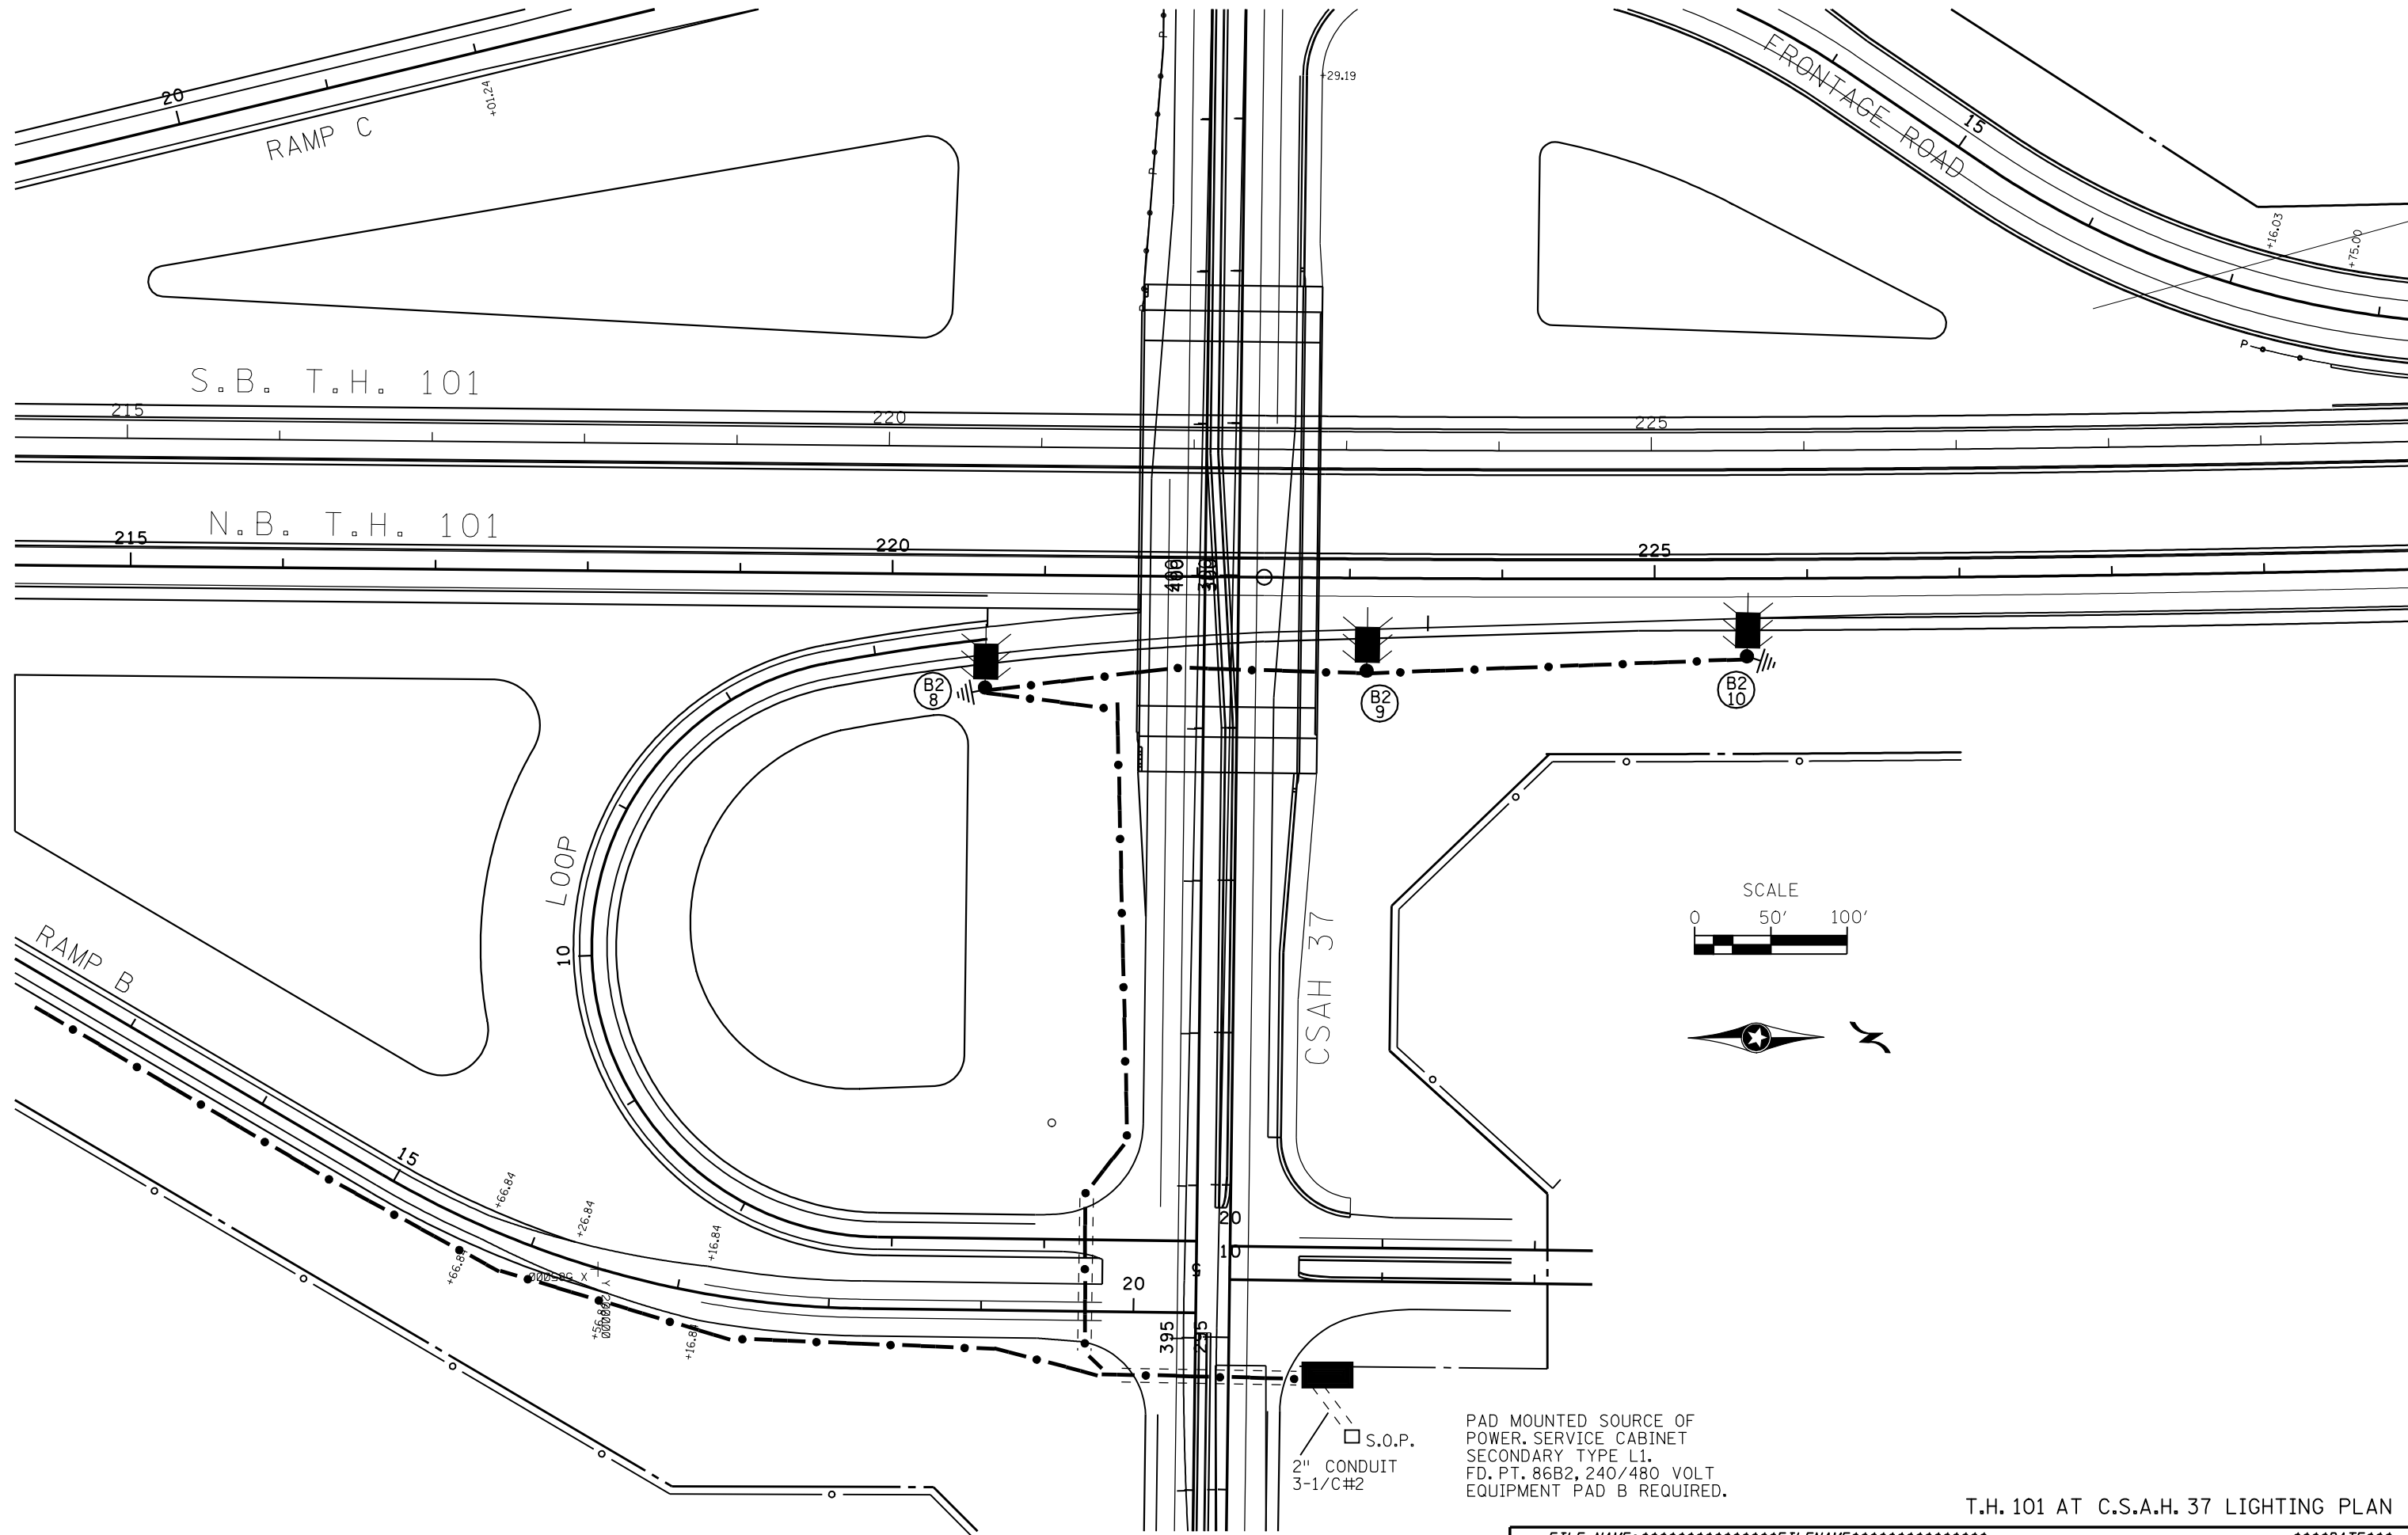

S.B. T.H. 101

N.B. T.H. 101


FRONTAGE ROAD

10 LOOP

RAMP B

RAMP C

CSAH 37

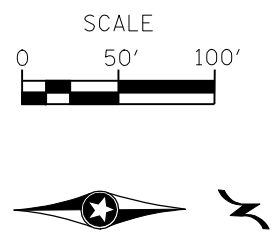

□ S.O.P.
2" CONDUIT
3-1/C#2

PAD MOUNTED SOURCE OF
POWER. SERVICE CABINET
SECONDARY TYPE L1.
FD. PT. 86B2, 240/480 VOLT
EQUIPMENT PAD B REQUIRED.

T.H. 101 AT C.S.A.H. 37 LIGHTING PLAN

CERTIFIED BY _____ LIC.NO. 13296
LICENSED PROFESSIONAL ENGINEER

FILE NAME: \$\$\$\$\$\$\$\$\$\$\$\$\$\$FILENAME\$\$\$\$\$\$\$\$\$\$\$\$\$\$\$\$\$
STATE PROJ. NO. 8608-21 (T.H. 101) SHEET NO. 622 OF 741 SHEETS
\$\$\$\$\$DATE\$\$\$