



SEE LEGEND SHEET 202

FEEDPOINT A3X


PLOTTED/REVISED: 12/1/2009

LIGHTING STANDARDS AND BASES						
NO.	STA.	ALI	LT.	RT.	LOCATION	WATTAGE
1	193+80	MED TH94			TH94EB	250
2	194+45				L	250
3	196+20				9-49	400
4	198+90					
5	201+75					
6	204+25					
7	206+75					
8	209+25					
9	211+80					
10	214+30					
11	216+80					
12	219+40					
13	221+70					
14	224+40					
15	227+10					
16	229+80				TH94EB	
17	229+80				TH94WB	
18	227+10					
19	224+40					
20	221+70					
21	219+40					
22	216+80					
23	214+30					
24	211+80					
25	209+05					
26	206+35					
27	203+65					
28	200+95					
29	198+25					
30	195+55				9-49	400
31	194+45				L	250
32	193+85	MED TH94			TH94WB	L
33	INPLACE	AS SHOWN			SE RAMP	6-40
34	INPLACE	AS SHOWN			SE RAMP	6-40
35	INPLACE	AS SHOWN			NW RAMP	6-40

① RENUMBER INPLACE POLES - F&I 250 WHPS LUMINAIRE

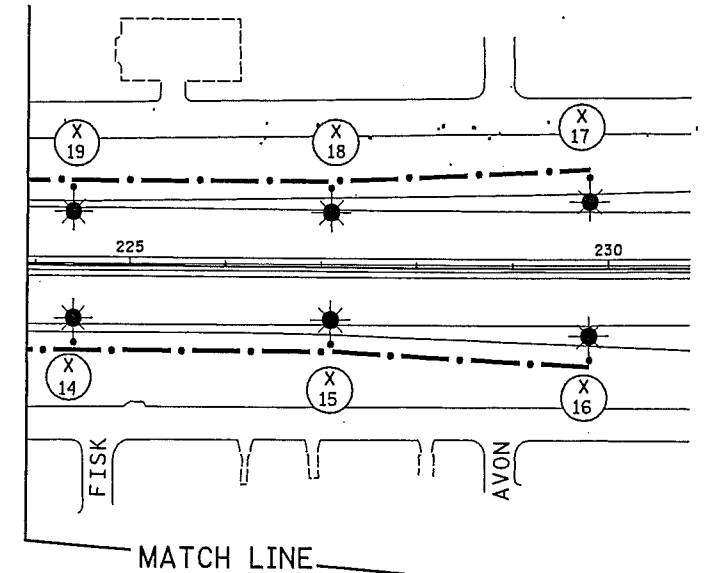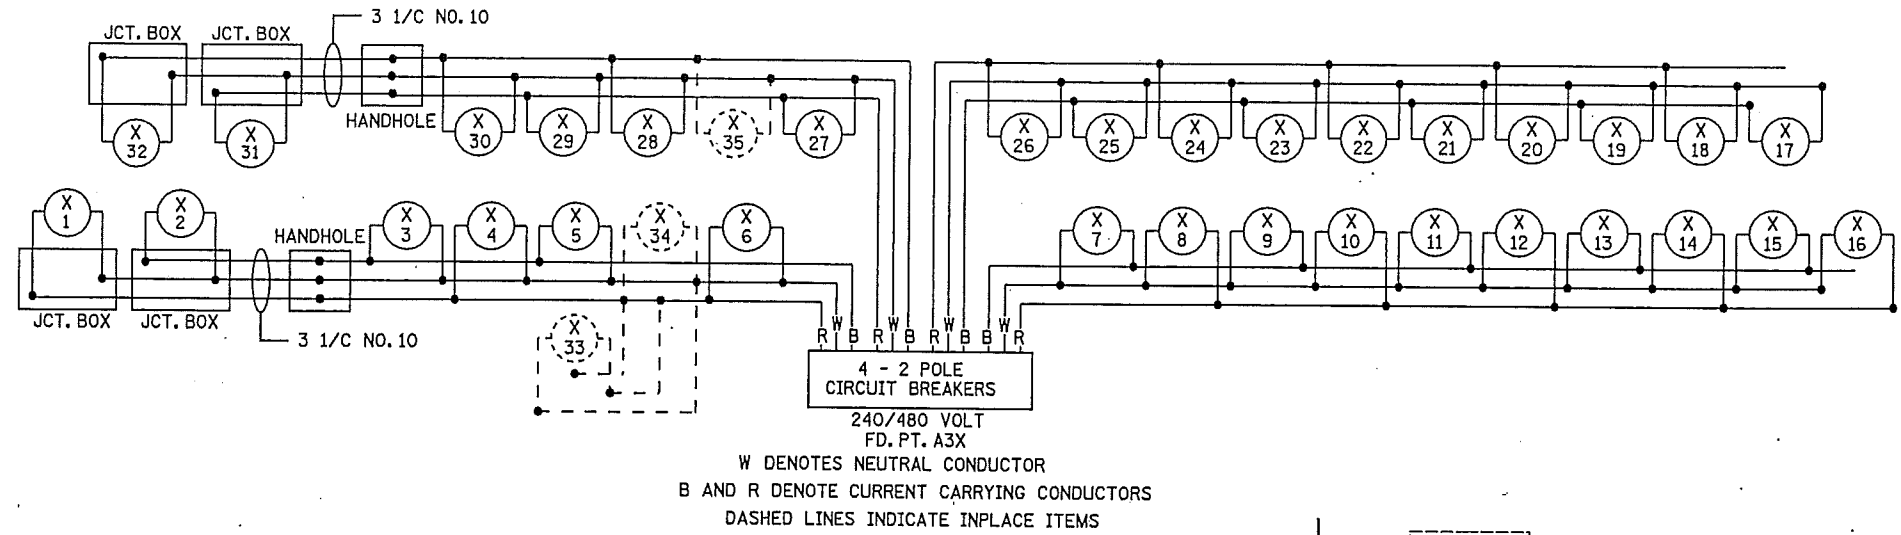

DISTRICT #: METRO  
I/PLOT NAME: 6282187\_10-x  
PATH & FILENAME: IP\_PWP-d\136803\6282187\_10\11.dgn

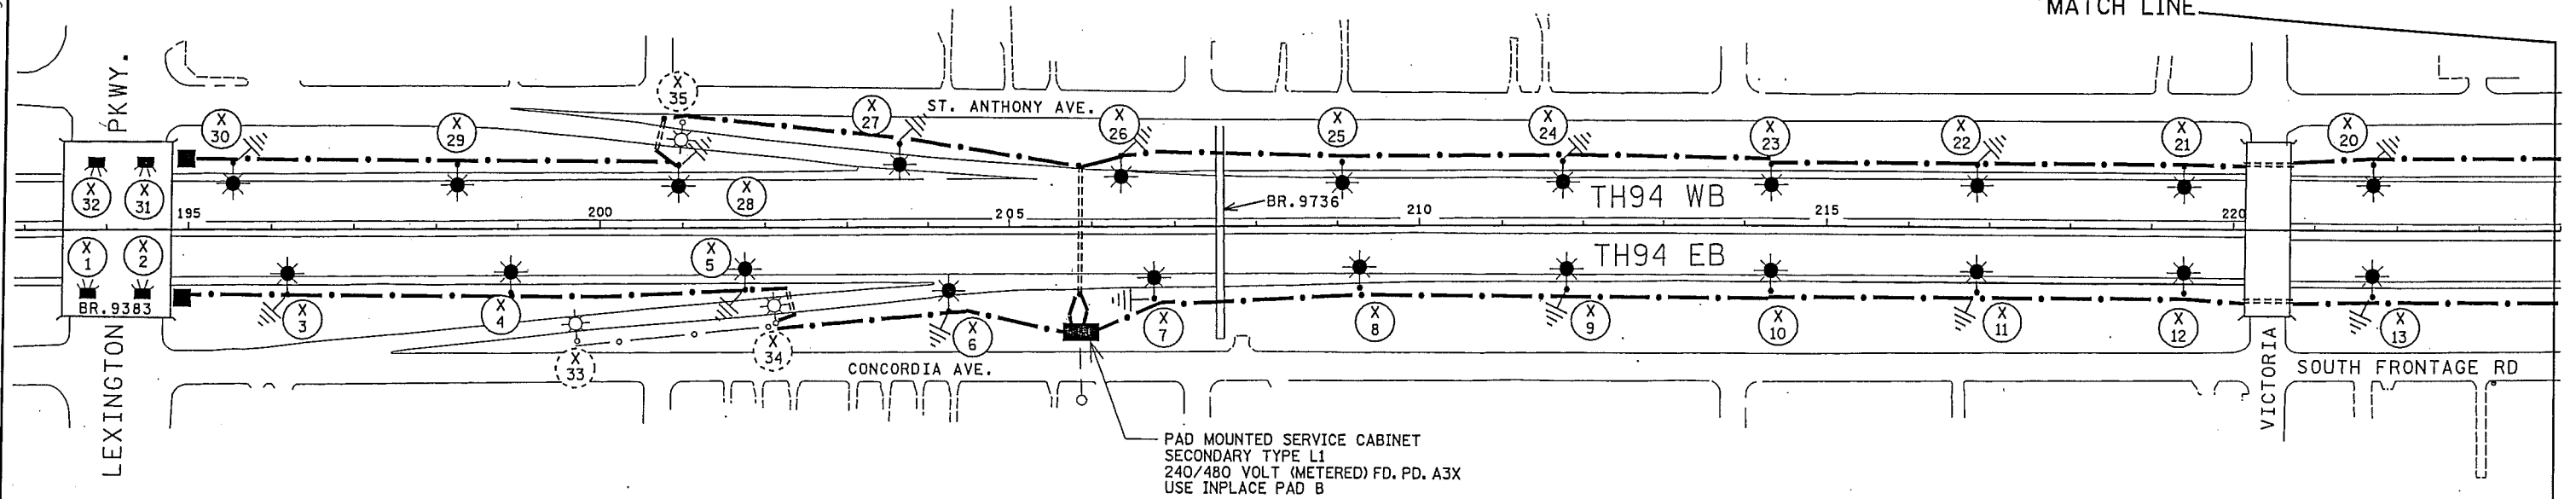

FEEDPOINT A3X

BY	DATE	REVISIONS	SYSTEM ID: FEEDPOINT: A3X	T.E.	LOCATION: TH94 at CONCORDIA AVE.	<b>LIGHTING PLAN</b>
			METER ADDRESS: 992 CONCORDIA AVE. St. PAUL 55104			
DRAWN BY: NS CKD BY: GB DATE:			CERTIFIED BY: <i>Michael P. Sulvenby</i> LIC. NO. 19863 DATE: 12/1/2009		STATE PROJ. NO. 6282-187 (T.H.94)	SHEET NO. 206 OF 294 SHEETS