
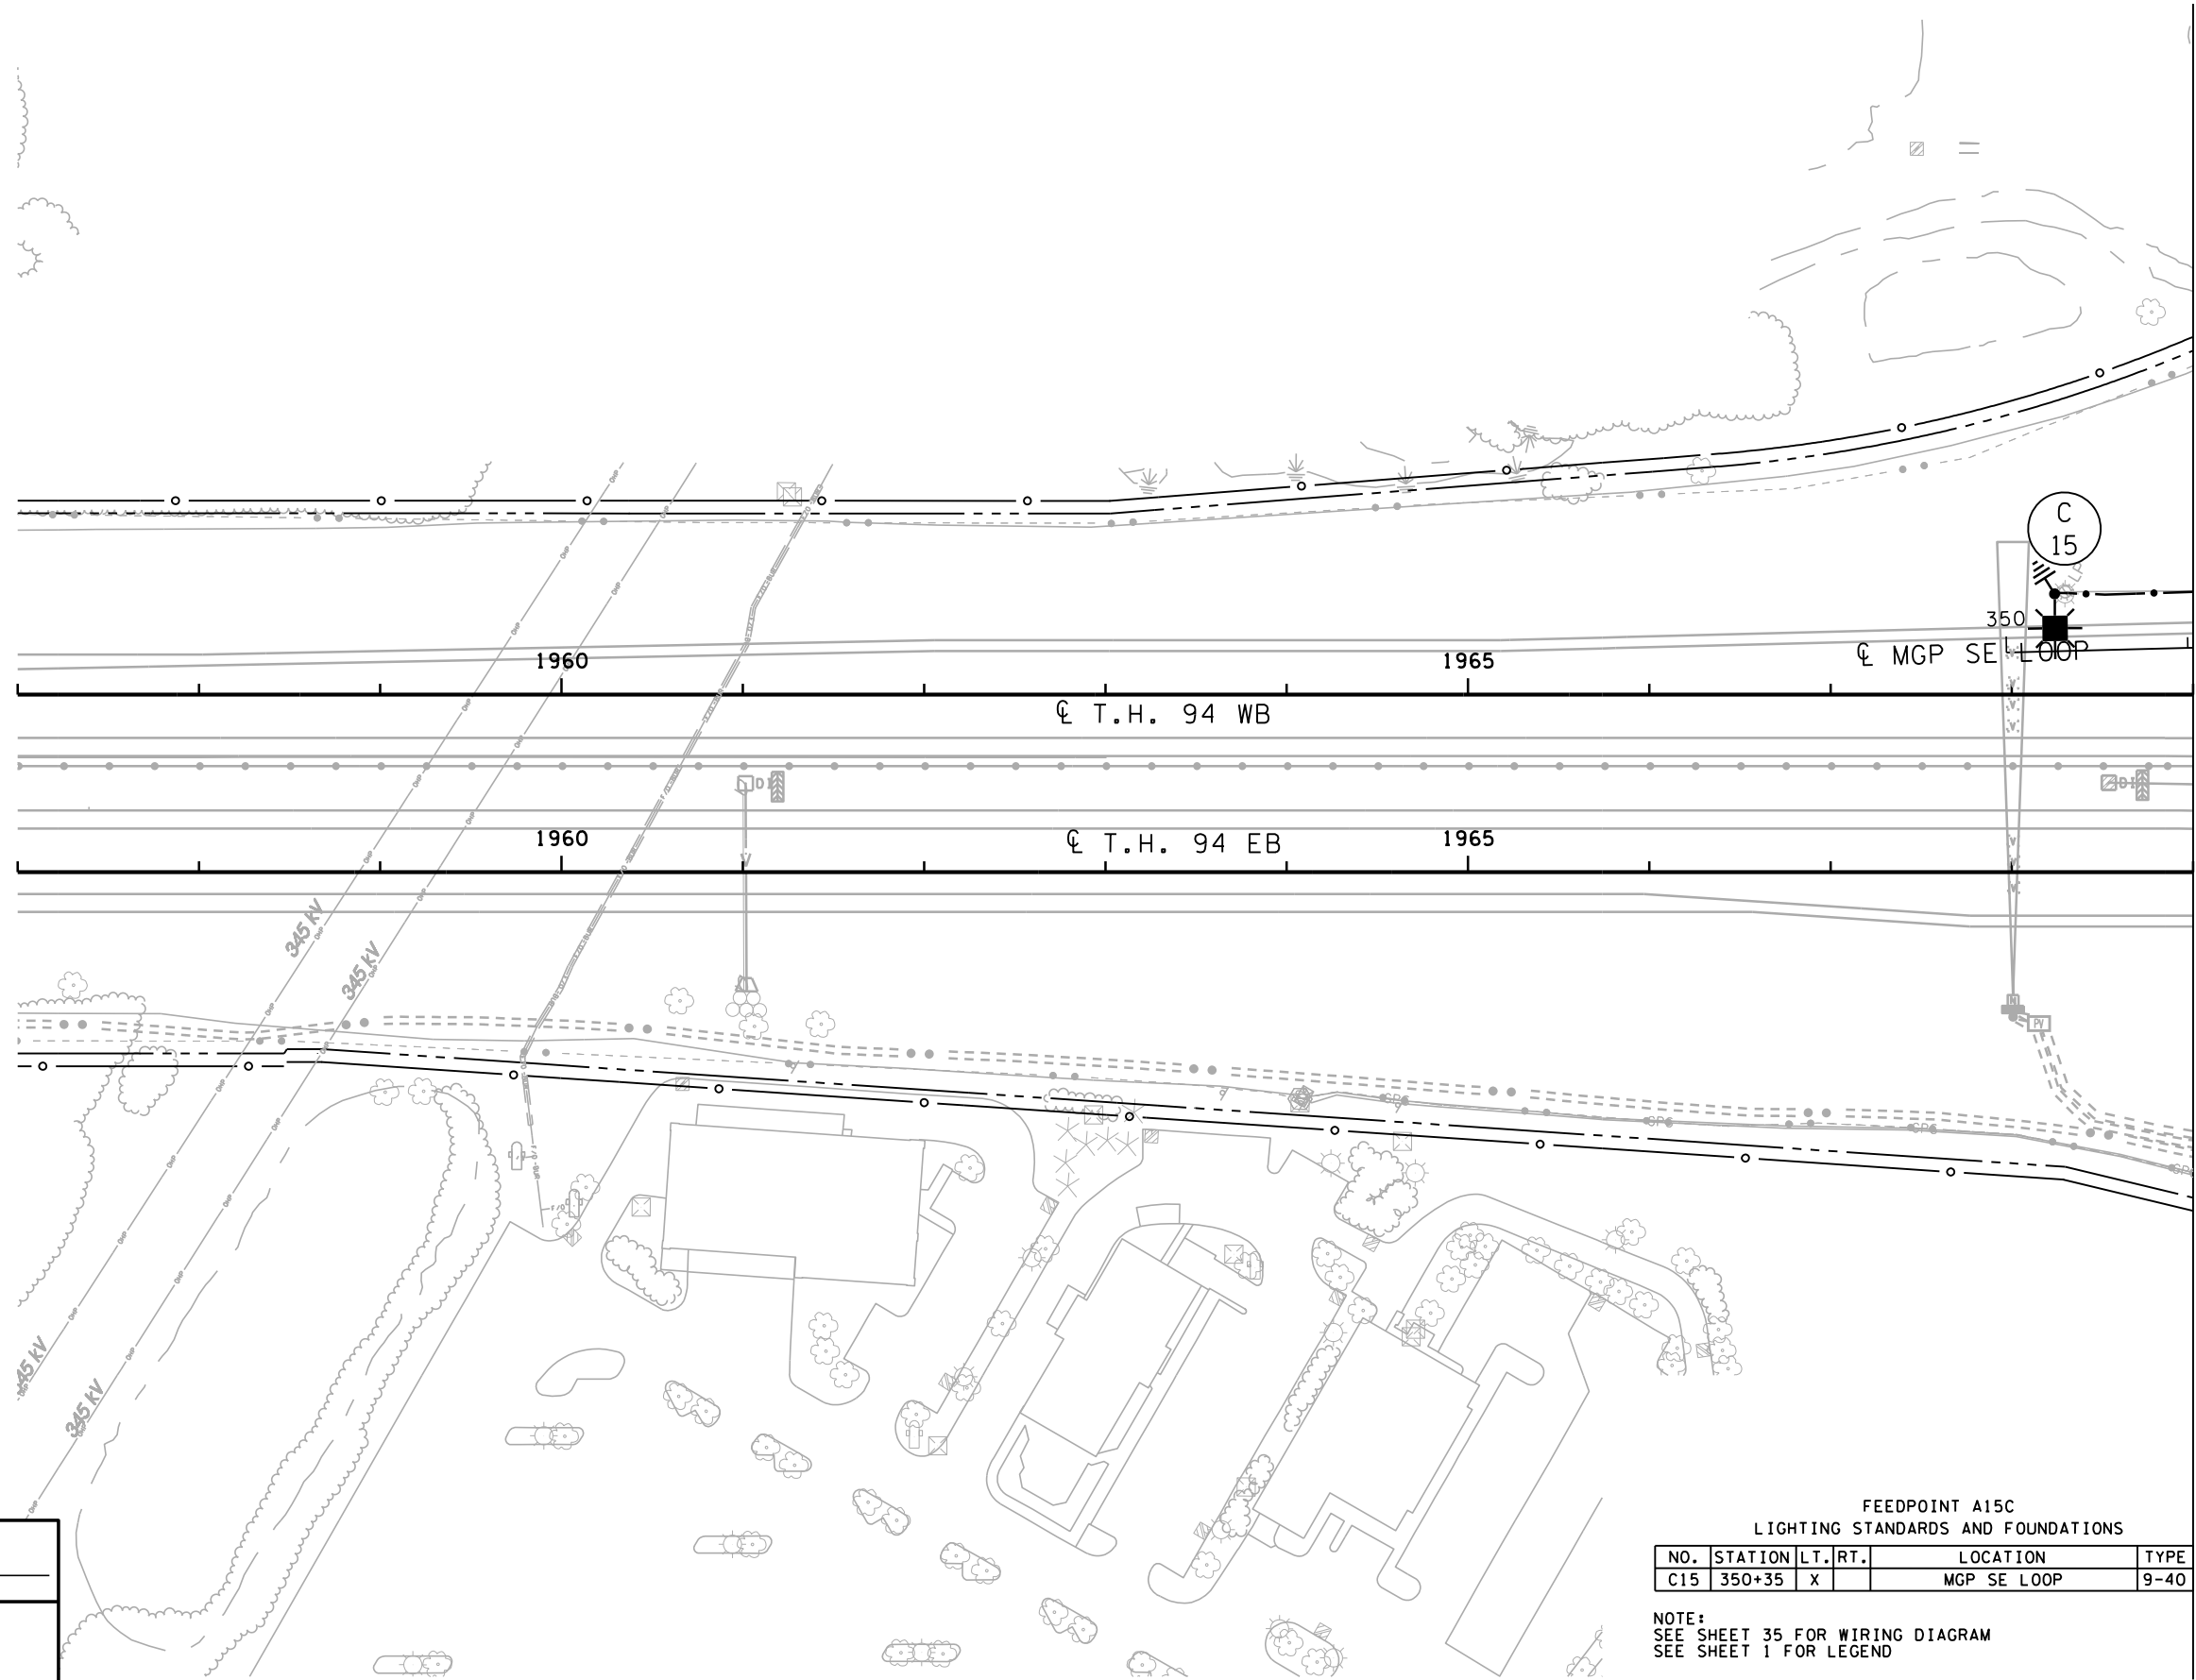


PLOTTED/REVISED: 23-NOV-2022

PATH & FILENAME: Minneapolis\_MN\01\_Projects\176174\_194\_MPLGR\_DB\4) DGN\_Sheets\Illumination\C0278097\_1126.dgn

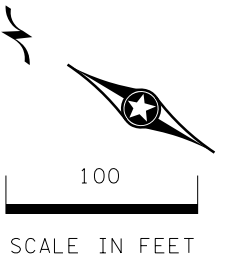

MATCH LINE STA 1969+00

FEEDPOINT A15C  
LIGHTING STANDARDS AND FOUNDATIONS

NO.	STATION	LT.	RT.	LOCATION	TYPE
C15	350+35	X		MGP SE LOOP	9-40

NOTE:  
SEE SHEET 35 FOR WIRING DIAGRAM  
SEE SHEET 1 FOR LEGEND


NO	DATE	DWN	CKD	REVISIONS

**C.S. McCrossan** **Michael Baker**  
INTERNATIONAL

I HEREBY CERTIFY THAT THIS SHEET WAS PREPARED BY ME OR UNDER MY DIRECT SUPERVISION AND THAT I AM A DULY LICENSED PROFESSIONAL ENGINEER UNDER THE LAWS OF THE STATE OF MINNESOTA.



PRINT NAME: STEVEN STUART, PE  
SIGNATURE: \_\_\_\_\_  
DATE 12-24-2021 LICENSE #57479

LIGHTING PLANS  
STA 1957+00 TO STA 1969+00

I-94 MAPLE GROVE TO ROGERS DB (S.P. 2780-97)  
SHEET NO. SL32 OF SL61 SHEETS

PLOTTED/REVISED: 23-NOV-2022

PATH & FILENAME: Minneapolis\_MN\01\_Projects\176174\_194\_MPLGR\_DB\4) DGN\_Sheets\illumination\C0278097\_1127.dgn

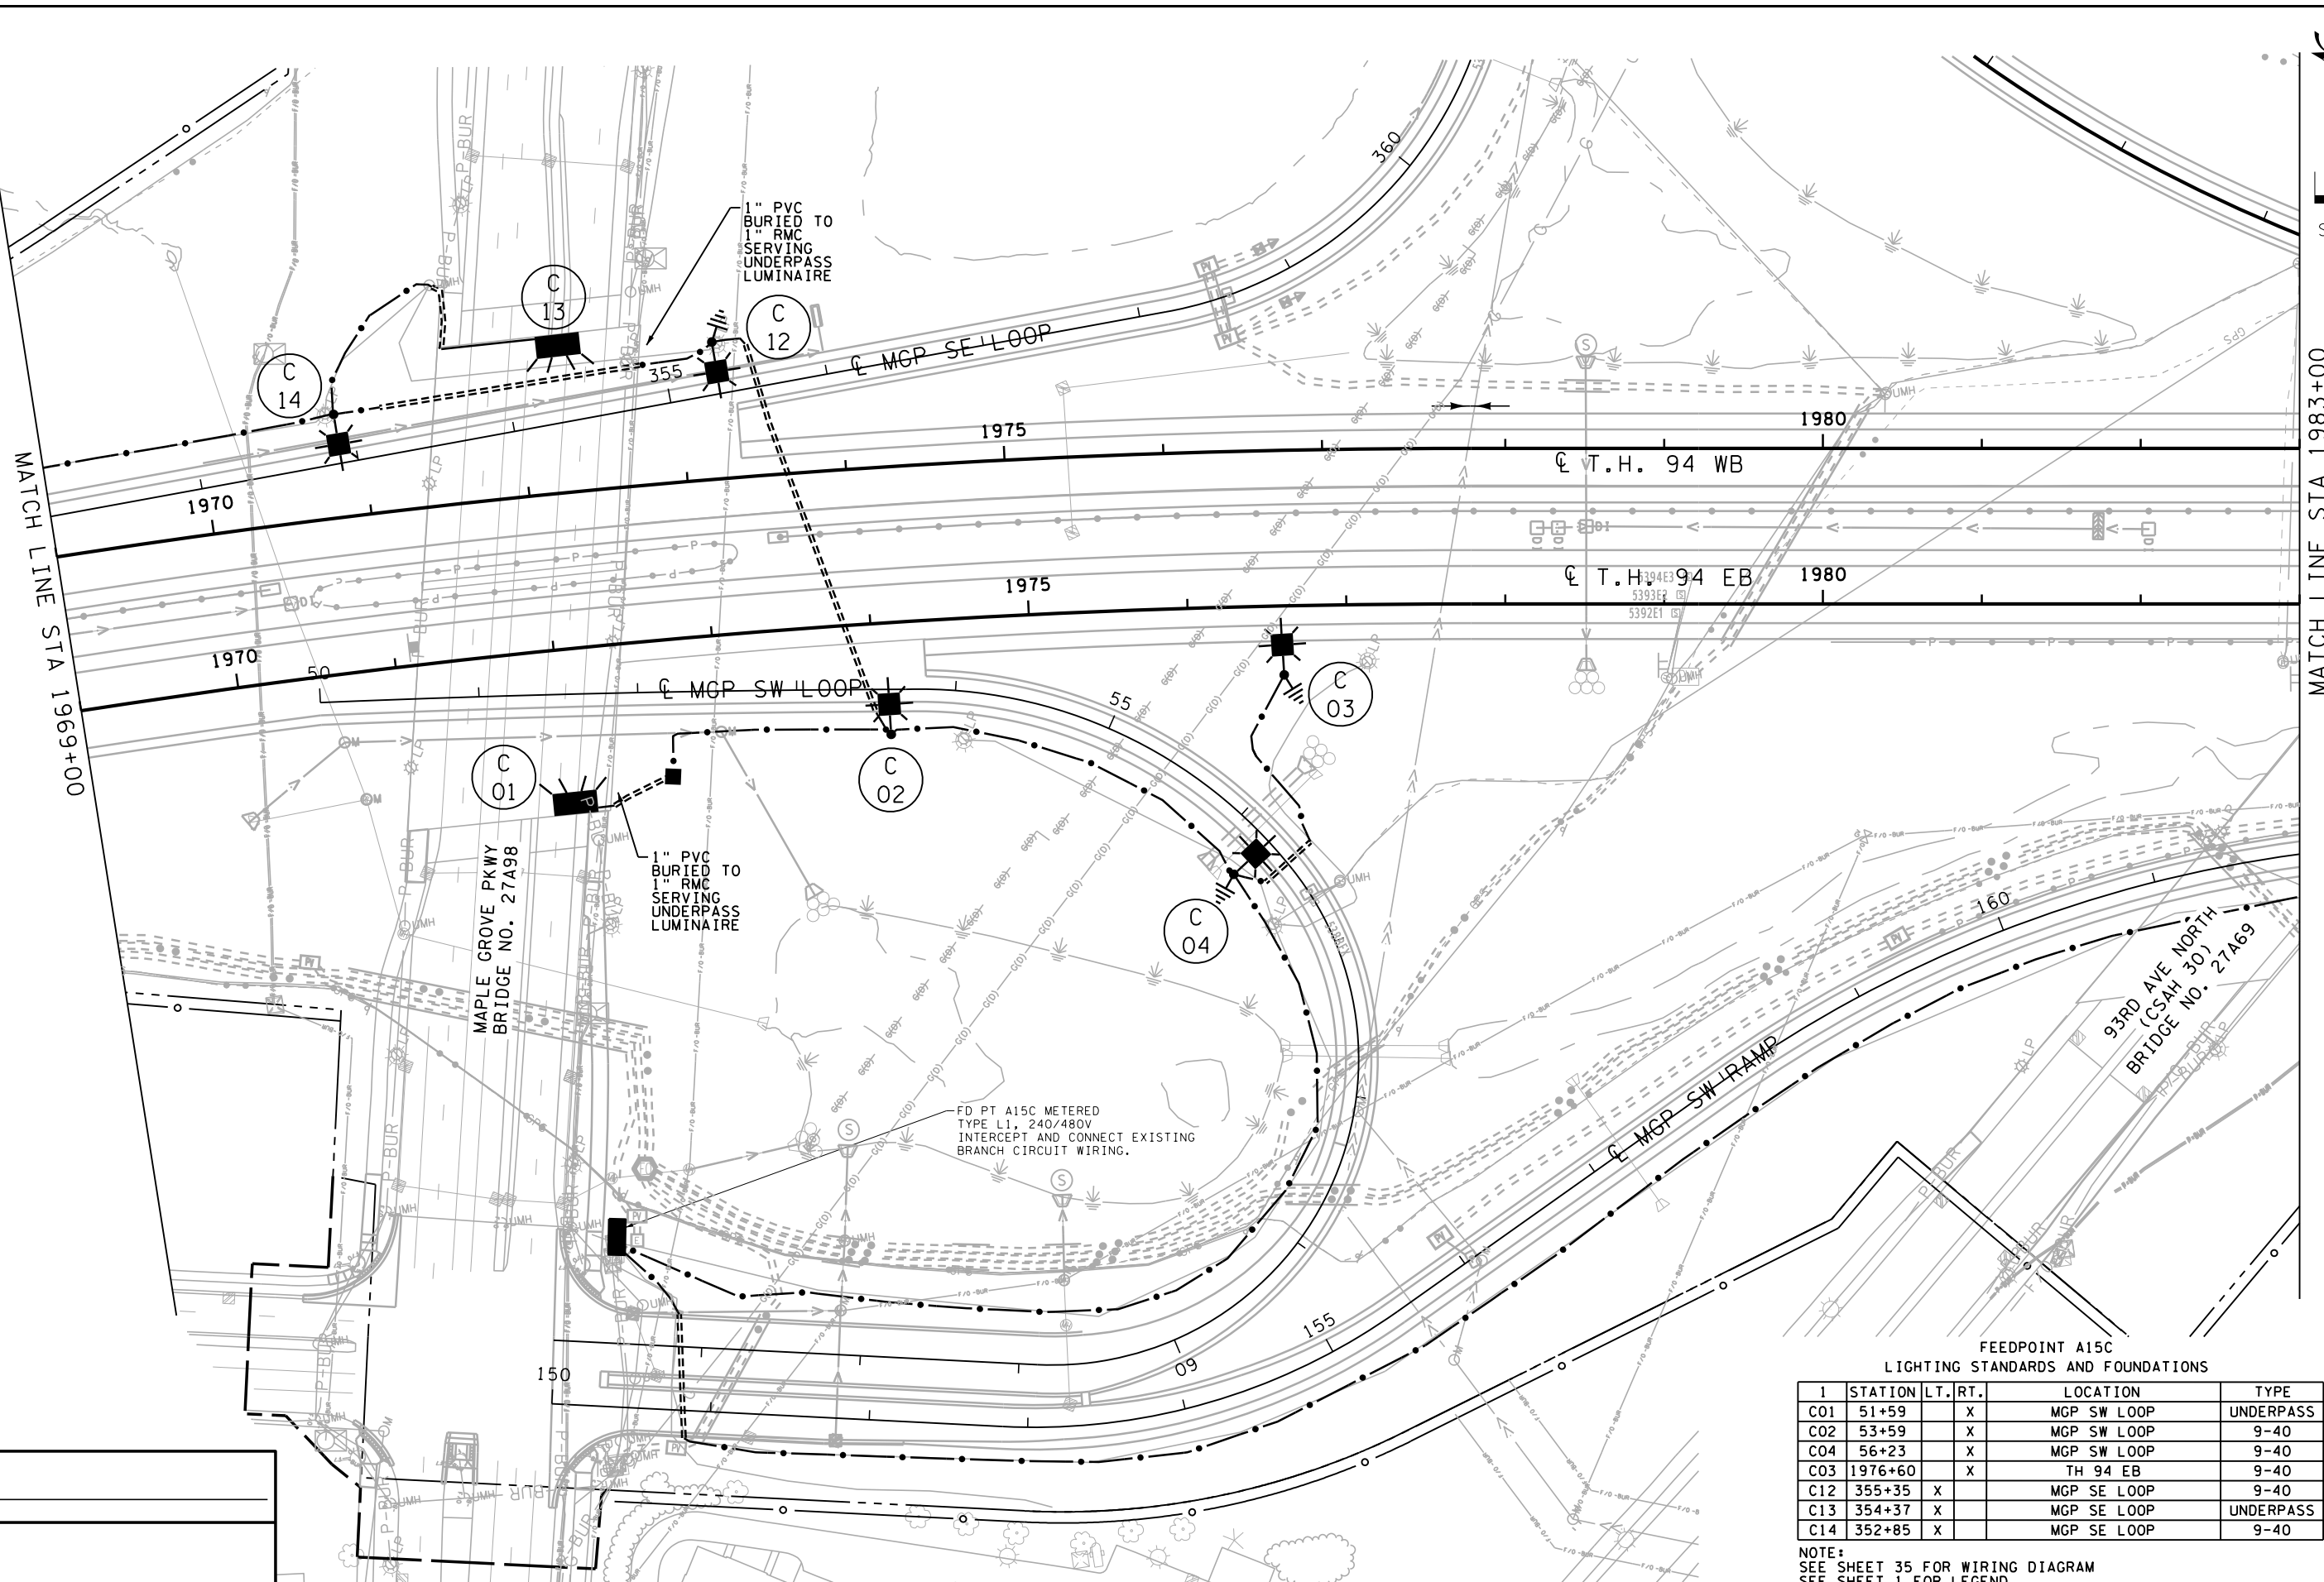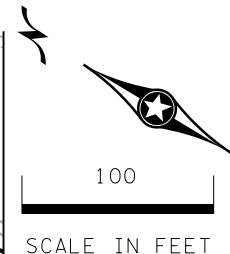

FEEDPOINT A15C  
LIGHTING STANDARDS AND FOUNDATIONS

I	STATION	LT.	RT.	LOCATION	TYPE
C01	51+59		X	MGP SW LOOP	UNDERPASS
C02	53+59		X	MGP SW LOOP	9-40
C04	56+23		X	MGP SW LOOP	9-40
C03	1976+60		X	TH 94 EB	9-40
C12	355+35	X		MGP SE LOOP	9-40
C13	354+37	X		MGP SE LOOP	UNDERPASS
C14	352+85	X		MGP SE LOOP	9-40

NOTE:  
SEE SHEET 35 FOR WIRING DIAGRAM  
SEE SHEET 1 FOR LEGEND

NO	DATE	DWN	CKD	REVISIONS

**C.S. McCrossan** **Michael Baker**  
INTERNATIONAL

I HEREBY CERTIFY THAT THIS SHEET WAS PREPARED BY ME OR UNDER MY DIRECT SUPERVISION AND THAT I AM A DULY LICENSED PROFESSIONAL ENGINEER UNDER THE LAWS OF THE STATE OF MINNESOTA.



PRINT NAME: STEVEN STUART, PE  
SIGNATURE: \_\_\_\_\_  
DATE 12-24-2021 LICENSE #57479

LIGHTING PLANS  
STA 1969+00 TO STA 1883+00

I-94 MAPLE GROVE TO ROGERS DB (S.P. 2780-97)  
SHEET NO. SL33 OF SL61 SHEETS

PLOTTED/REVISED: 23-NOV-2022

PATH & FILENAME: Minneapolis\_MN\01\_Projects\176174\_194\_MPLGR\_DB\4) DGN\_Sheets\illumination\C0278097\_IL30.dgn

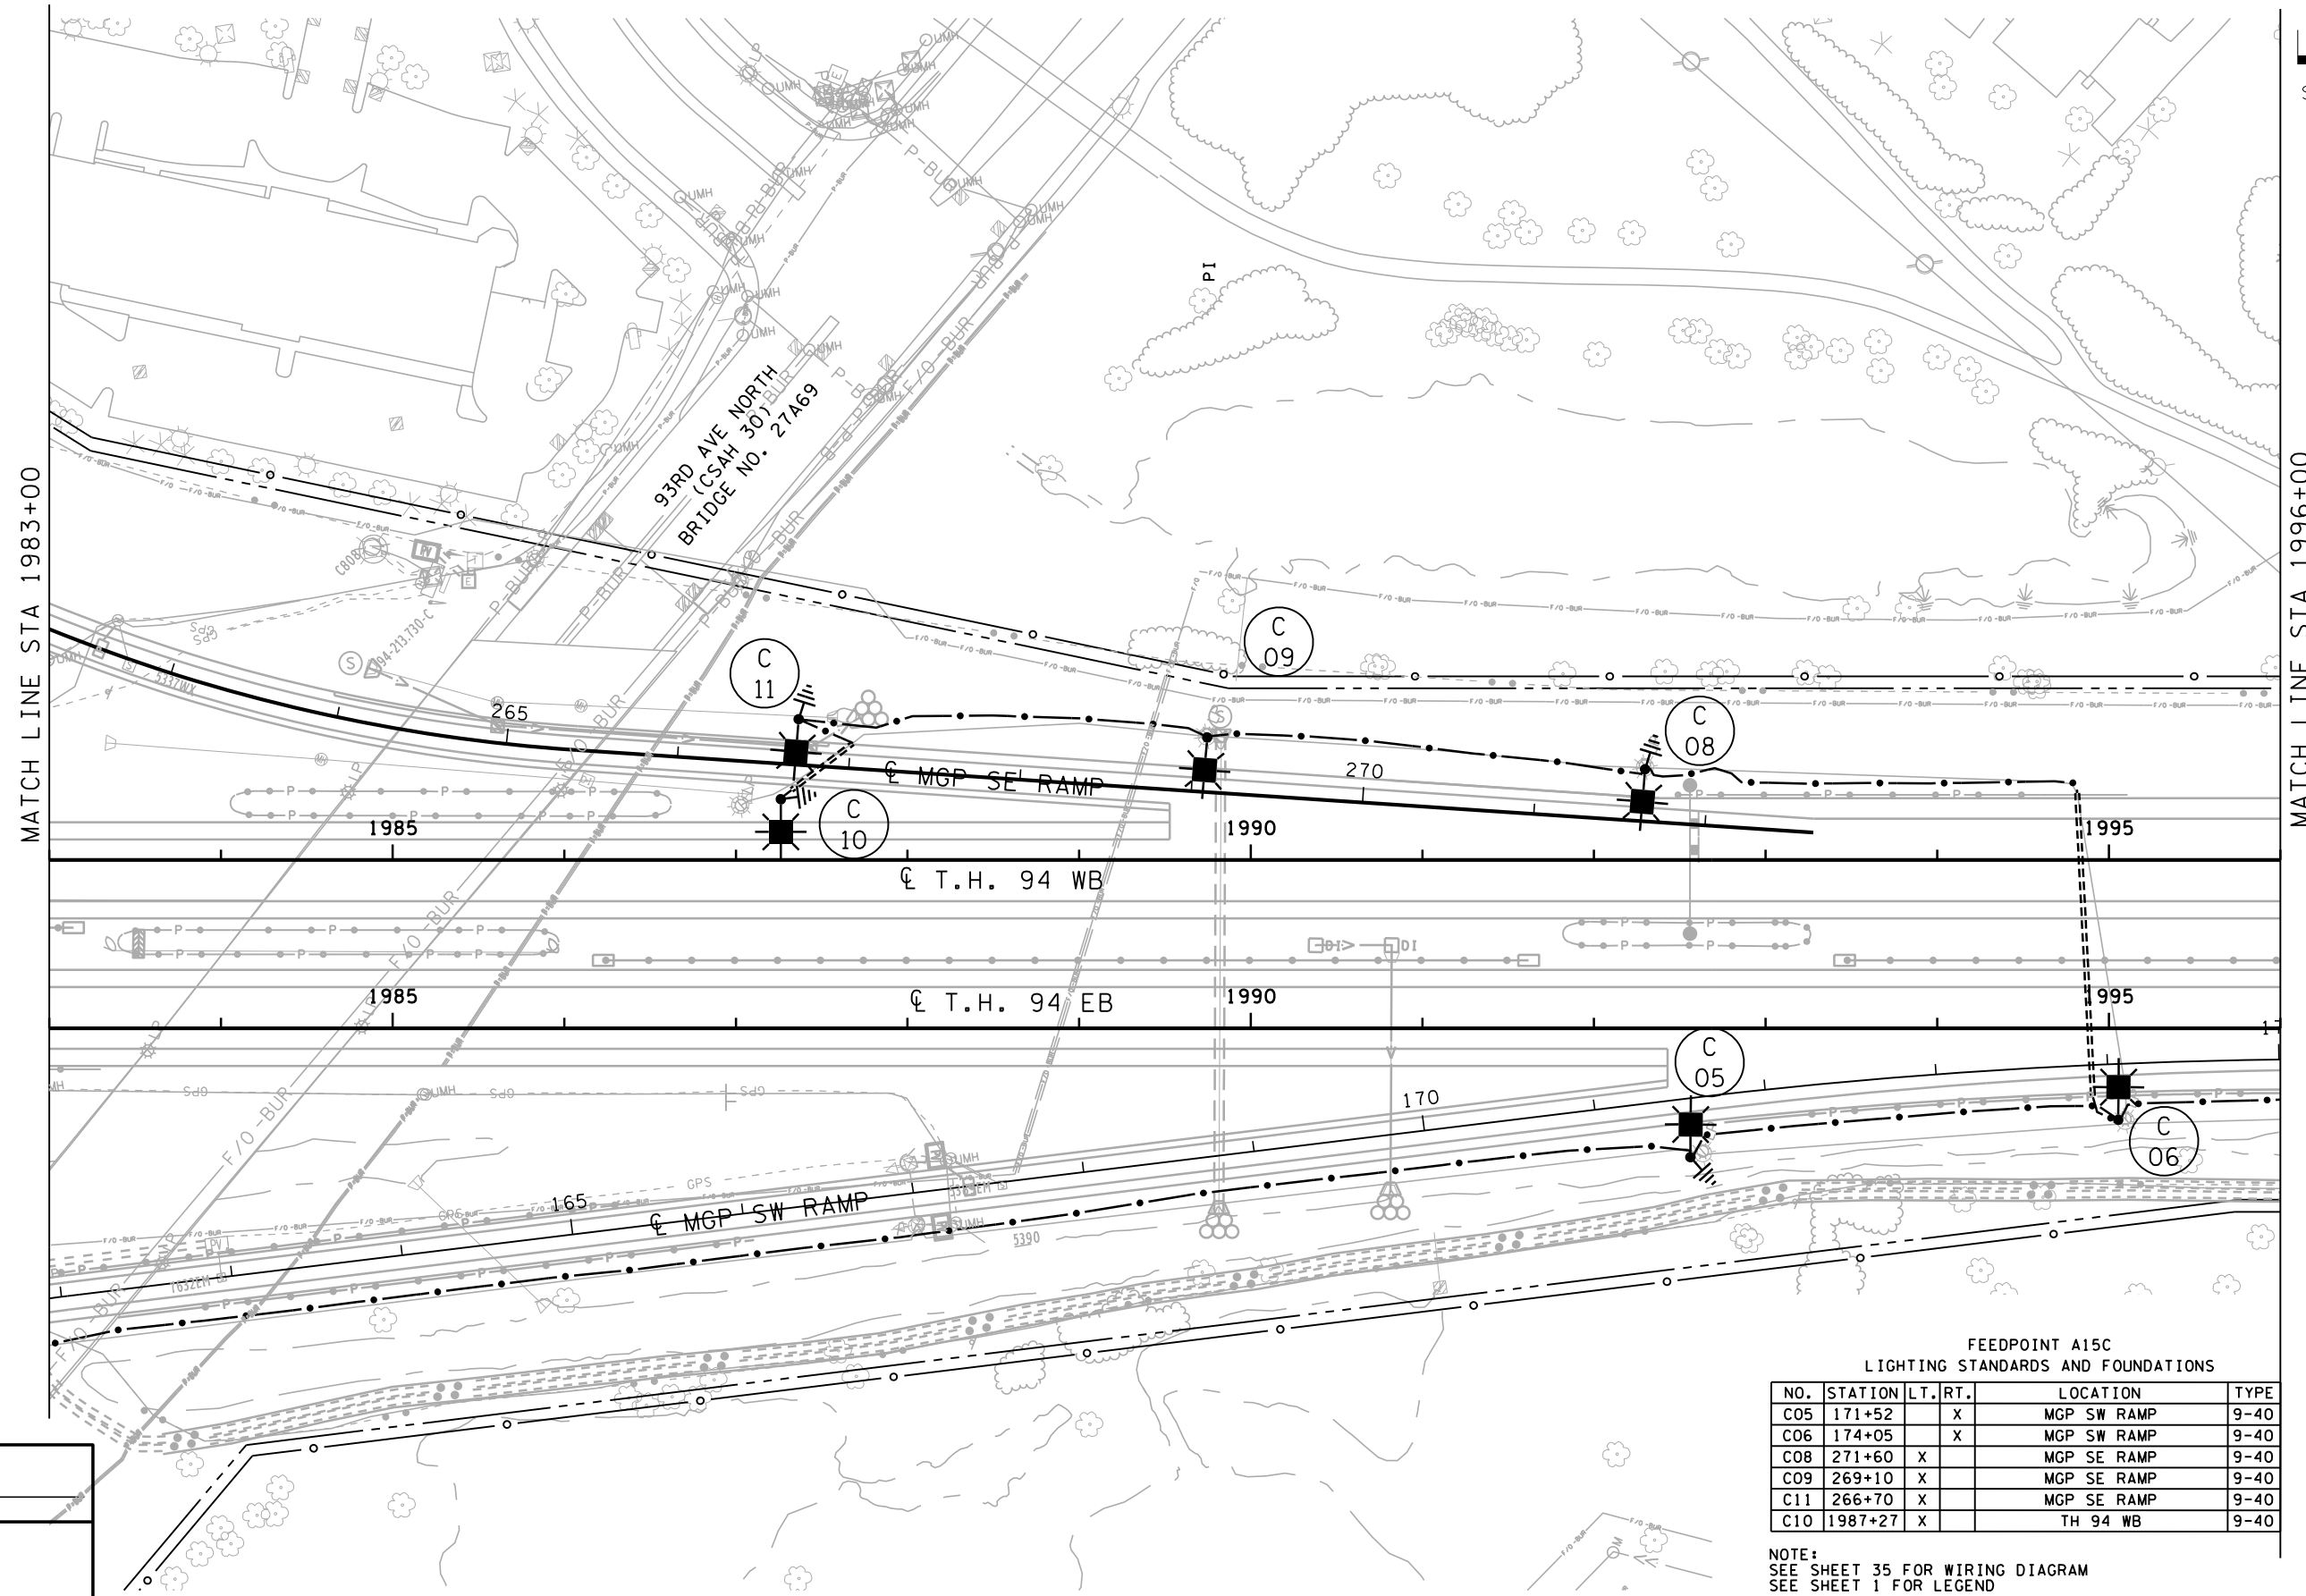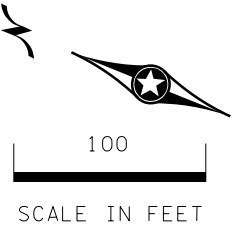

FEEDPOINT A15C  
LIGHTING STANDARDS AND FOUNDATIONS

NO.	STATION	LT.	RT.	LOCATION	TYPE
C05	171+52		X	MGP SW RAMP	9-40
C06	174+05		X	MGP SW RAMP	9-40
C08	271+60	X		MGP SE RAMP	9-40
C09	269+10	X		MGP SE RAMP	9-40
C11	266+70	X		MGP SE RAMP	9-40
C10	1987+27	X		TH 94 WB	9-40

NOTE:  
SEE SHEET 35 FOR WIRING DIAGRAM  
SEE SHEET 1 FOR LEGEND

NO	DATE	DWN	CKD	REVISIONS

**C.S. McCrossan** **Michael Baker**  
INTERNATIONAL

I HEREBY CERTIFY THAT THIS SHEET WAS PREPARED BY ME OR UNDER MY DIRECT SUPERVISION AND THAT I AM A DULY LICENSED PROFESSIONAL ENGINEER UNDER THE LAWS OF THE STATE OF MINNESOTA.




PRINT NAME: STEVEN STUART, PE  
SIGNATURE: \_\_\_\_\_  
DATE 12-24-2021 LICENSE #57479

LIGHTING PLANS  
STA 1983+00 TO STA 1996+00

I-94 MAPLE GROVE TO ROGERS DB (S.P. 2780-97)  
SHEET NO. SL34 OF SL61 SHEETS

PLOTTED/REVISED: 23-NOV-2022

PATH & FILENAME: Minneapolis\_MN\01\_Projects\176174\_194\_MPLGR\_DB\4) DGN\_Sheets\Illumination\C0278097\_IL31.dgn

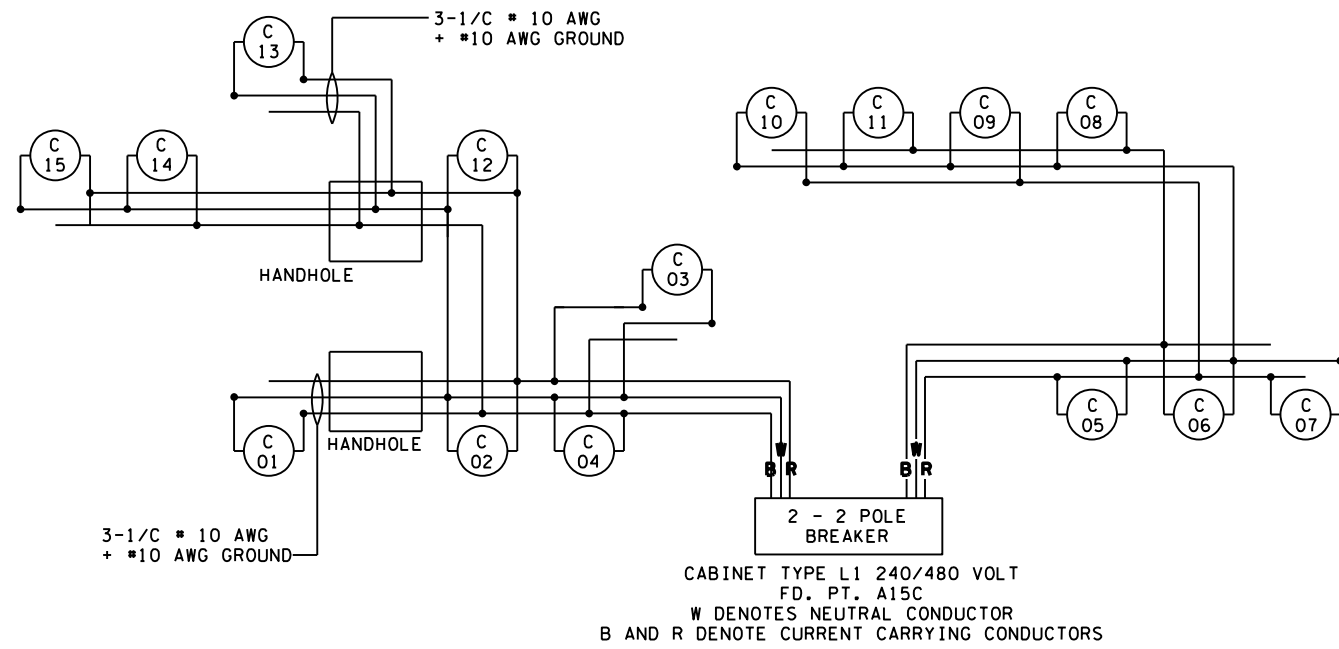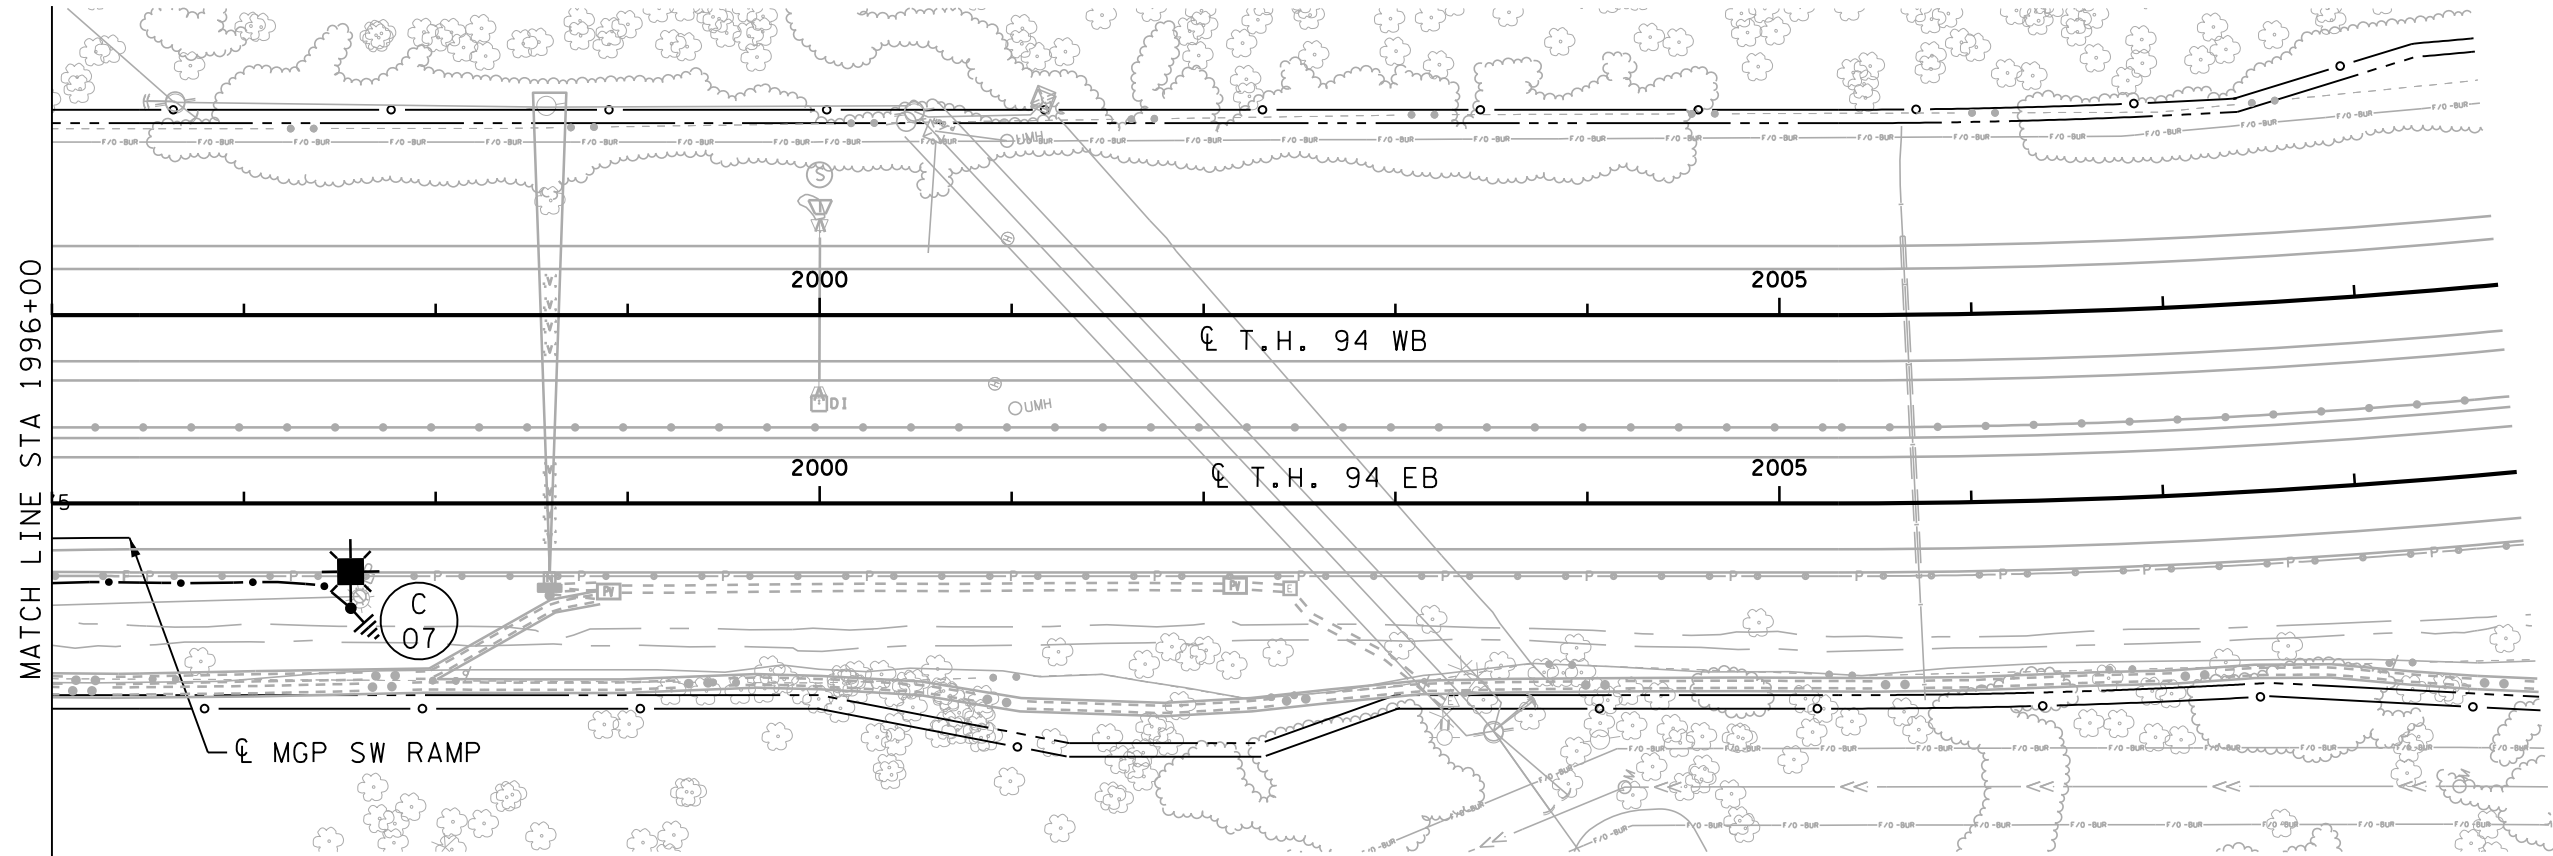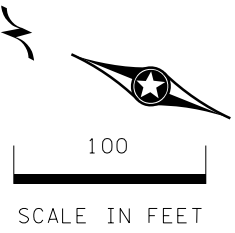

CABINET TYPE L1 240/480 VOLT  
 FD. PT. A15C  
 W DENOTES NEUTRAL CONDUCTOR  
 B AND R DENOTE CURRENT CARRYING CONDUCTORS

FEEDPOINT A15C  
 LIGHTING STANDARDS AND FOUNDATIONS

NO.	STATION	LT.	RT.	LOCATION	TYPE
C07	1997+55		X	TH 94 EB	9-40

NOTE:  
 SEE SHEET 1 FOR LEGEND

NO	DATE	DWN	CKD	REVISIONS

**C.S. McCrossan** **Michael Baker**  
 INTERNATIONAL

I HEREBY CERTIFY THAT THIS SHEET WAS PREPARED BY ME OR UNDER MY DIRECT SUPERVISION AND THAT I AM A DULY LICENSED PROFESSIONAL ENGINEER UNDER THE LAWS OF THE STATE OF MINNESOTA.

PRINT NAME: STEVEN STUART, PE  
 SIGNATURE: \_\_\_\_\_  
 DATE 12-24-2021 LICENSE #57479

LIGHTING PLANS  
 STA 1996+00 TO STA 2009+00

I-94 MAPLE GROVE TO ROGERS DB (S.P. 2780-97)  
 SHEET NO. SL35 OF SL61 SHEETS