
 

 



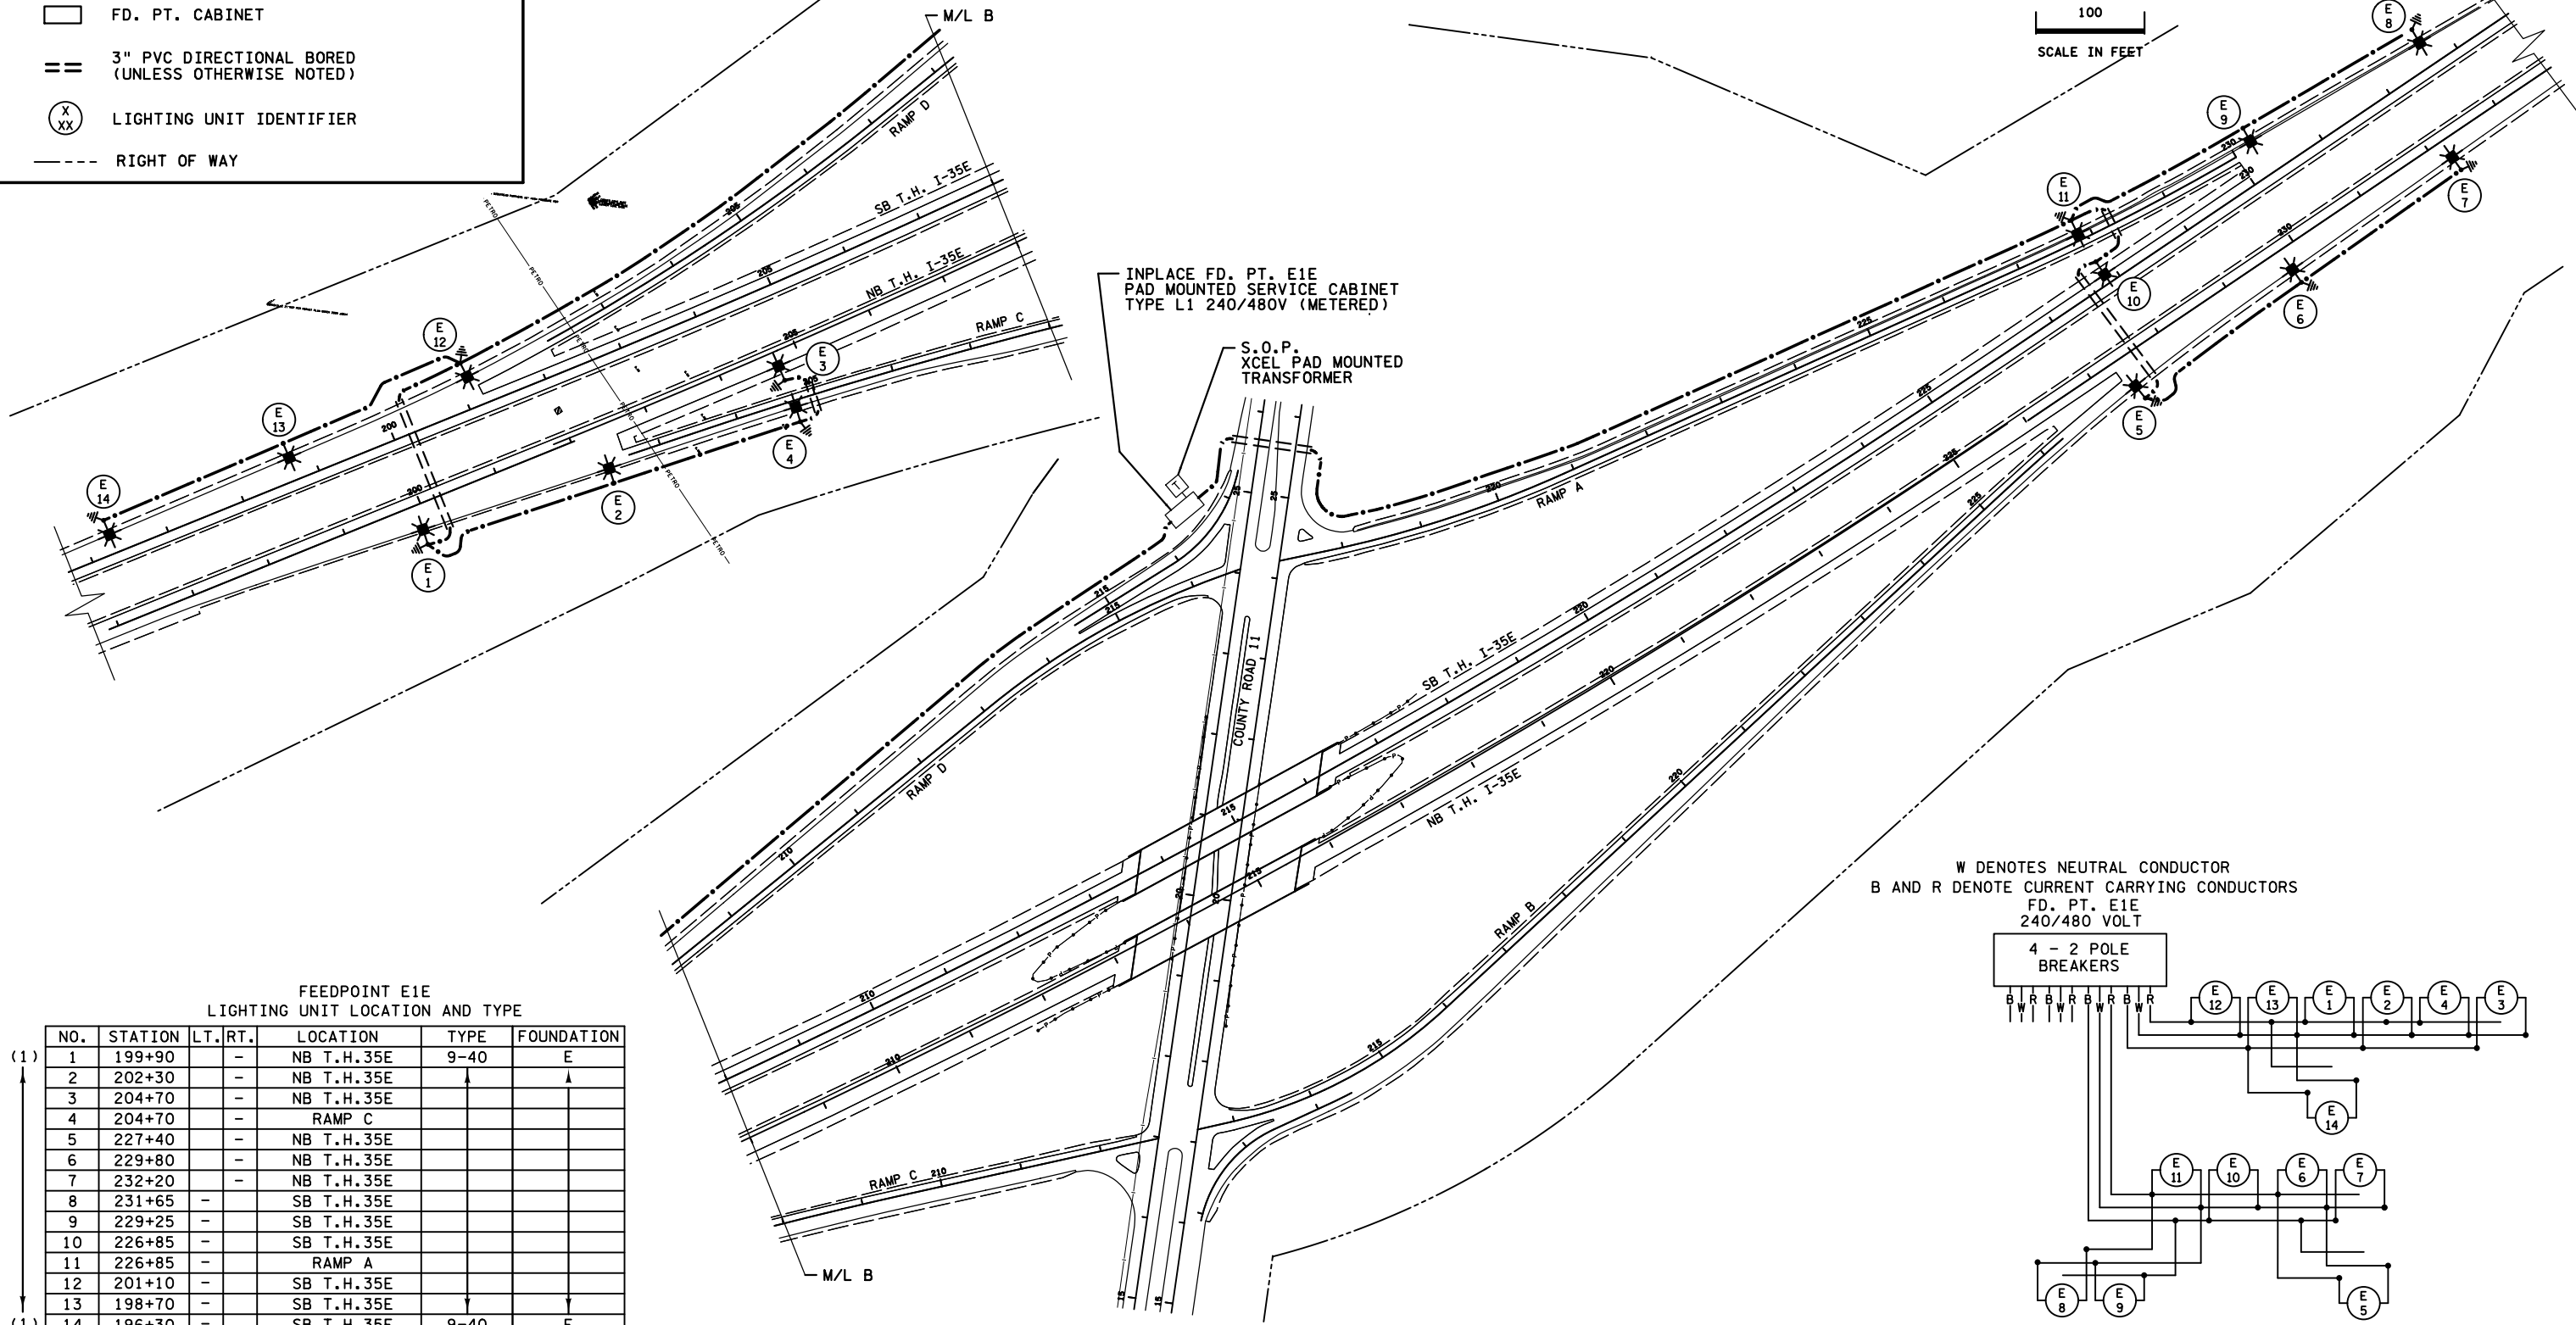
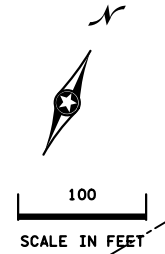


LEGEND


-  LIGHTING UNIT
-  PERMANENT GROUND ROD (25 OHMS OR LESS)
-  DIRECT BURIED CABLE 4/C 4 AWG
-  FD. PT. CABINET
-  3" PVC DIRECTIONAL BORED (UNLESS OTHERWISE NOTED)
-  LIGHTING UNIT IDENTIFIER
-  RIGHT OF WAY



INPLACE FD. PT. E1E
PAD MOUNTED SERVICE CABINET
TYPE L1 240/480V (METERED)

S.O.P.
XCEL PAD MOUNTED
TRANSFORMER

W DENOTES NEUTRAL CONDUCTOR
B AND R DENOTE CURRENT CARRYING CONDUCTORS
FD. PT. E1E
240/480 VOLT

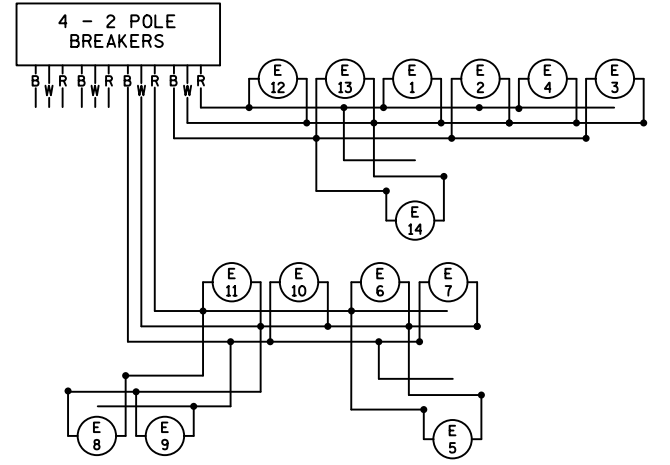


FEEDPOINT E1E
LIGHTING UNIT LOCATION AND TYPE

NO.	STATION	LT.	RT.	LOCATION	TYPE	FOUNDATION
1	199+90	-	-	NB T.H. 35E	9-40	E
2	202+30	-	-	NB T.H. 35E		
3	204+70	-	-	NB T.H. 35E		
4	204+70	-	-	RAMP C		
5	227+40	-	-	NB T.H. 35E		
6	229+80	-	-	NB T.H. 35E		
7	232+20	-	-	NB T.H. 35E		
8	231+65	-	-	SB T.H. 35E		
9	229+25	-	-	SB T.H. 35E		
10	226+85	-	-	SB T.H. 35E		
11	226+85	-	-	RAMP A		
12	201+10	-	-	SB T.H. 35E		
13	198+70	-	-	SB T.H. 35E		
14	196+30	-	-	SB T.H. 35E	9-40	E

(1) INSTALL SALVAGED LUMINAIRE

PLOTTED/REVISED: 11/27/2017

DISTRICT #: METRO
PLOT NAME: T1982-188LIT.L03
PATH & FILENAME: IP_PWP.d18931751T1982-188LIT.L0.dgn

BY	DATE	REVISIONS	FEEDPOINT: E1E LOCATION: CO. RD. 11	METER ADDRESS: 300 CO. RD.11, BURNSVILLE, MN 55337	LIGHTING PLAN
			CERTIFIED BY  LIC. NO. 19863 DATE: 11/27/2017		STATE PROJ.NO. 1982-188 (T.H. 35E) SHEET NO. 15 OF 28 SHEETS
DRAWN BY: JC CKD BY: PB					