


 

 


PLOTTED/REVISED: 1/28/2016

LEGEND


-  LIGHTING UNIT
-  DIRECT BURIED CABLE 4 CONDUCTOR NO. 4
-  PERMANENT GROUND ROD (25 OHMS OR LESS)
-  3" PVC CONDUIT DIRECT BORED (UNLESS NOTED OTHERWISE)
-  LIGHTING UNIT IDENTIFIER
-  INPLACE FD. PT. CABINET




FEEDPOINT E4H
LIGHTING UNIT LOCATION AND TYPE

NO.	STATION	LT.	RT.	LOCATION	TYPE	FOUNDATION
1	373+20		X	NB35E	9-40 LED	DESIGN E
2	375+45		X			
3	377+70		X			
4	379+95		X			
5	382+00		X			
6	385+35		X			
7	387+70		X			
8	390+05		X			
9	392+30		X			
(1)	10		X			
(1)	11		X			
(1)	12		X			
(1)	13		X			
(1)	14		X	NB35E		
	15		X	SB35E		
	16		X			
	17		X			
	18		X			
	19		X			
	20		X			
	21		X			
	22		X			
	23		X			
	24		X			
	25		X			
	26		X			
	27		X			
	28		X	SB35E		
	29	AS SHOWN	X	NB VICTORIA		
	30		X	SERAMP		
	31		X	SERAMP		
	32		X	SERAMP		
(1)	33		X	SERAMP		
	34		X	NERAMP		
	35		X	NERAMP		
	36		X	NERAMP		
	37		X	NERAMP		
	38	AS SHOWN	X	NB VICTORIA	9-40 LED	DESIGN E

(1) ACCESS COVER 90 DEGREES FROM DAVIT.

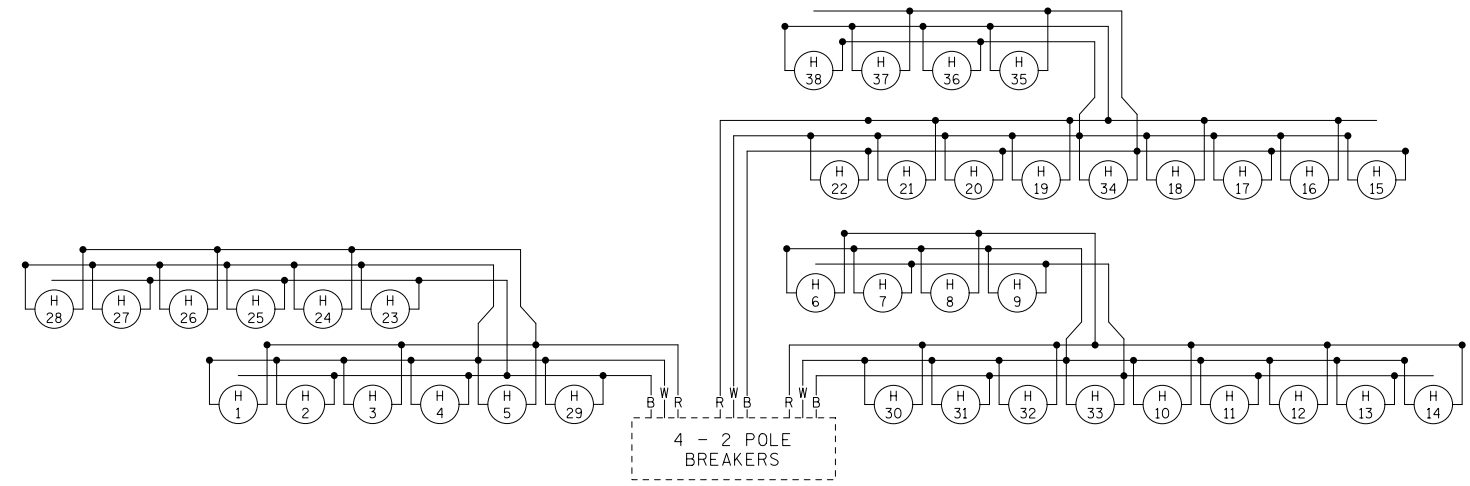

4 - 2 POLE BREAKERS
240/480 VOLT FD. PT. E4H
B AND R DENOTE CURRENT CARRYING CONDUCTORS
W DENOTES NEUTRAL CONDUCTOR
DASHED LINES DENOTE INPLACE ITEMS

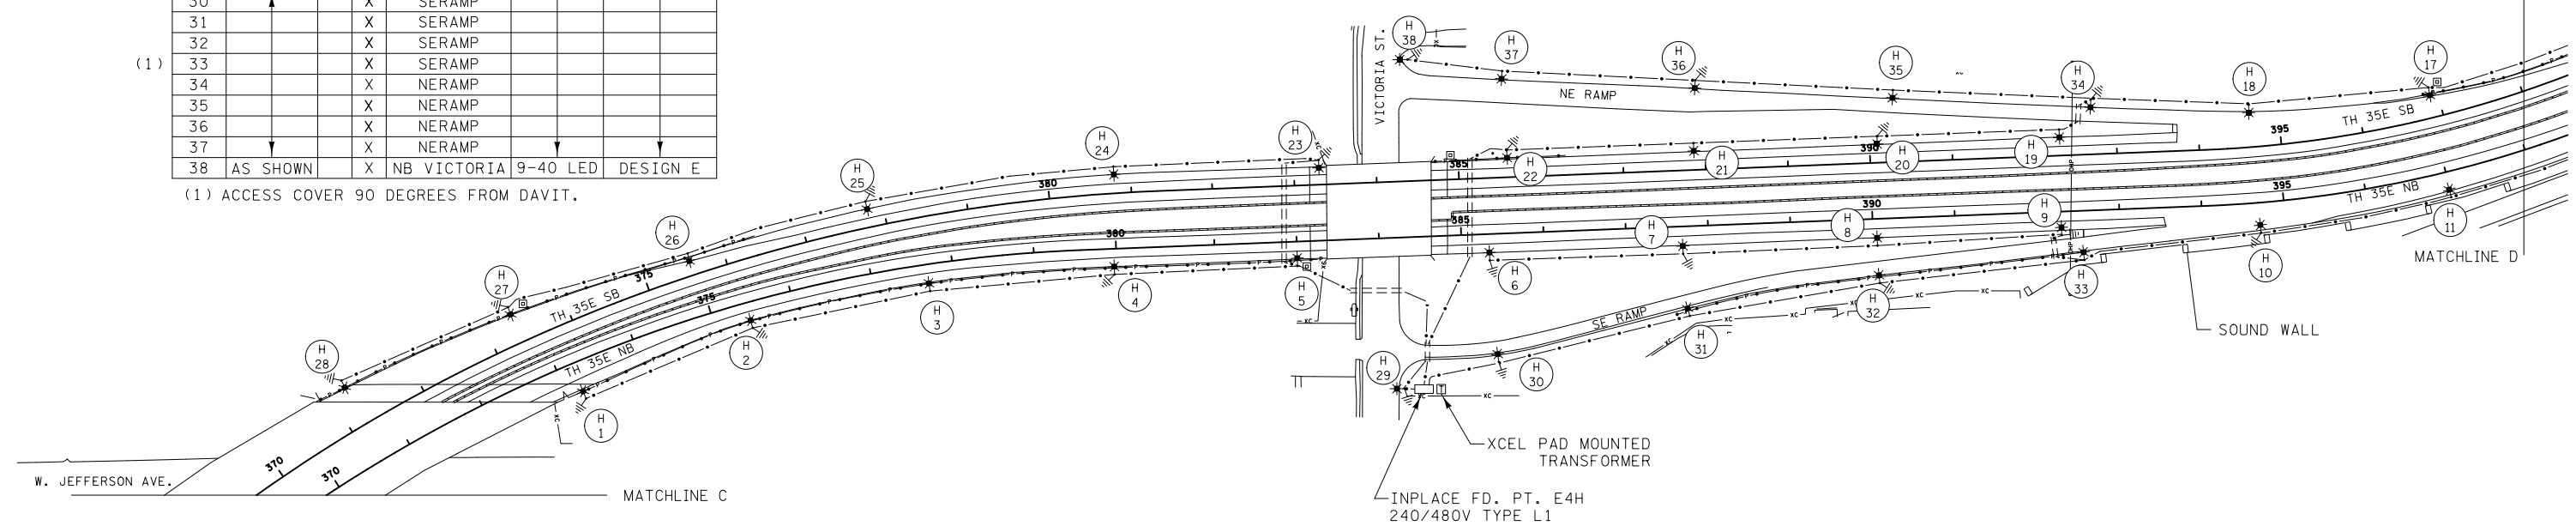

BY	DATE	REVISIONS

DRAWN BY: PB CKD BY: GK DATE: 1/2016

FEEDPOINT: E4H LOCATION: VICTORIA ST.
METER ADDRESS: 570 VICTORIA STREET SOUTH, ST. PAUL 55102

CERTIFIED BY *Michael P. Lubensky* LIC. NO. 19863 DATE: 1/28/2016
LICENSED PROFESSIONAL ENGINEER

LIGHTING PLAN

STATE PROJ. NO. 6280-370 (T.H.35E) SHEET NO. 20 OF 30 SHEETS

DISTRICT #: METRO
PLOT NAME: 16280-370.ltr.joio
PATH & FILENAME: IP_PWP-d170424016280-370.ltr.joio2.dgn