

 
 







# LEGEND

-  LIGHTING UNIT
-  LIGHTING UNIT
-  PERMANENT GROUND ROD (25 OHMS OR LESS)
-  DIRECT BURIED LIGHTING CABLE 4/C 4 AWG
-  FD. PT. CABINET
-  3" PVC DIRECTIONAL BORED (UNLESS OTHERWISE NOTED)
-  LIGHTING UNIT IDENTIFIER
-  RIGHT OF WAY

## FEEDPOINT 02C1 LIGHTING UNIT LOCATION AND TYPE


NO.	STATION	LT.	RT.	LOCATION	TYPE	FOUNDATION
1	1092+15	X		NB TH65	9D-40	E
2	1099+50		X	NB TH65	9-40	
3	1101+73		X	NB TH65	9-40	
4	1108+80	X		NB TH65	9D-40	
5						
6	1101+70	X		SB TH65	9-40	
7	1102+20	X		SB TH65	9-40	
9	1101+36	X		NB TH65	9-40	E

  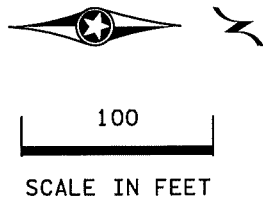



PLOTTED/REVISED: 30-JAN-2020


DISTRICT: Metro  
PLOT NAME: 10208-160\_111\_lo  
PATH & FILENAME: Projects\DM\_R05\065\0208\60V\Traffic\Lighting\10208-160\_111\_lo.dgn

W DENOTES NEUTRAL CONDUCTOR  
B AND R DENOTE CURRENT CARRYING CONDUCTORS  
FD. PT. 02C1  
240/480 VOLT

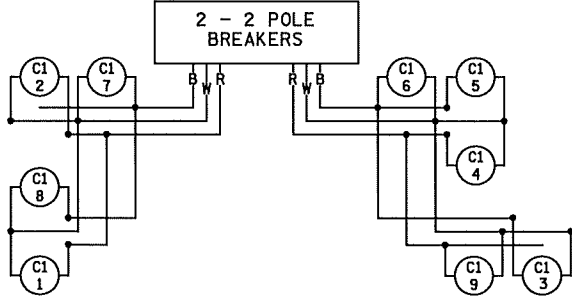

FD. PT. 02C1  
PAD MOUNTED SERVICE CABINET  
TYPE RURAL LIGHTING AND FLASHING (RLF)  
120/240V (METERED)  
GROUND MOUNTED CABINET FOUNDATION.  
2" R.S.C. 3-1/2 AWG TO CONNEXUS ENERGY  
FURNISHED PEDESTAL LEAVING A 6' LOOP.

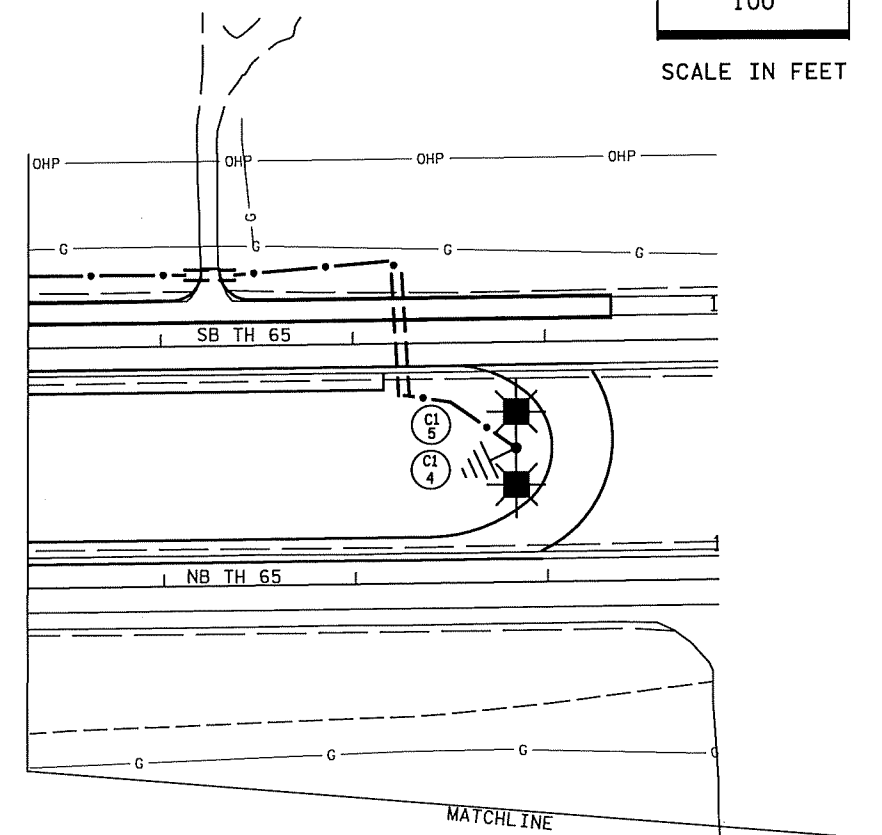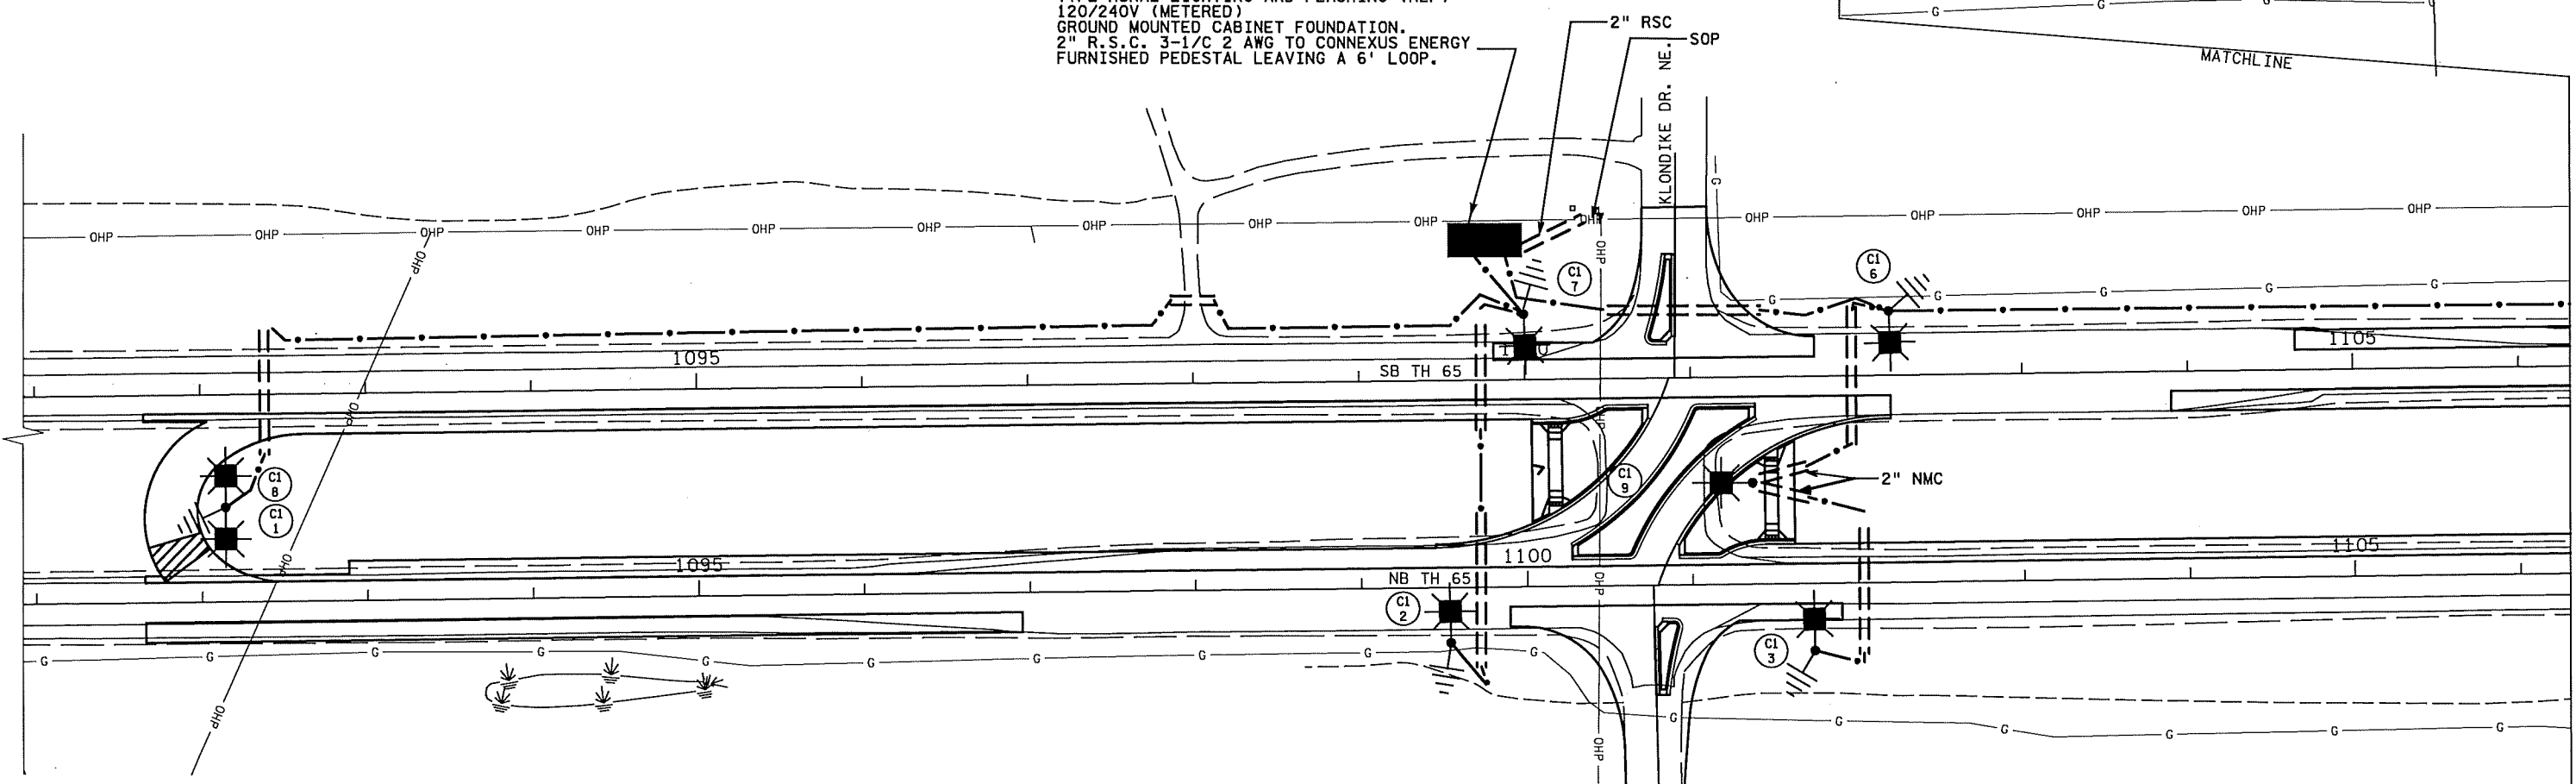

<b>BY</b>	<b>DATE</b>	<b>REVISIONS</b>	<b>FEEDPOINT: 02C1</b>	<b>LOCATION: KLONDIKE DR. NE.</b>	<h2>LIGHTING PLAN</h2>
			<b>METER ADDRESS: 20098 HWY 65, EAST BETHEL, MN 55304</b>		
<b>DRAWN BY:</b> HL	<b>CKD BY:</b> PB		<b>CERTIFIED BY</b> 	<b>LIC. NO. 19863</b>	<b>DATE: 30-JAN-2020</b>
			<b>STATE PROJ.NO. 0208-160 (TH 65)</b>		<b>SHEET NO. SL3 OF SL3 SHEETS</b>