


LIGHTING STANDARDS AND BASES					
NO.	STATION	LT.	RT.	LOCATION	TYPE
1	47+755		---	T.H. 610 E.B.	4-12
2	47+828		---	T.H. 610 E.B.	4-12
3	47+890		---	T.H. 610 E.B.	3-12
4	47+910		---	T.H. 610 E.B.	4-12
5	47+755	---		T.H. 610 W.B.	4-12
6	47+680	---		T.H. 610 W.B.	4-12
7	47+605	---		T.H. 610 W.B.	4-12

SEE SHEET 7 FOR PLACEMENT OF LIGHTING UNITS

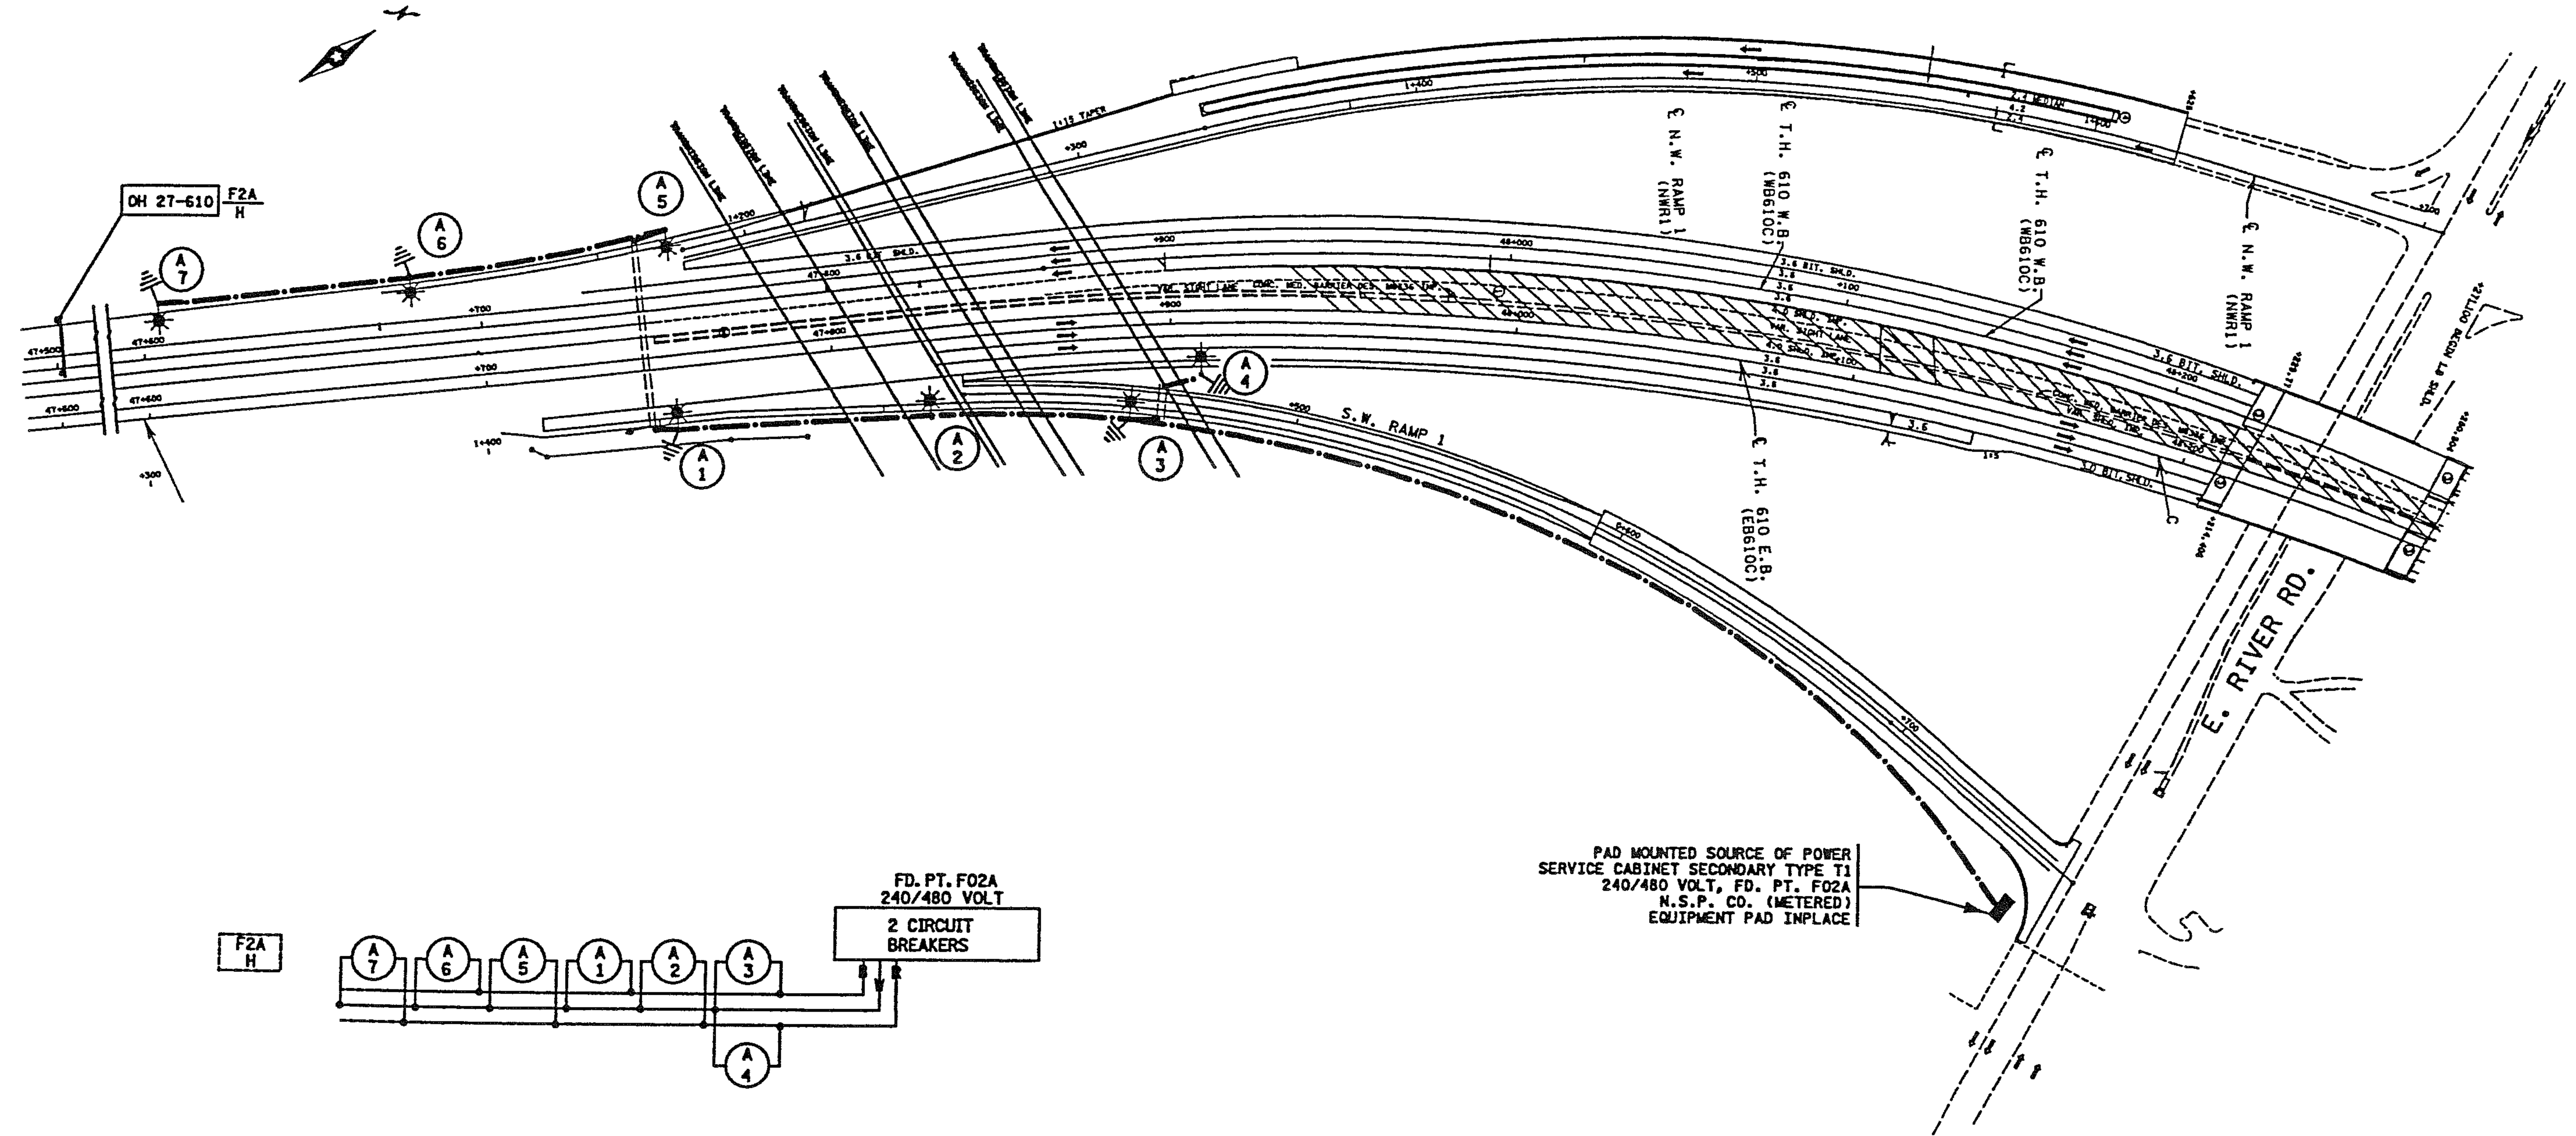

AS BUILT 03/10

CERTIFIED BY

Susan J. Lott
PROFESSIONAL ENGINEER

REG. NO. 21180

State Proj. No. 0217-16 (T.H. 610)

Sheet No. 578 of 891 Sheets



LIGHTING PLAN