


SEE SHEET 7 FOR LEGEND

B AND R DENOTE CURRENT CARRYING CONDUCTORS
W DENOTES NEUTRAL CONDUCTOR

PLOTTED/REVISED: 6/16/2009

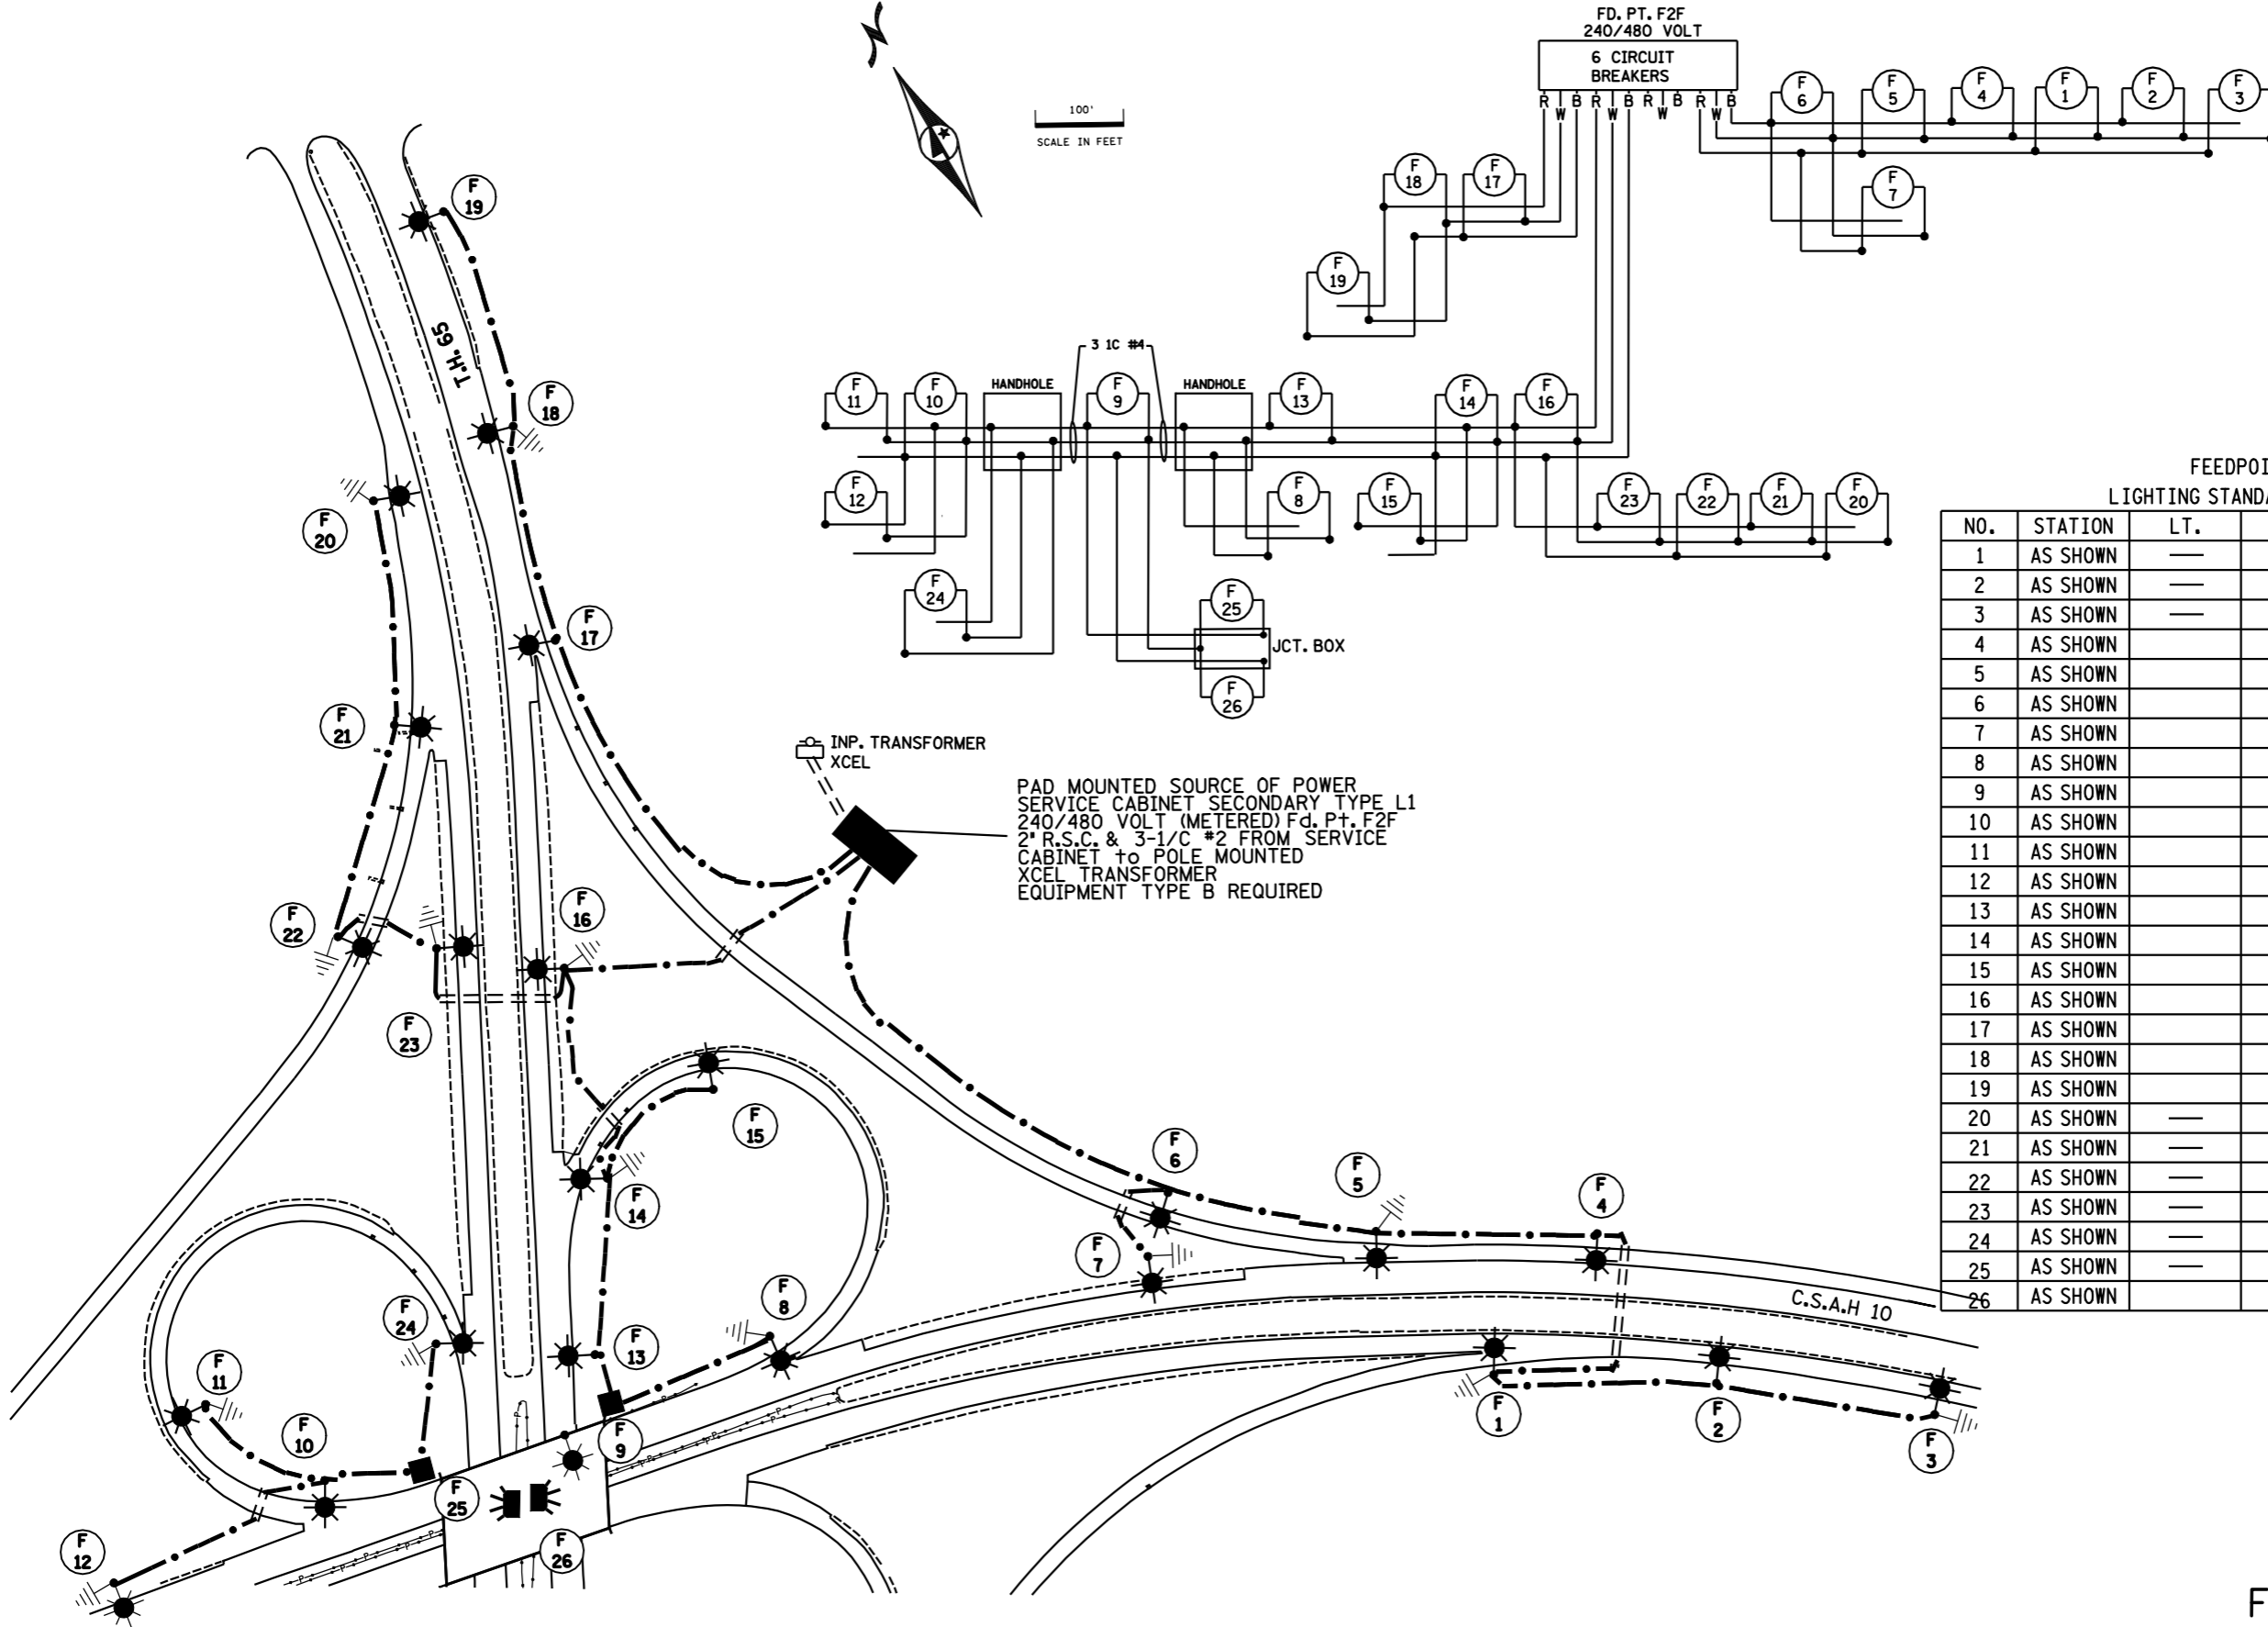

FEEDPOINT F2F
LIGHTING STANDARDS AND BASES

NO.	STATION	LT.	RT.	LOCATION	TYPE	WATTAGE
1	AS SHOWN	---	---	EB CSAH 10	9-40	250
2	AS SHOWN	---	---	EB CSAH 10	9-40	250
3	AS SHOWN	---	---	EB CSAH 10	9-40	250
4	AS SHOWN	---	---	WB CSAH 10	9-40	250
5	AS SHOWN	---	---	WB CSAH 10	9-40	250
6	AS SHOWN	---	---	NE RAMP	9-40	250
7	AS SHOWN	---	---	WB CSAH 10	9-40	250
8	AS SHOWN	---	---	WB CSAH 10	9-40	250
9	AS SHOWN	---	---	WB CSAH 10	6B-40	250
10	AS SHOWN	---	---	WB CSAH 10	9-40	250
11	AS SHOWN	---	---	NW LOOP	9-40	250
12	AS SHOWN	---	---	WB CSAH 10	9-40	250
13	AS SHOWN	---	---	NB TH65	9-40	250
14	AS SHOWN	---	---	NB TH65	9-40	250
15	AS SHOWN	---	---	NE LOOP	9-40	250
16	AS SHOWN	---	---	NB TH65	9-40	250
17	AS SHOWN	---	---	NB TH65	9-40	250
18	AS SHOWN	---	---	NB TH65	9-40	250
19	AS SHOWN	---	---	NB TH65	9-40	250
20	AS SHOWN	---	---	SB TH65	9-40	250
21	AS SHOWN	---	---	SB TH65	9-40	250
22	AS SHOWN	---	---	NW RAMP	9-40	250
23	AS SHOWN	---	---	SB TH65	9-40	250
24	AS SHOWN	---	---	SB TH65	9-40	250
25	AS SHOWN	---	---	SB TH65	L	250
26	AS SHOWN	---	---	NB TH65	L	250

DISTRICT #: METRO
IPLOT NAME: 0207-88j02F2F
PATH & FILENAME: IP_PWP-d097060\0207-88j02ab.dgn

BY	DATE	REVISIONS	SYSTEM ID: 5389 FEEDPOINT: F2F	T.E.	LOCATION: C.S.A.H 10	FEEDPOINT F2F LIGHTING PLAN
PB	6-10-2009	AS - BUILT	METER ADDRESS: 8500 PLAZA BLVD, SPRING LAKE PARK, 55432			
DRAWN BY: PB CKD BY: GB DATE:			CERTIFIED BY: <i>Michael P. Lubensky</i> LICENSED PROFESSIONAL ENGINEER	LIC. NO. 19863	DATE: 11/25/2008	STATE PROJ. NO. 0207-88 (T.H.65) SHEET NO. 9 OF 9 SHEETS