


FD. PT. F6H

| LIGHTING STANDARDS AND BASES | | | | | |
|------------------------------|---------|-----|-----|--------------|------|
| NO. | STATION | LT. | RT. | LOCATION | TYPE |
| (1) 1 | 40+400 | - | - | T.H.610 E.B. | L |
| 2 | 40+440 | - | - | T.H.610 E.B. | 3-12 |
| 3 | 40+510 | - | - | T.H.610 E.B. | 3-12 |
| 4 | 40+580 | - | - | T.H.610 E.B. | 3-12 |
| 5 | 0+060 | - | - | LOOP D | 2-12 |
| 6 | 40+925 | - | - | T.H.610 E.B. | 3-12 |
| 7 | 40+998 | - | - | T.H.610 E.B. | 3-12 |
| 8 | 41+071 | - | - | T.H.610 E.B. | 3-12 |
| 9 | 40+987 | - | - | T.H.610 W.B. | 3-12 |
| 10 | 40+915 | - | - | T.H.610 W.B. | 3-12 |
| 11 | 40+845 | - | - | T.H.610 W.B. | 3-12 |
| 12 | 0+063 | - | - | RAMP A | 2-12 |
| 13 | 40+507 | - | - | T.H.610 W.B. | 3-12 |
| 14 | 40+437 | - | - | T.H.610 W.B. | 3-12 |
| (1) 15 | 40+400 | - | - | T.H.610 W.B. | L |

(1) 200 WATT HIGH PRESSURE SODIUM UNDERPASS LIGHT
PLACE LIGHTING UNITS 3 m BEHIND BIT. SHOULDER
OR AS DIRECTED BY THE ENGINEER

CERTIFIED COPY

APR 18 2001

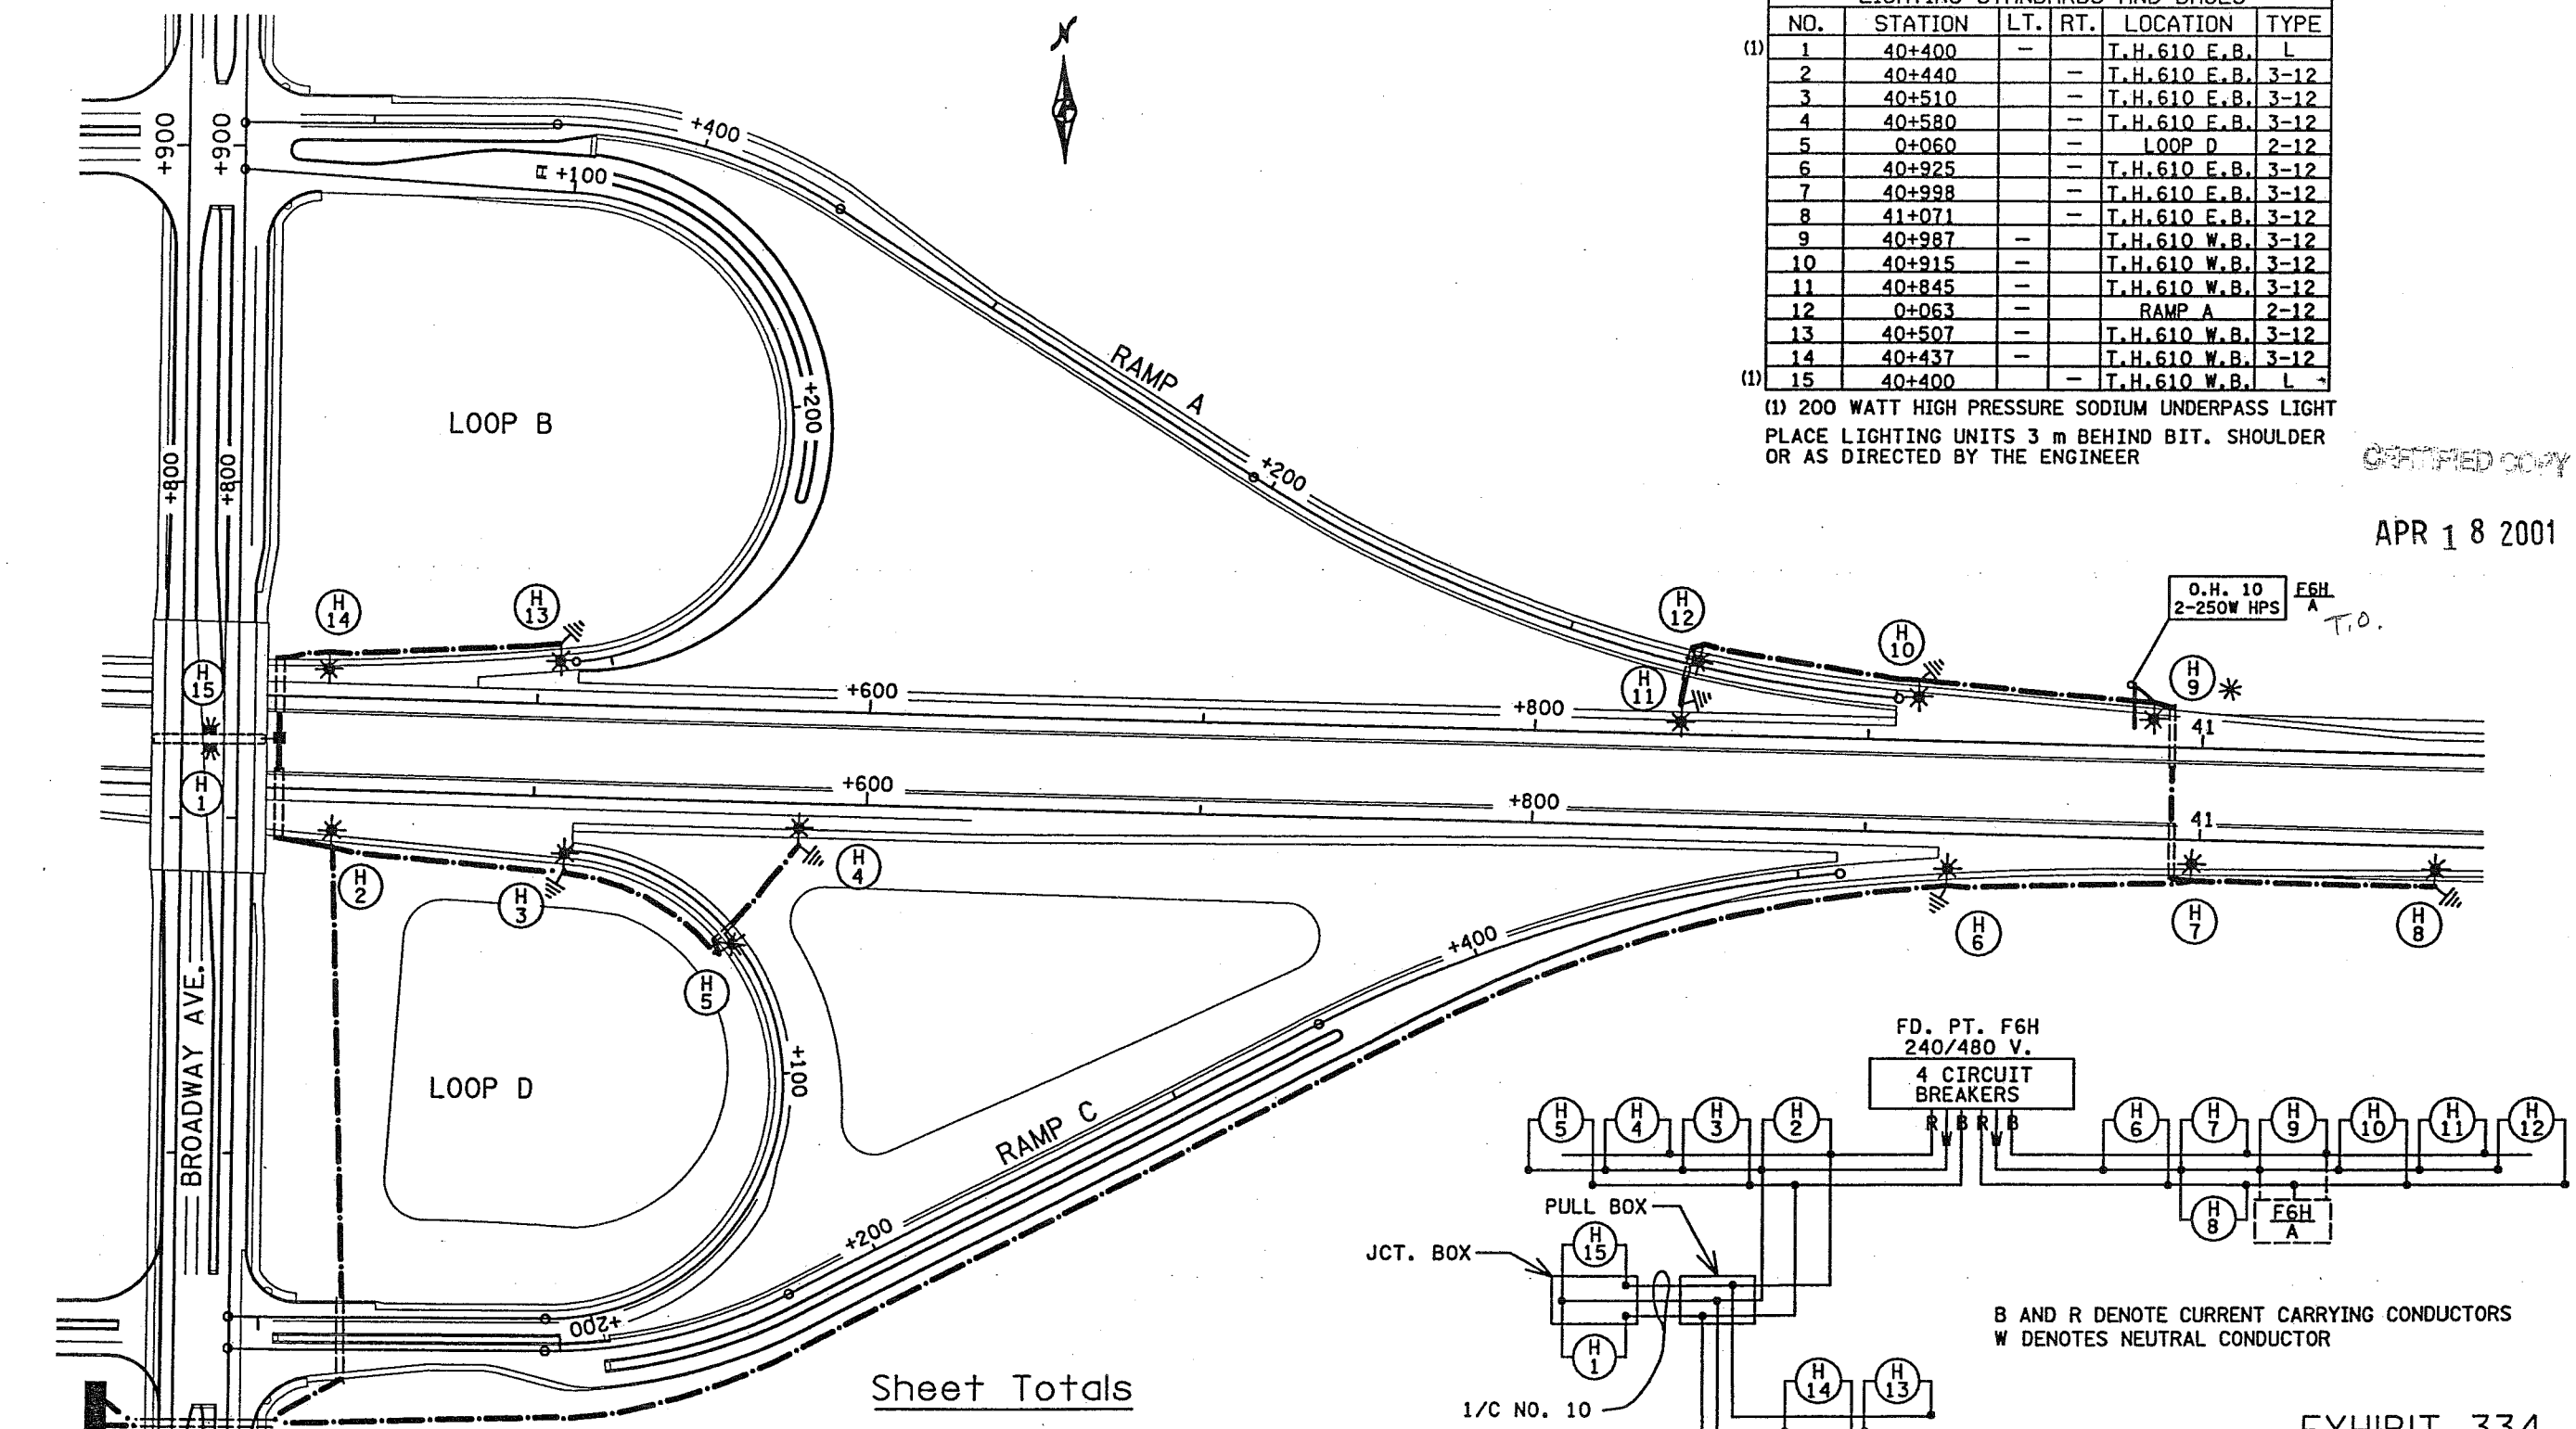

Sheet Totals

13 - 200 Watt High Pressure Sodium Lighting Units
2 - 200 Watt High Pressure Sodium Underpass Lights

Grand Totals

35 - 200 Watt High Pressure Sodium Lighting Units
6 - 200 Watt High Pressure Sodium Underpass Lights

FD. PT. F6H, 240/480 VOLT
PAD MOUNTED SERVICE CABINET
SECONDARY TYPE LI.
EQUIPMENT PAD BY OTHERS.
METERED SERVICE, XCEL CO.

Meter Address: 9670 W. Broadway

CERTIFIED BY *Susan C. Totale* REG. NO. 21180
PROFESSIONAL ENGINEER

State Proj. No. 2771-22 (T.H. 610)

EXHIBIT 334
T.H.610 AT
BROADWAY AVE.
IN BROOKLYN PARK
METERED

LIGHTING PLAN

Sheet No. 3 of 3 Sheets

FP.PT.F6H