 



SEE LEGEND SHEET 16



PLOTTED/REVISED: 9/16/2014

DISTRICT #: METRO
 I/PLOT NAME: 1928-60.II.sht23
 PATH & FILENAME: IP_PWP-d\5884\2\1928-60.II.io.dgn

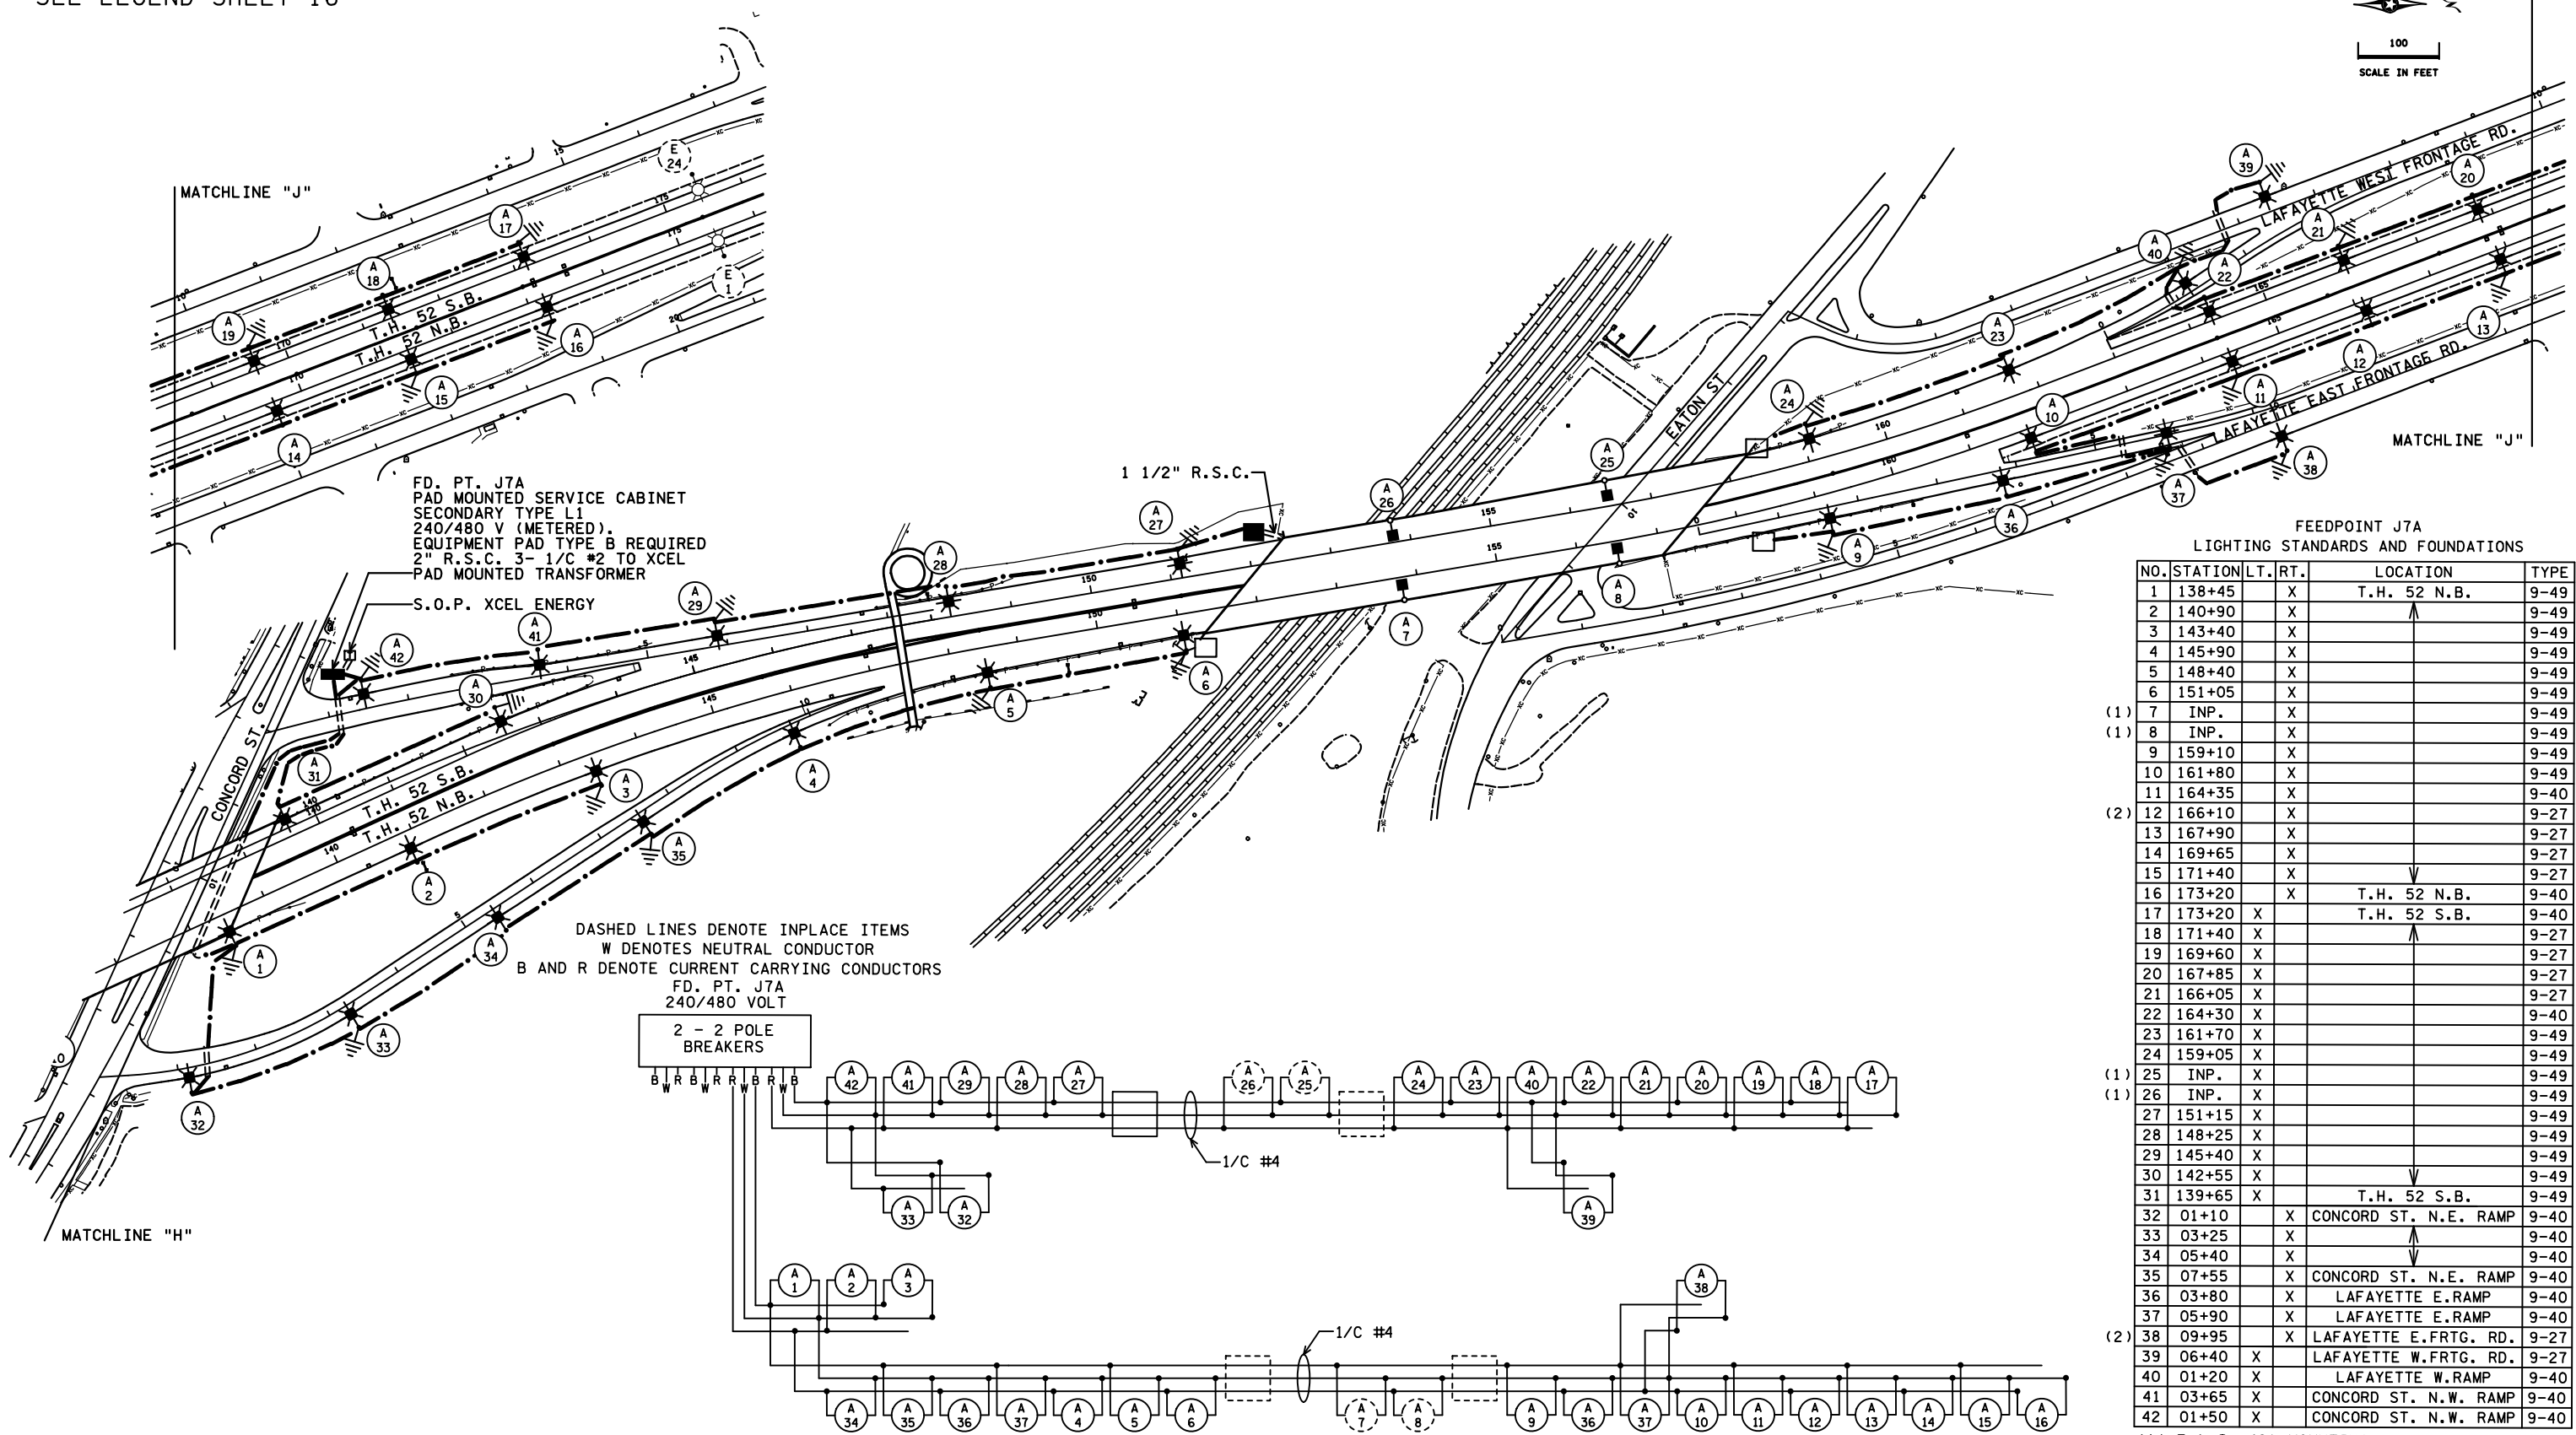

FEEDPOINT J7A
 LIGHTING STANDARDS AND FOUNDATIONS

NO.	STATION	LT.	RT.	LOCATION	TYPE
1	138+45		X	T.H. 52 N.B.	9-49
2	140+90		X		9-49
3	143+40		X		9-49
4	145+90		X		9-49
5	148+40		X		9-49
6	151+05		X		9-49
(1) 7	INP.		X		9-49
(1) 8	INP.		X		9-49
9	159+10		X		9-49
10	161+80		X		9-49
11	164+35		X		9-40
(2) 12	166+10		X		9-27
13	167+90		X		9-27
14	169+65		X		9-27
15	171+40		X		9-27
16	173+20		X	T.H. 52 N.B.	9-40
17	173+20	X		T.H. 52 S.B.	9-40
18	171+40	X			9-27
19	169+60	X			9-27
20	167+85	X			9-27
21	166+05	X			9-27
22	164+30	X			9-40
23	161+70	X			9-49
24	159+05	X			9-49
(1) 25	INP.	X			9-49
(1) 26	INP.	X			9-49
27	151+15	X			9-49
28	148+25	X			9-49
29	145+40	X			9-49
30	142+55	X			9-49
31	139+65	X		T.H. 52 S.B.	9-49
32	01+10	X		CONCORD ST. N.E. RAMP	9-40
33	03+25		X		9-40
34	05+40		X		9-40
35	07+55	X		CONCORD ST. N.E. RAMP	9-40
36	03+80	X		LAFAYETTE E. RAMP	9-40
37	05+90	X		LAFAYETTE E. RAMP	9-40
(2) 38	09+95	X		LAFAYETTE E. FRTG. RD.	9-27
39	06+40	X		LAFAYETTE W. FRTG. RD.	9-27
40	01+20	X		LAFAYETTE W. RAMP	9-40
41	03+65	X		CONCORD ST. N.W. RAMP	9-40
42	01+50	X		CONCORD ST. N.W. RAMP	9-40

(1) F & I: 49' MOUNTING HEIGHT LUMINAIRE
 (2) F & I: AIR OBSTRUCTION LIGHT

FEED POINT J7A

BY	DATE	REVISIONS	FEEDPOINT: J7A	LOCATION: TH 52 AT CONCORD ST.	LIGHTING PLAN
			METER ADDRESS: 350 CONCORD ST. ST. PAUL 55107		
DRAWN BY: DC			CERTIFIED BY: <i>Michael P. Libensky</i>		STATE PROJ. NO. 1928-60 (T.H. 52) SHEET NO. 23 OF 31 SHEETS
CKD BY: GB			LIC. NO. 19863 DATE: 9/16/2014		
DATE: 8/2014					