



SEE LEGEND SHEET 8

DASHED LINES DENOTE INPLACE ITEMS
 W DENOTES NEUTRAL CONDUCTOR
 B AND R DENOTE CURRENT CARRYING CONDUCTORS
 FD. PT. N4N
 240/480 VOLT

FEEDPOINT N4P

LIGHTING STANDARDS AND BASES					
NO.	STATION	LT.	RT.	LOCATION	WATTAGE
1	INPLACE	-	-	WB T.H. 694	250
2					
3					
4					
5					
6					
7					
8					
9					
10					
11					
12					
13					
14	INPLACE	-	-	WB T.H. 694	
15	18+75	-	-	NE RAMP	
16	16+60	-	-	NE RAMP	
17	14+45	-	-	NE RAMP	
18	12+25	-	-	NE RAMP	
19	9+55	-	-	NW RAMP	
20	7+10	-	-	NW RAMP	
21	4+65	-	-	NW RAMP	
22	2+20	-	-	NW RAMP	250

LIGHTING STANDARDS AND BASES					
NO.	STATION	LT.	RT.	LOCATION	WATTAGE
1	INPLACE	-	-	EB T.H. 694	250
2					
3					
4					
5					
6					
7					
8					
9					
10					
11					
12					
13					
14					
15	INPLACE	-	-	EB T.H. 694	
16	1+75	-	-	SW RAMP	
17	3+90	-	-		
18	6+10	-	-		
19	8+25	-	-		
20	10+45	-	-	SW RAMP	
21	12+80	-	-	SE RAMP	
22	14+95	-	-		
23	17+05	-	-		
24	19+15	-	-		
25	21+30	-	-	SE RAMP	250

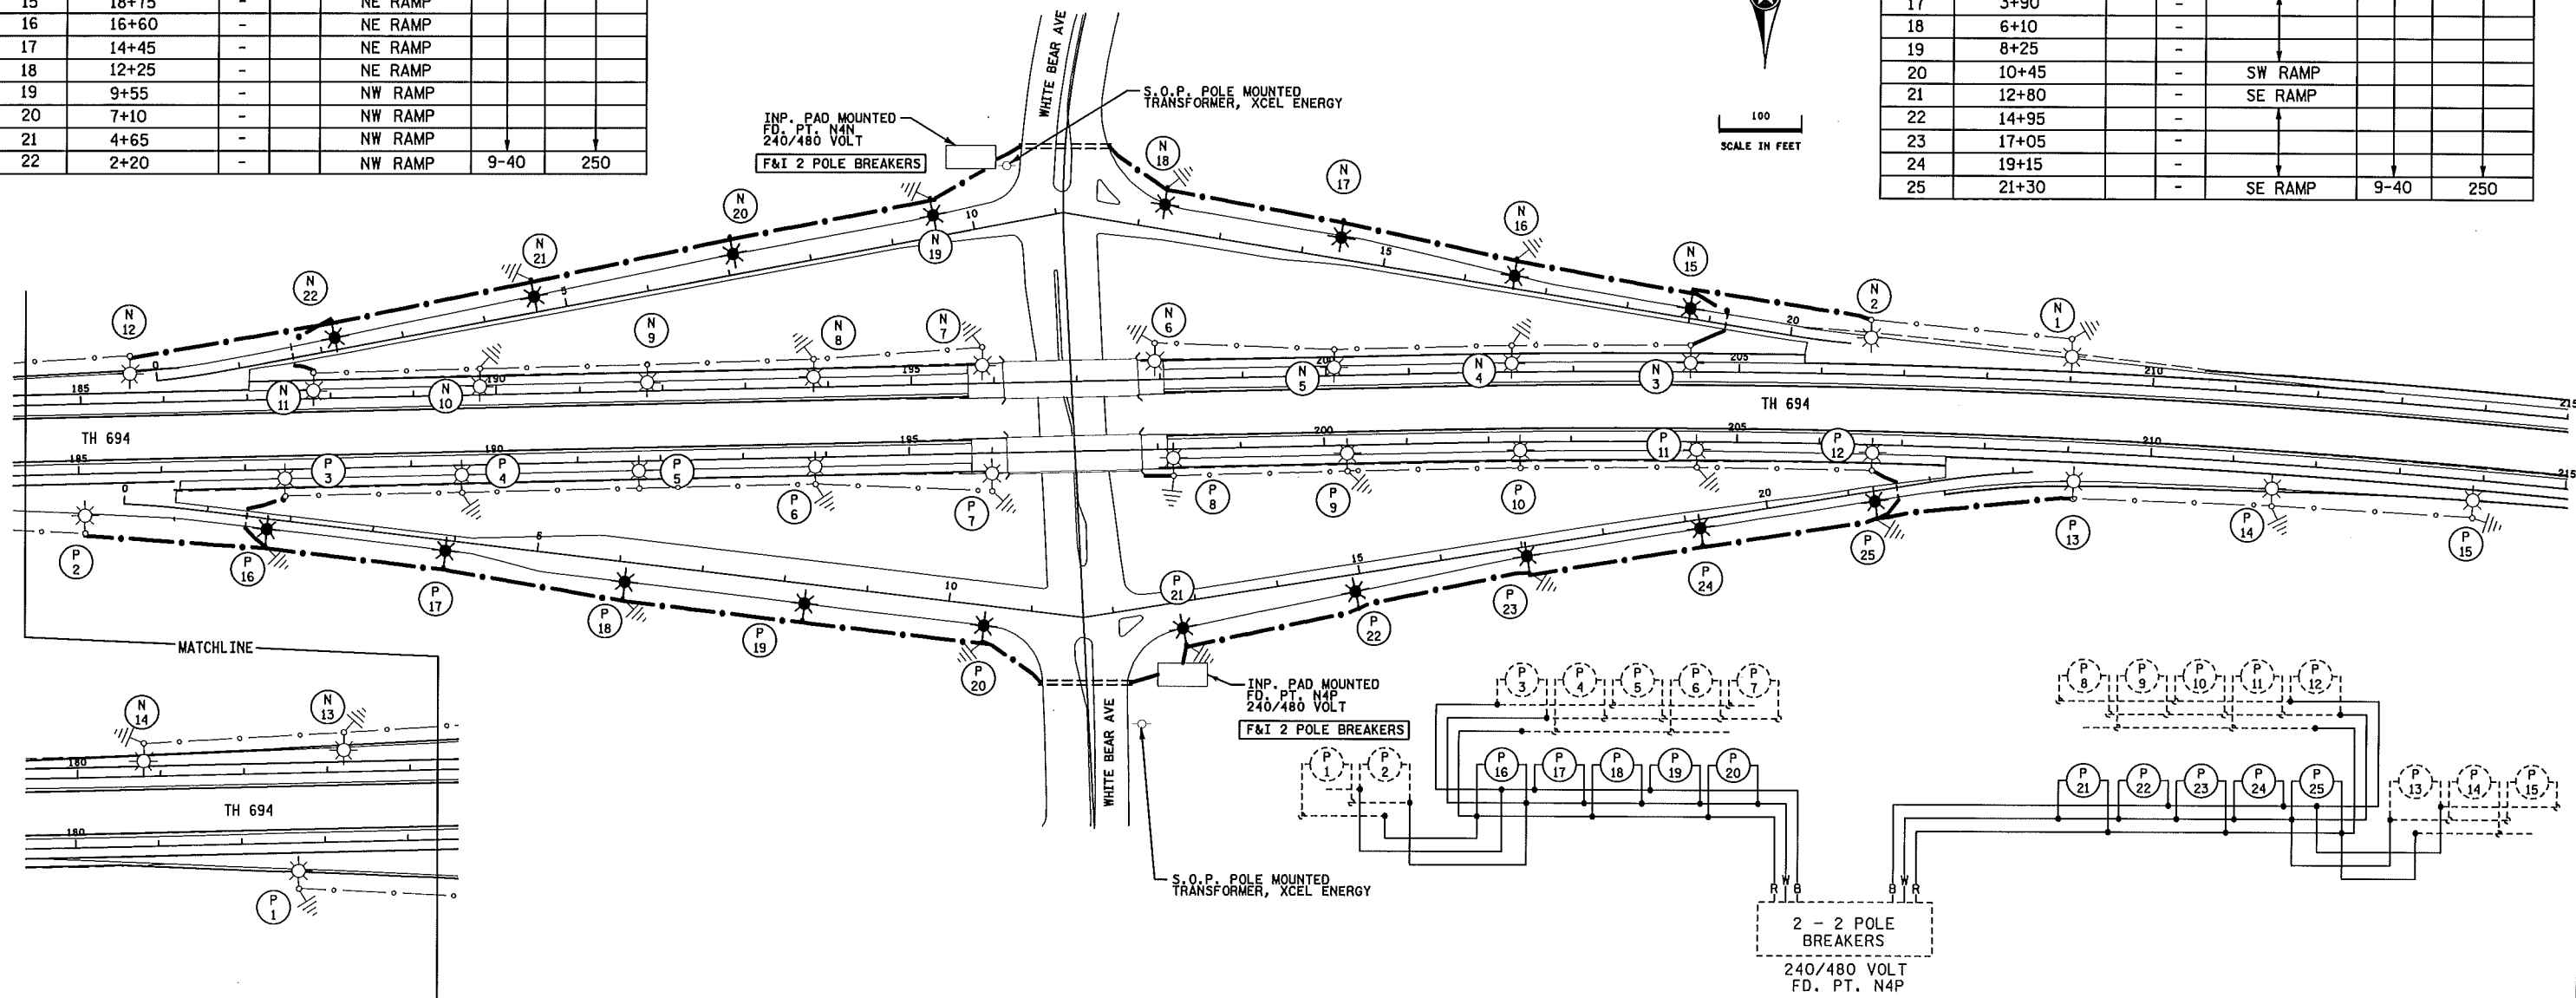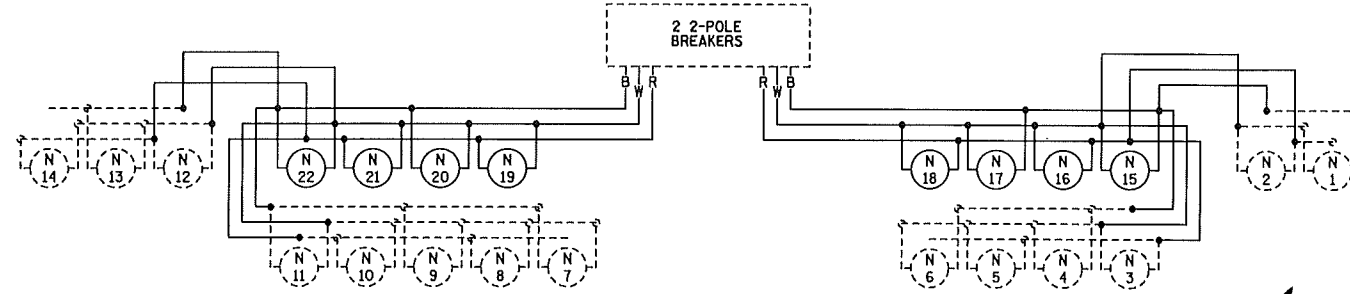

METER ADDRESS: N4N 3201 WHITE BEAR AVE N, WHITE BEAR LAKE, 55110
 METER ADDRESS: N4P 3189 WHITE BEAR AVE N, MAPLEWOOD 55109

DASHED LINES DENOTE INPLACE ITEMS
 W DENOTES NEUTRAL CONDUCTOR
 B AND R DENOTE CURRENT CARRYING CONDUCTORS

PLOTTED/REVISED: 2/21/2013

DISTRICT #: METRO
 IPLOT NAME: 16286-55/1012
 PATH & FILENAME: IP_PWP-d151599\6286-55\1.dgn

BY	DATE	REVISIONS	FEEDPOINT: N4N & N5P	LOCATION: T.H. 694 & White Bear Ave	LIGHTING PLAN
			METER ADDRESS: SEE ABOVE		
DRAWN BY: PB CKD BY: GB DATE: 2/2013			CERTIFIED BY: <i>Michael P. Dubinsky</i>	LIC. NO. 19863 DATE: 2/21/2013	STATE PROJ. NO. 6286-55 (T.H. 694) SHEET NO. 10 OF 11 SHEETS