


SEE LEGEND SHEET 7

PLOTTED/REVISED: 5/19/2011

DISTRICT #: METRO
 IPLOT NAME: 16286-5611
 PATH & FILENAME: IP_PWP-d\137186-4\6286-56.dgn

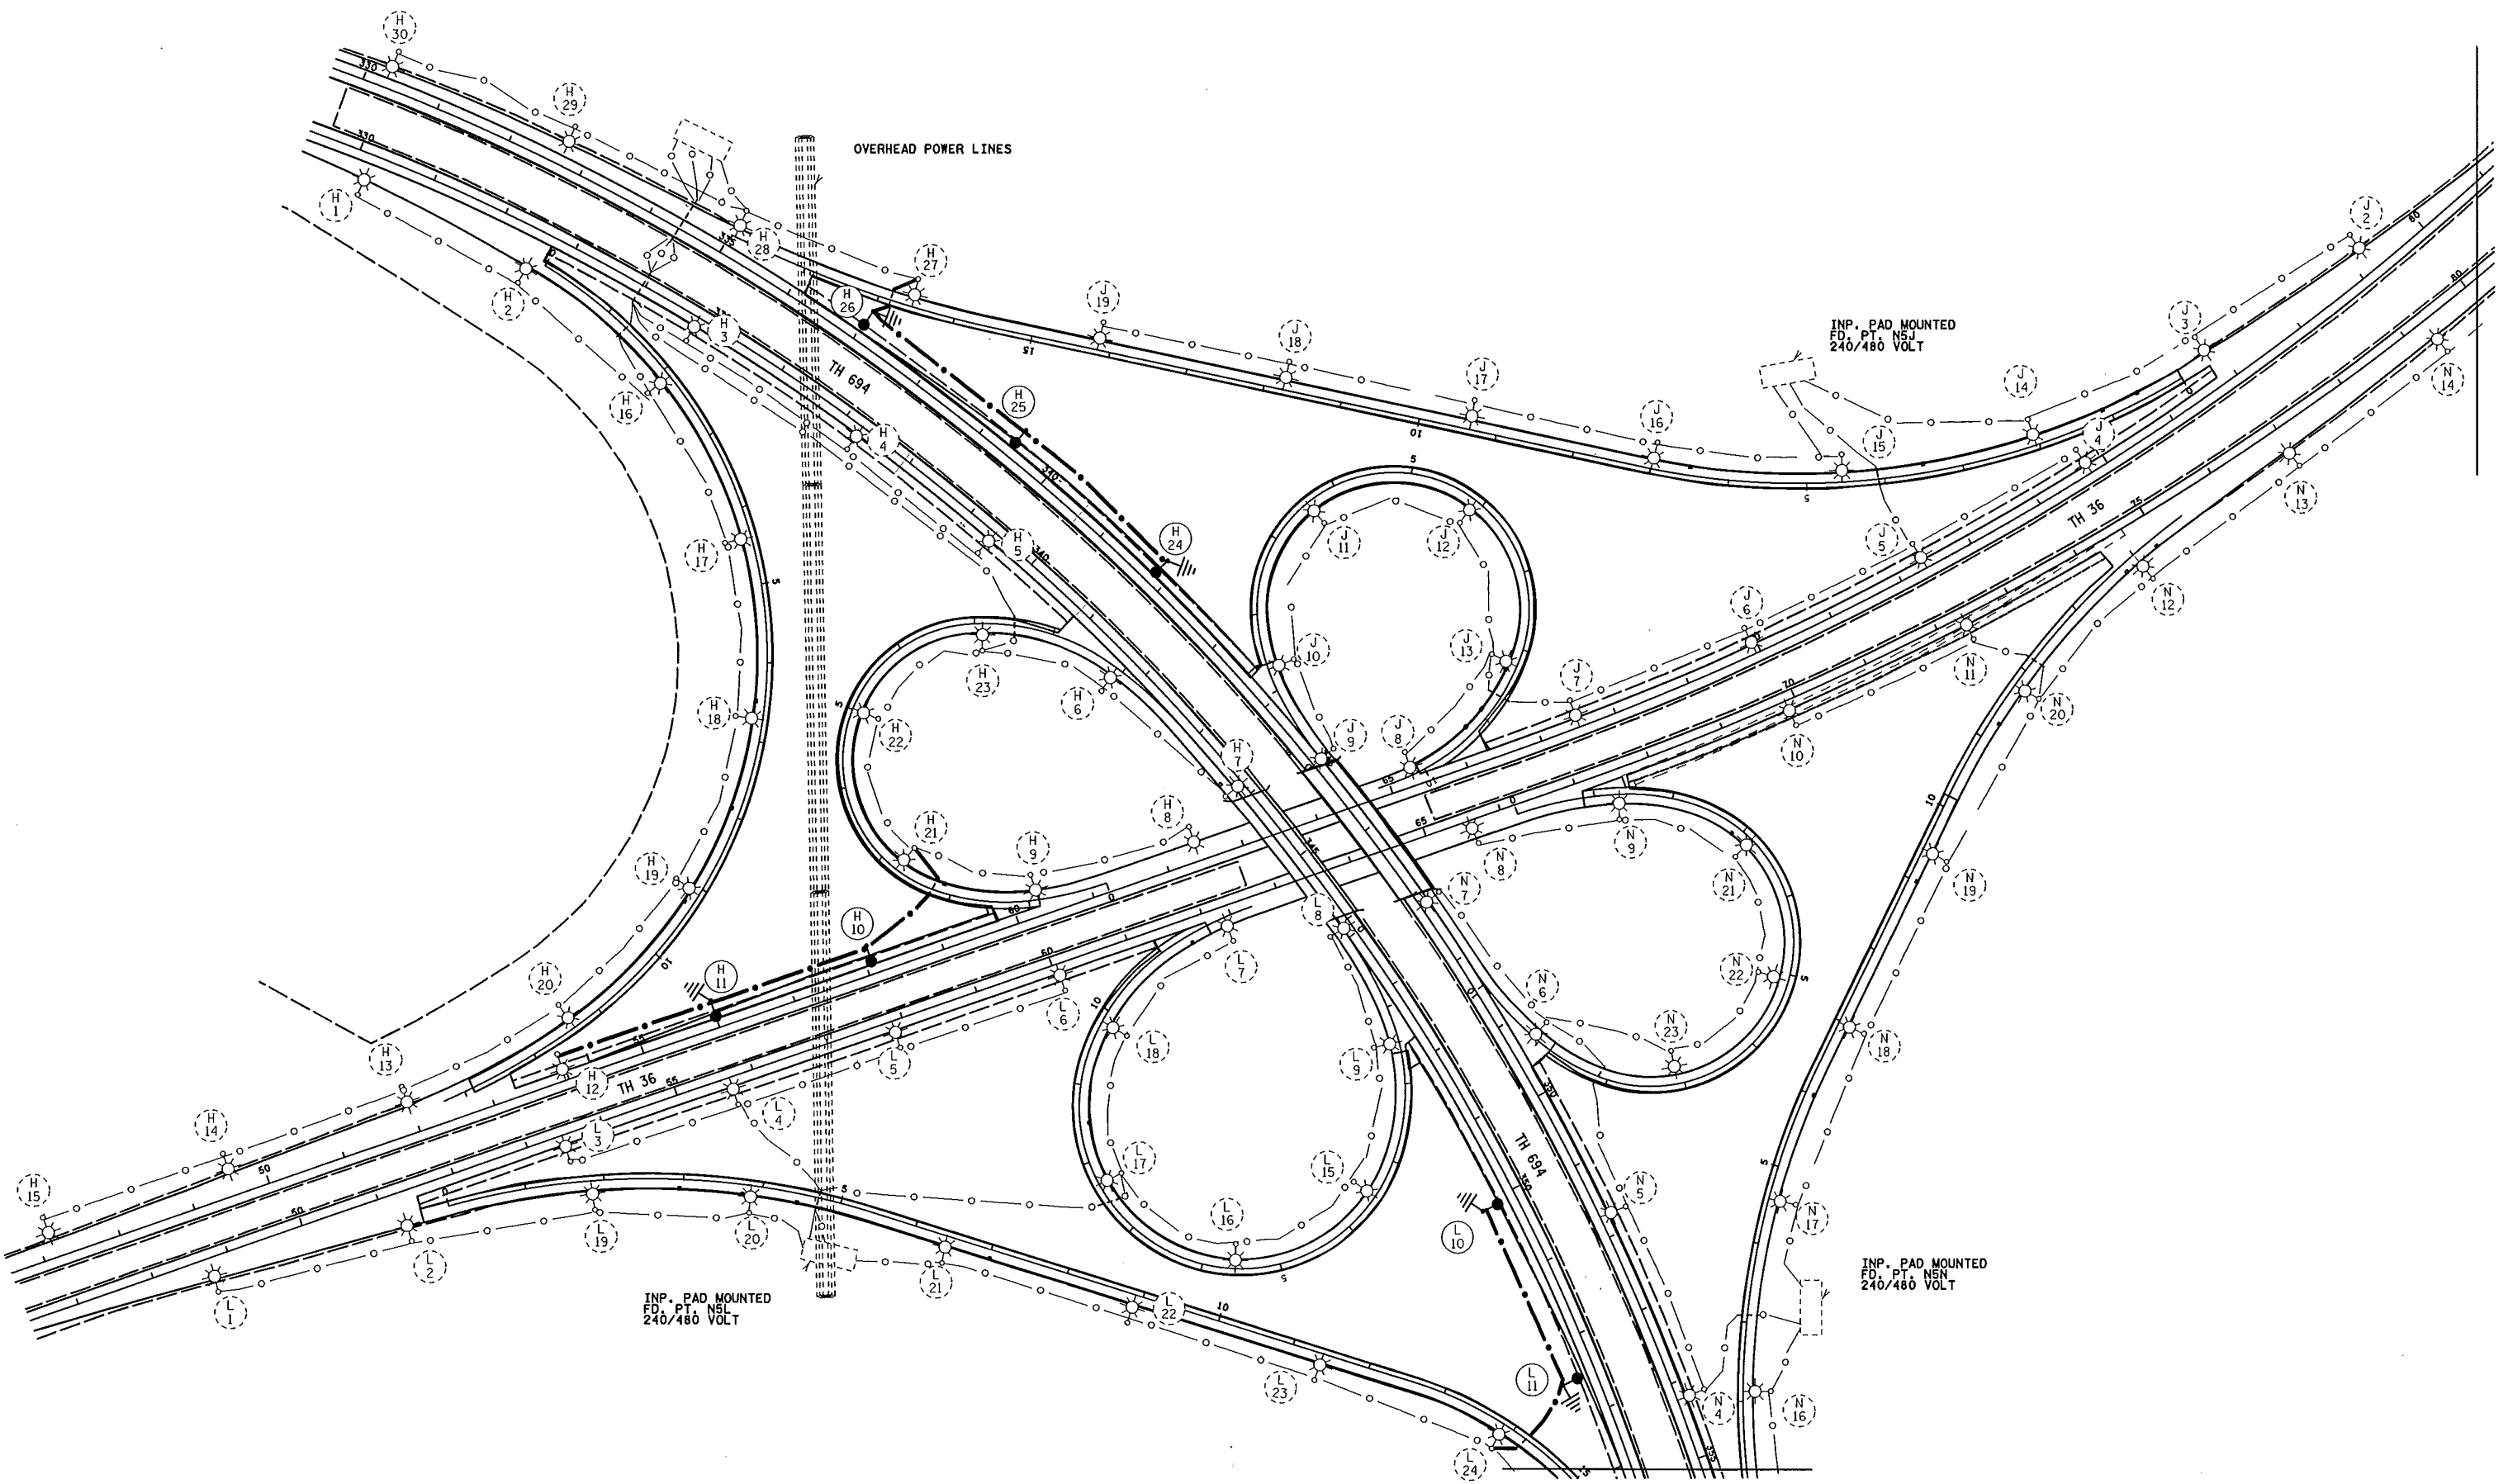

BY	DATE	REVISIONS	FEEDPOINT: N5H, N5J, N5L, & N5N	LOCATION: T.H. 694 & T.H. 36.	LIGHTING PLAN
			METER ADDRESS:		
DRAWN BY: PB	CKD BY: GB	DATE:	CERTIFIED BY: <i>Michael P. Libinsky</i>	LIC. NO. 19863	DATE: 5/19/2011
			STATE PROJ. NO. 6286-56 (T.H. 694)		SHEET NO. L11 OF L11 SHEETS