
 

 







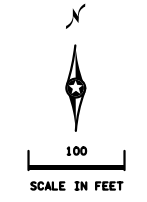
PLOTTED/REVISED: 2/13/2017

LEGEND

-  LIGHTING UNIT
-  INPLACE LIGHTING UNIT
-  UNDERPASS LIGHT
-  PERMANENT GROUND ROD (25 OHMS OR LESS)
-  DIRECT BURIED CABLE 4 CONDUCTOR NO. 4
-  FD. PT. CABINET
-  3" PVC (UNLESS OTHERWISE NOTED)
-  HANDHOLE
-  LIGHTING UNIT IDENTIFIER



FEEDPOINT P7X
LIGHTING UNIT LOCATION AND TYPE

NO.	STATION	LT.	RT.	LOCATION	TYPE
29	11+20		X	RAMP A	9-40 LED
30	13+30		X		
31	15+30		X		
32	17+45		X	RAMP A	
33	56+40		X	RAMP B	
34	58+80		X		
35	61+30		X		
36	63+75		X		
37	66+20		X		
38	68+60		X	RAMP B	
39	2+55		X	RAMP C	
40	4+95		X		
41	7+30		X		
42	9+65		X		
43	12+00		X	RAMP C	
44	14+60		X	RAMP D	
45	17+10		X	RAMP D	
46	19+50		X	RAMP D	9-40 LED



FEEDPOINT P7X
LIGHTING UNIT LOCATION AND TYPE

NO.	STATION	LT.	RT.	LOCATION	TYPE
1				MEDIAN	6BD-40 LED
2				MEDIAN	
3				MEDIAN	
4				MEDIAN	
5				MEDIAN	
6				MEDIAN	6BD-40 LED
7				MEDIAN	
13	810+15	X		T.H.12 EB	9-49 LED
14	812+15	X			
15	814+45	X			
16	816+65	X			
17	818+85	X			
18	821+65	X			
19	824+45	X			9-49 LED
20	825+90	X		T.H.12 EB	L LED
21	825+78	X		T.H.12 WB	L LED
22	824+40	X			9-49 LED
23	822+10	X			
24	819+80	X			
25	817+40	X			
26	815+20	X			
27	812+90	X			
28	810+40	X		T.H.12 EB	9-49 LED

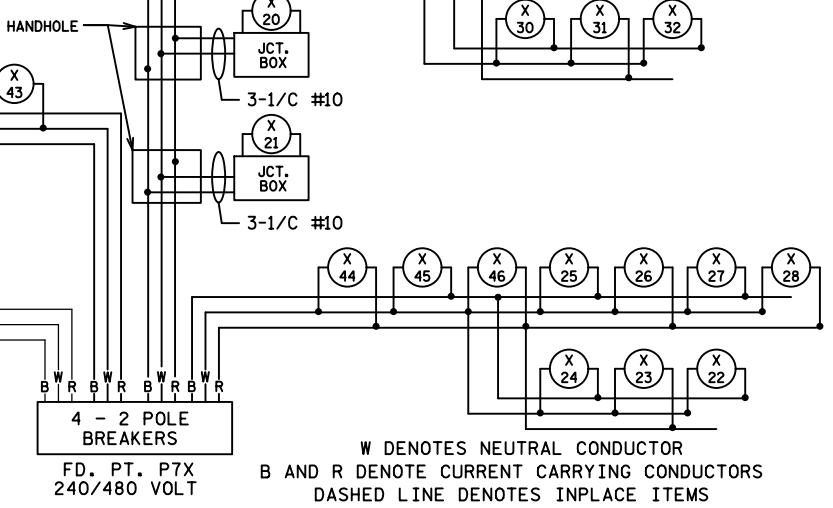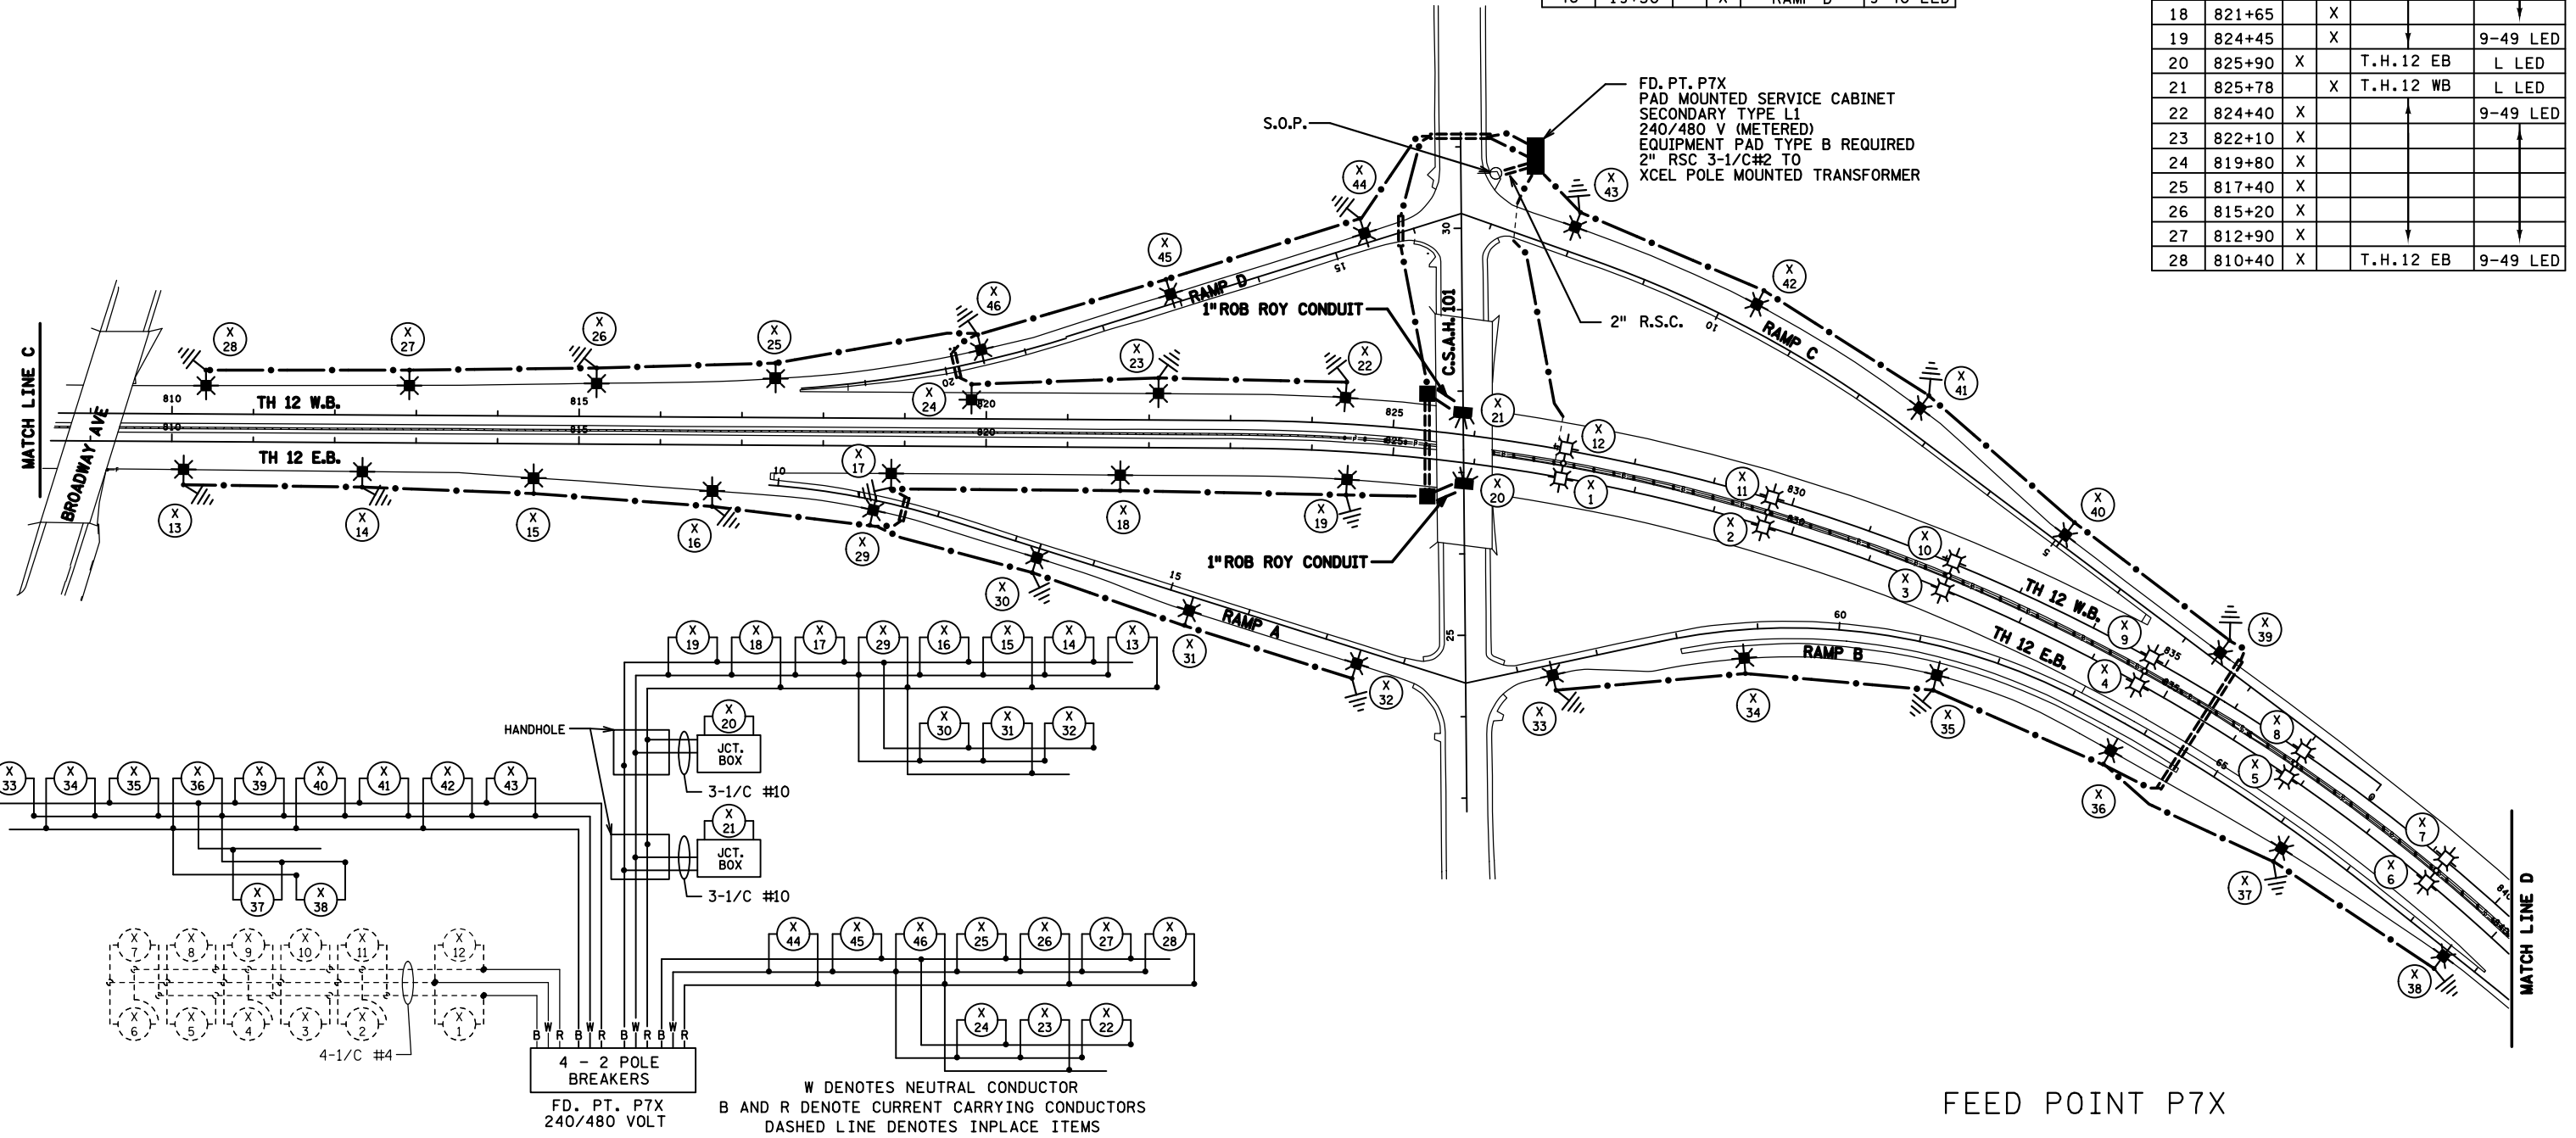

BY	DATE	REVISIONS	FEEDPOINT: P7X	LOCATION: (101) W. JCT	LIGHTING PLAN
TL	2/13/17	ASBUILT CONSTRUCTION PLAN	METER ADDRESS: 380 CENTRAL AVE, WAYZATA 55391		
DRAWN BY: SJK CKD BY: PB			CERTIFIED BY <i>Michael P. Libinsky</i> LIC. NO. 19863 DATE: 2/13/2017		STATE PROJ.NO. 2713-112 (T.H. 12) SHEET NO. 13 OF 18 SHEETS

DISTRICT #: METRO
PLOT NAME: 12713-112.lit.ab7
PATH & FILENAME: IP_PWP-d17-49652V2713-112.lit.ab.dgn