

 

 






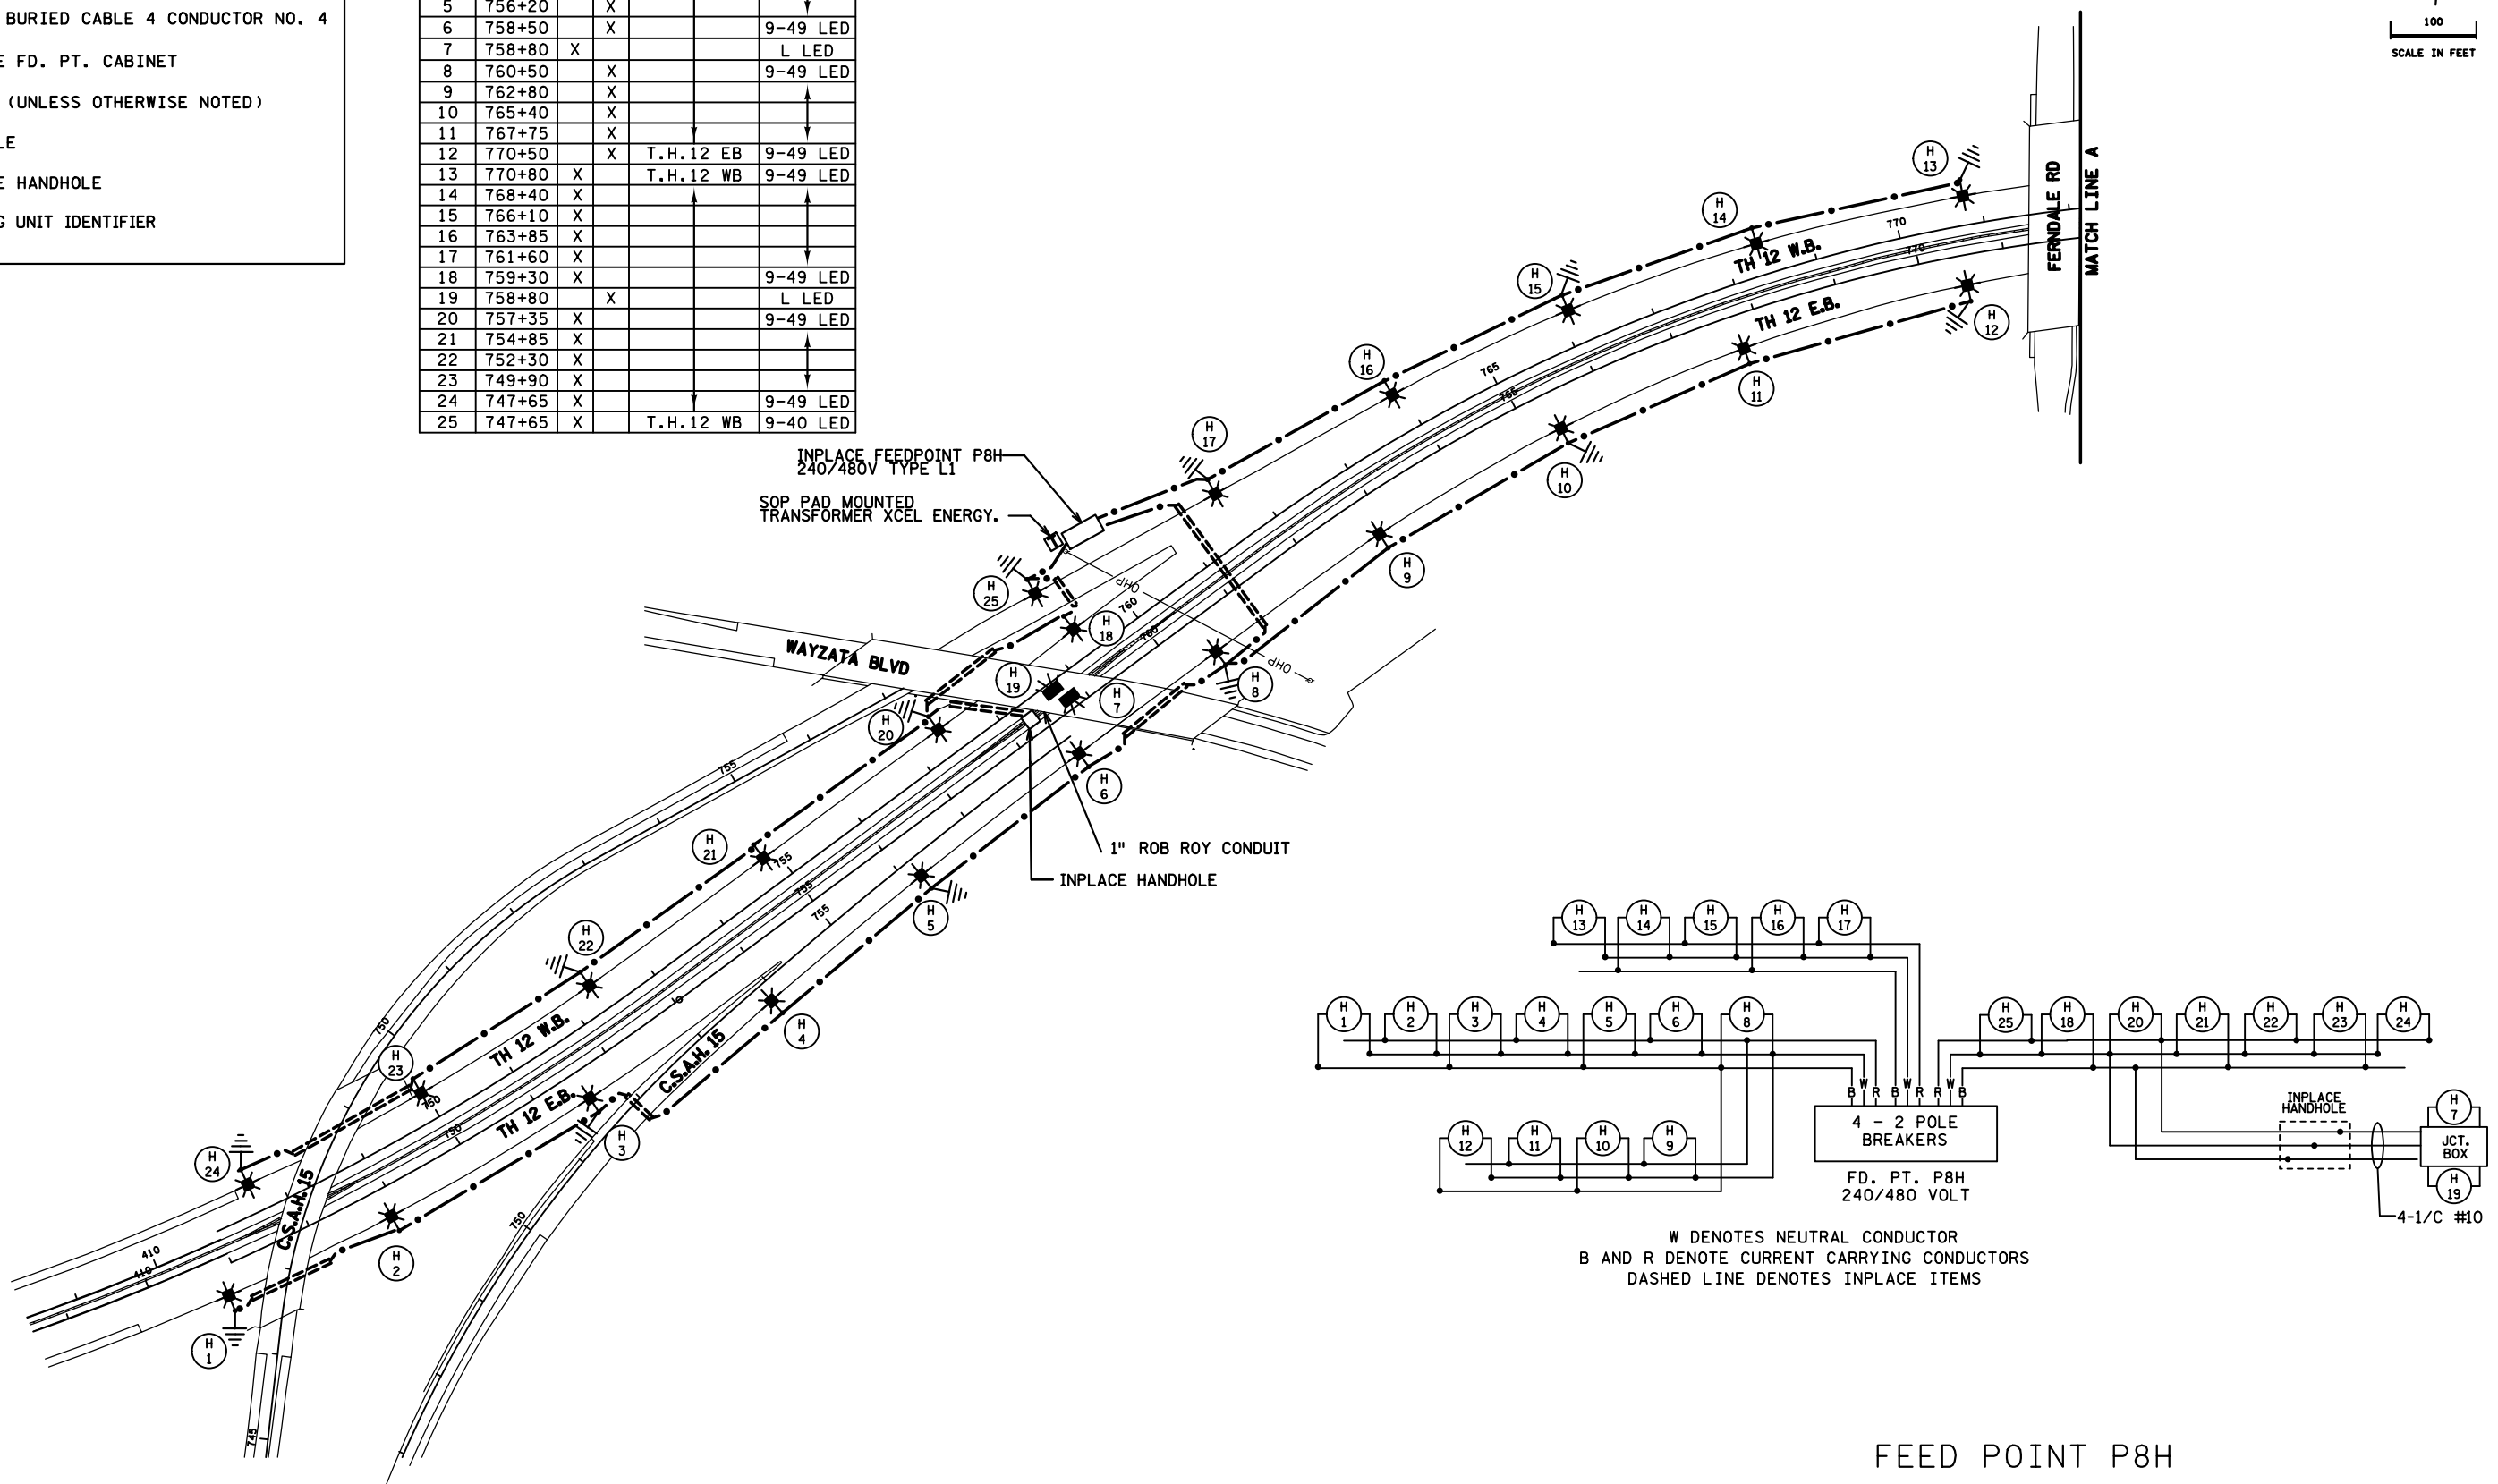
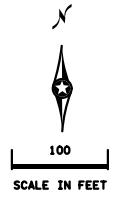
PLOTTED/REVISED: 2/13/2017

DISTRICT #: METRO
 PLOT NAME: 12713-112.ltr.ab5
 PATH & FILENAME: IP_PWP-d1749652v2713-112.ltr.ab.dgn

LEGEND

-  LIGHTING UNIT
-  UNDERPASS LIGHT
-  PERMANENT GROUND ROD (25 OHMS OR LESS)
-  DIRECT BURIED CABLE 4 CONDUCTOR NO. 4
-  INPLACE FD. PT. CABINET
-  3" PVC (UNLESS OTHERWISE NOTED)
-  HANDHOLE
-  INPLACE HANDHOLE
-  LIGHTING UNIT IDENTIFIER

FEEDPOINT P8H				
LIGHTING UNIT LOCATION AND TYPE				
NO.	STATION	LT.	RT.	LOCATION
1	410+80		X	T.H.12 EB
2	748+90		X	
3	751+60		X	
4	753+90		X	
5	756+20		X	
6	758+50		X	9-49 LED
7	758+80	X		L LED
8	760+50	X		9-49 LED
9	762+80	X		
10	765+40	X		
11	767+75	X		
12	770+50	X		T.H.12 EB
13	770+80	X		T.H.12 WB
14	768+40	X		
15	766+10	X		
16	763+85	X		
17	761+60	X		
18	759+30	X		9-49 LED
19	758+80	X		L LED
20	757+35	X		9-49 LED
21	754+85	X		
22	752+30	X		
23	749+90	X		
24	747+65	X		9-49 LED
25	747+65	X		T.H.12 WB



FEED POINT P8H

BY	DATE	REVISIONS	FEEDPOINT: P8H	LOCATION: (15) W. JCT. WAYZATA	LIGHTING PLAN
TL	2/13/17	CONSTRUCTION ASBUILT	METER ADDRESS: 300 WAYZATA BLVD W., WAYZATA 55391		
DRAWN BY: SJK CKD BY: PB			CERTIFIED BY <i>Michael P. Libinsky</i>	LIC. NO. 19863 DATE: 2/13/2017	STATE PROJ.NO. 2713-112 (T.H. 12) SHEET NO. 11 OF 18 SHEETS