

PLOTTED/REVISED: 16-JUL-2018

DISTRICT #: Metro
 IPLOT NAME: 12774-23.lit.lo
 PATH & FILENAME: Projects\DM罗斯062\2774-23\TrafficLighting\2774-23.lit lodgn


LEGEND

- INSTALL SALVAGED LIGHTING UNIT
- INSTALL SALVAGED UNDERPASS LIGHT
- DIRECT BURIED LIGHTING CABLE 4/C 4 AWG
- GROUND ROD
- INPLACE LIGHTING UNIT
- INPLACE FD. PT. CABINET
- INPLACE HANDHOLE
- LIGHTING UNIT IDENTIFIER
- INPLACE DIRECT BURIED LIGHTING CABLE
- INPLACE CONDUIT


FEEDPOINT R02H
 LIGHTING UNIT LOCATION AND TYPE

NO.	STATION	LT.	RT.	LOCATION	TYPE	FOUNDATION
5	4188+45		X	EB TH 62	L	-
6	4188+55	X		WB TH 62	L	-
13	19+75	X		FRANCE 62 W	9-40	E

DASHED LINES DENOTE INPLACE ITEMS
 W DENOTES NEUTRAL CONDUCTOR
 B AND R DENOTE CURRENT CARRYING CONDUCTORS

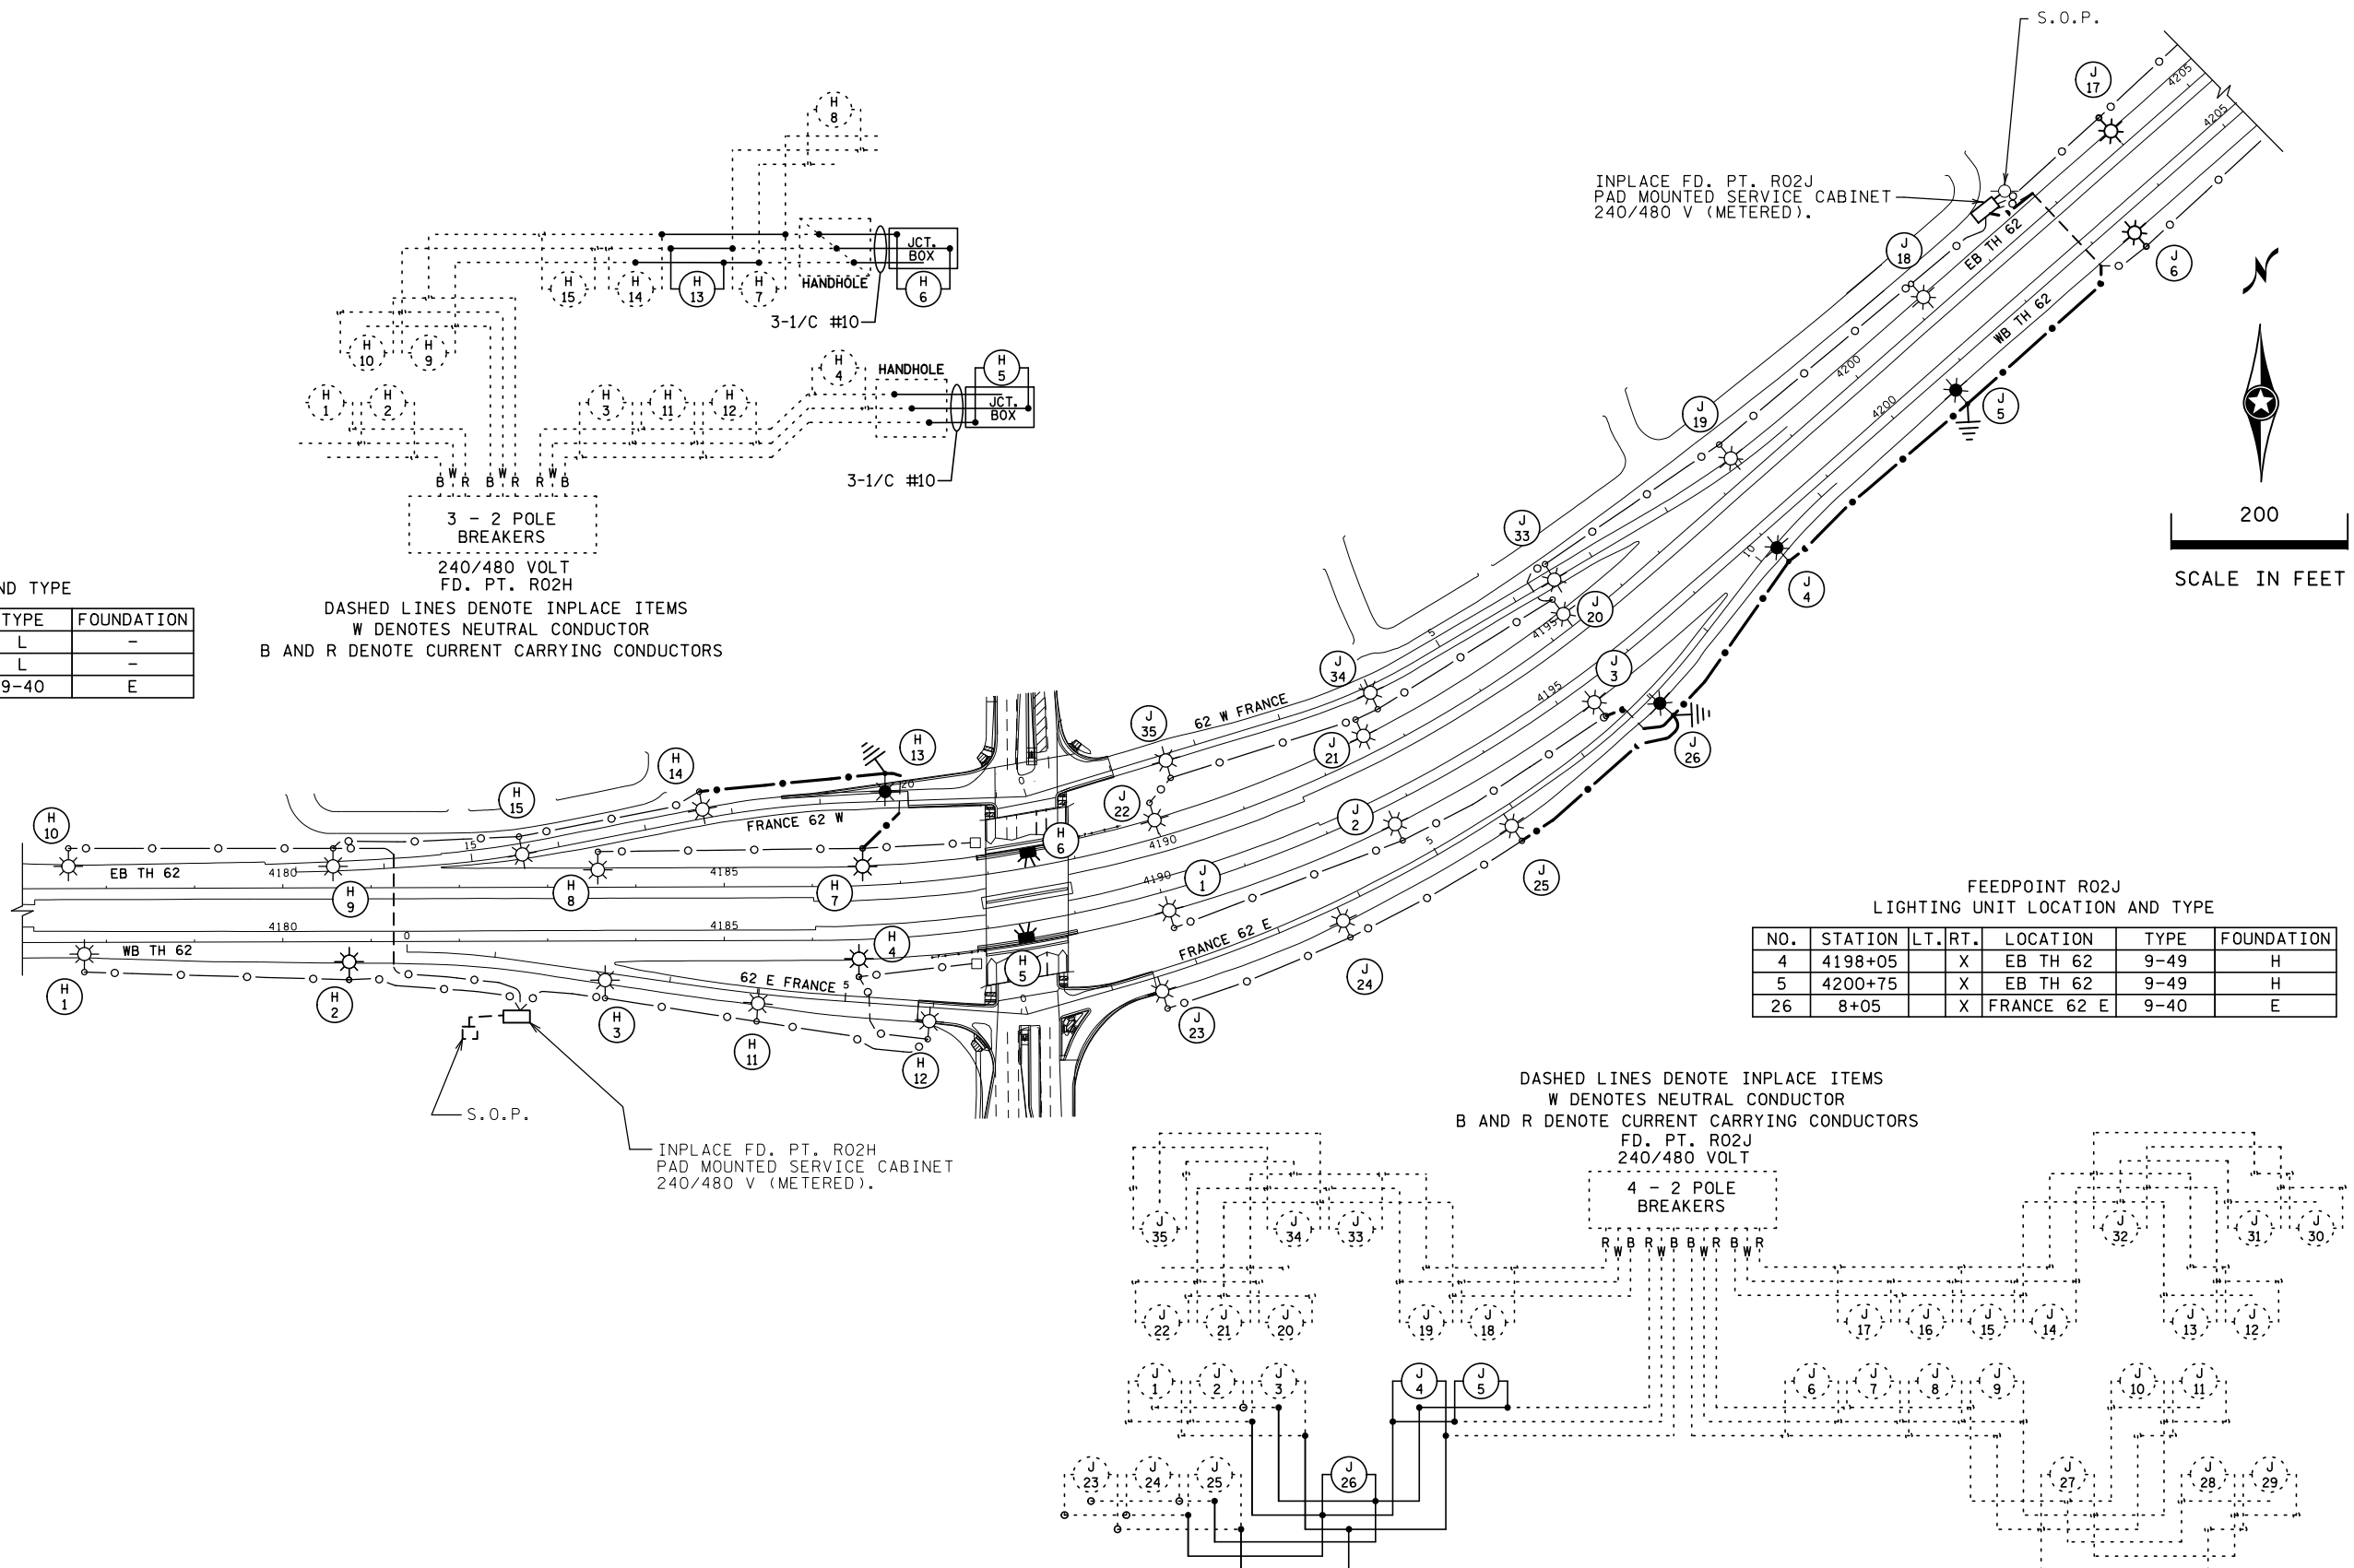

 INPLACE FD. PT. R02J
 PAD MOUNTED SERVICE CABINET
 240/480 V (METERED).



FEEDPOINT R02J
 LIGHTING UNIT LOCATION AND TYPE

NO.	STATION	LT.	RT.	LOCATION	TYPE	FOUNDATION
4	4198+05	X		EB TH 62	9-49	H
5	4200+75	X		EB TH 62	9-49	H
26	8+05	X		FRANCE 62 E	9-40	E

DASHED LINES DENOTE INPLACE ITEMS
 W DENOTES NEUTRAL CONDUCTOR
 B AND R DENOTE CURRENT CARRYING CONDUCTORS
 FD. PT. R02J
 240/480 VOLT

FEEDPOINT: R02H LOCATION: FRANCE AVENUE SOUTH
 METER ADDRESS: 4001 HIGHWAY 62 SOUTH, RICHFIELD, MN 55423

FEEDPOINT: R02J LOCATION: XERXES AVENUE SOUTH
 METER ADDRESS: 3350 HIGHWAY 62 SOUTH, RICHFIELD, MN 55423

CERTIFIED BY Michael P. Lubensky LIC. NO. 19863 DATE: 16-JUL-2018
LICENSED PROFESSIONAL ENGINEER

LIGHTING PLAN

BY	DATE	REVISIONS

DRAWN BY: JC CKD BY: PB