



**LEGEND**

- DIRECT BURIED CABLE 4/C 4 AWG
- ≡≡≡ 3" PVC (UNLESS OTHERWISE NOTED)
- HANDHOLE
- INPLACE TOWER LIGHTING
- INPLACE UNDERPASS LIGHT
- ⊥ PERMANENT GROUND ROD (25 OHMS OR LESS)
- INPLACE FT. PT. CABINET
- INPLACE HANDHOLE
- ⊗ LIGHTING UNIT IDENTIFIER
- INPLACE DIRECT BURIED CABLE
- - - INPLACE CONDUIT

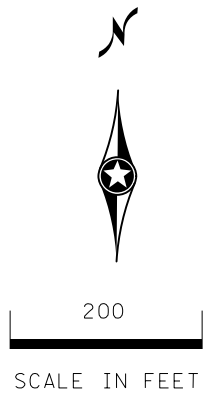

PLOTTED/REVISED: 29-JUL-2019

DISTRICT #: Metro  
 I/PLOT NAME: sheet 9  
 PATH & FILENAME: Projects\DM\_R05\005\2732\05\T\Traffic\Lighting\2732-105\lit.lodgn

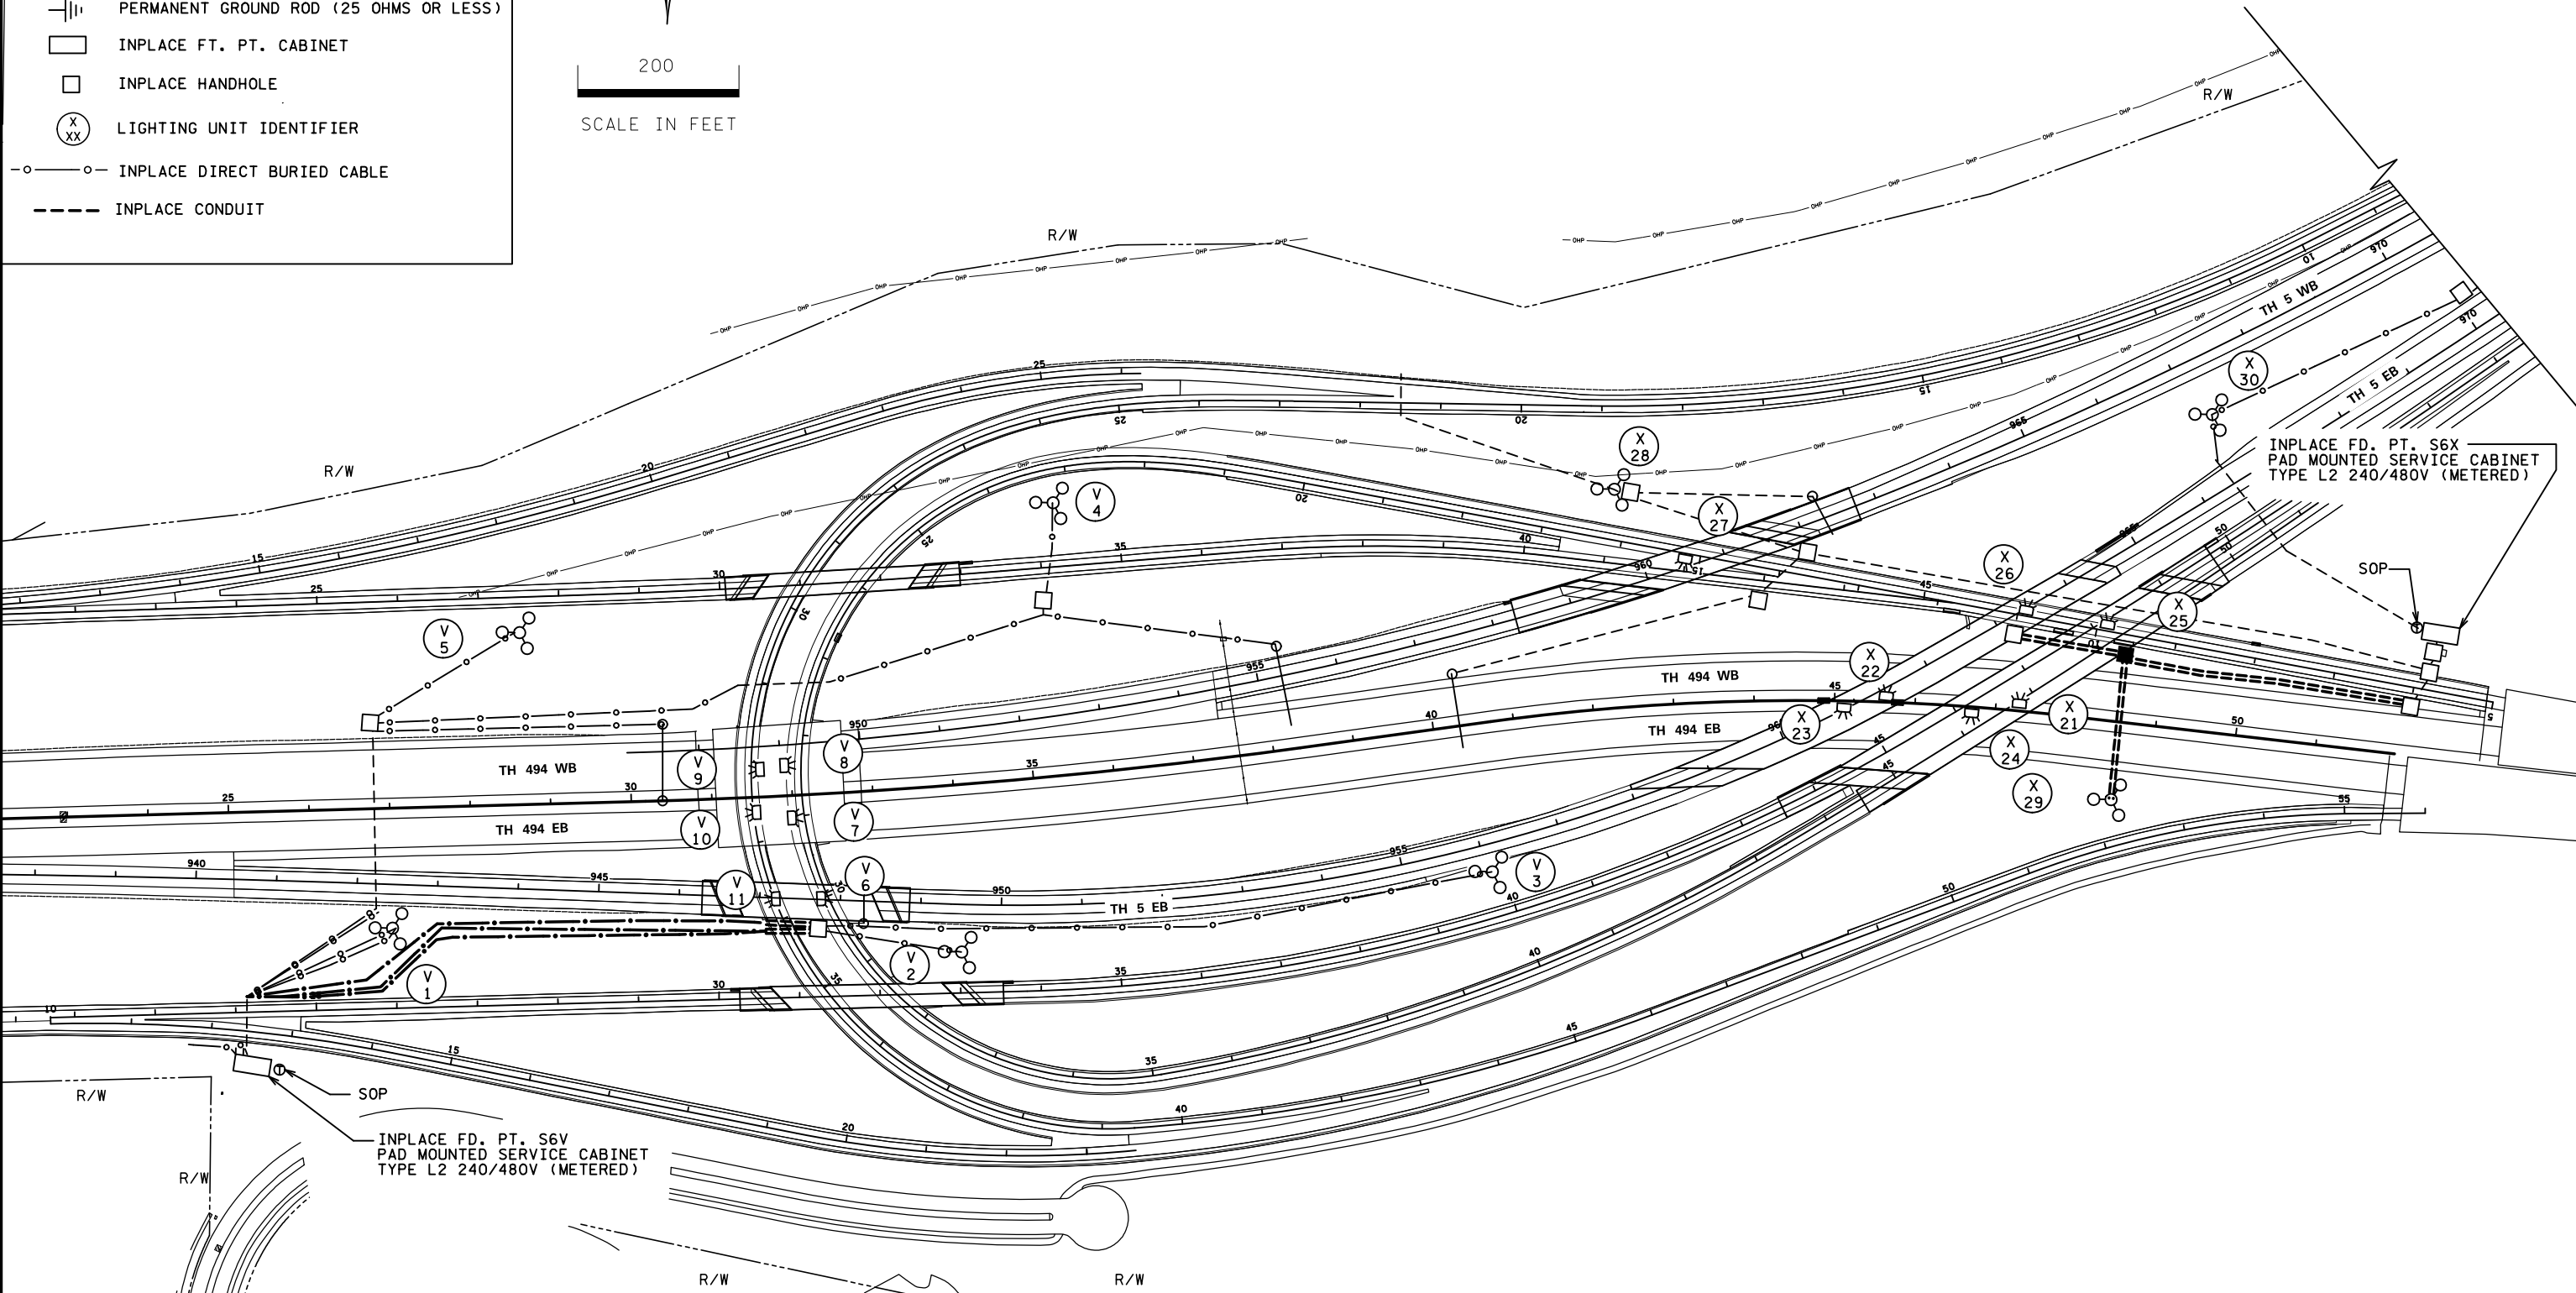

METER ADDRESS: S6X 4891 HWY 5 FORT SNELLING, 55450  
 S6V 3701E 79TH ST BLOOMINGTON, 55425

FEEDPOINT: S6X,S6V LOCATION: TH 5

LIGHTING SYSTEM A

BY	DATE	REVISIONS

CERTIFIED BY *Michael P. Dubinsky* LIC. NO. 19863 DATE: 29-JUL-2019  
LICENSED PROFESSIONAL ENGINEER

**LIGHTING PLAN**


STATE PROJ.NO. 2732-105 (T.H. 5) SHEET NO. SL9 OF SL13 SHEETS

DRAWN BY: BAM CKD BY: PB


PLOTTED/REVISED: 29-JUL-2019

DISTRICT #: Metro  
PLOT NAME: sheet 10  
PATH & FILENAME: Projects\DM\_R05\005\2732\05\Traffic\Lighting\2732-105.lht.dgn

DASHED LINES DENOTE INPLACE ITEMS  
W DENOTES NEUTRAL CONDUCTOR  
B AND R DENOTE CURRENT CARRYING CONDUCTORS  
FD. PT. S6V  
240/480 VOLT

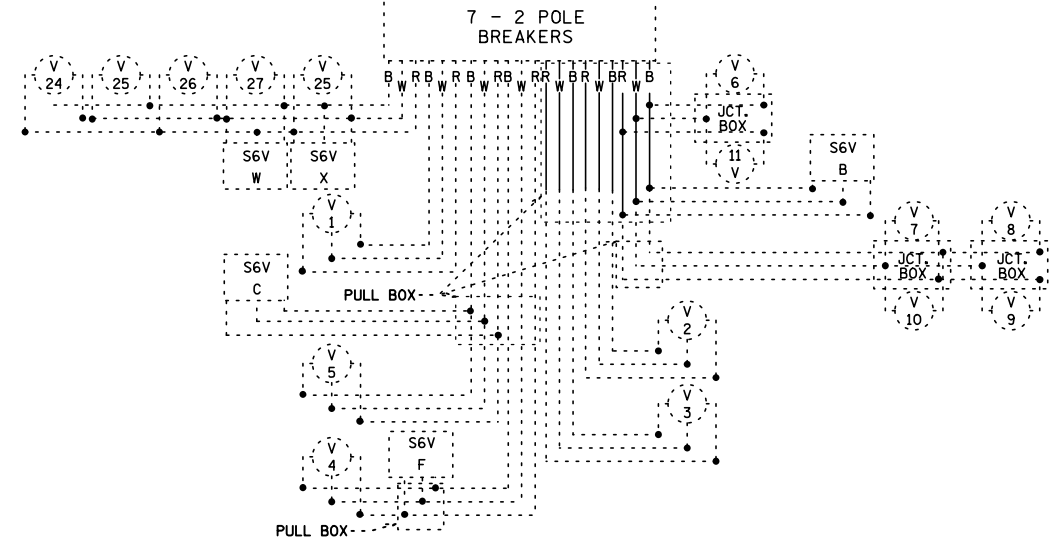

DASHED LINES DENOTE INPLACE ITEMS  
W DENOTES NEUTRAL CONDUCTOR  
B AND R DENOTE CURRENT CARRYING CONDUCTORS  
FD. PT. S6X  
240/480 VOLT

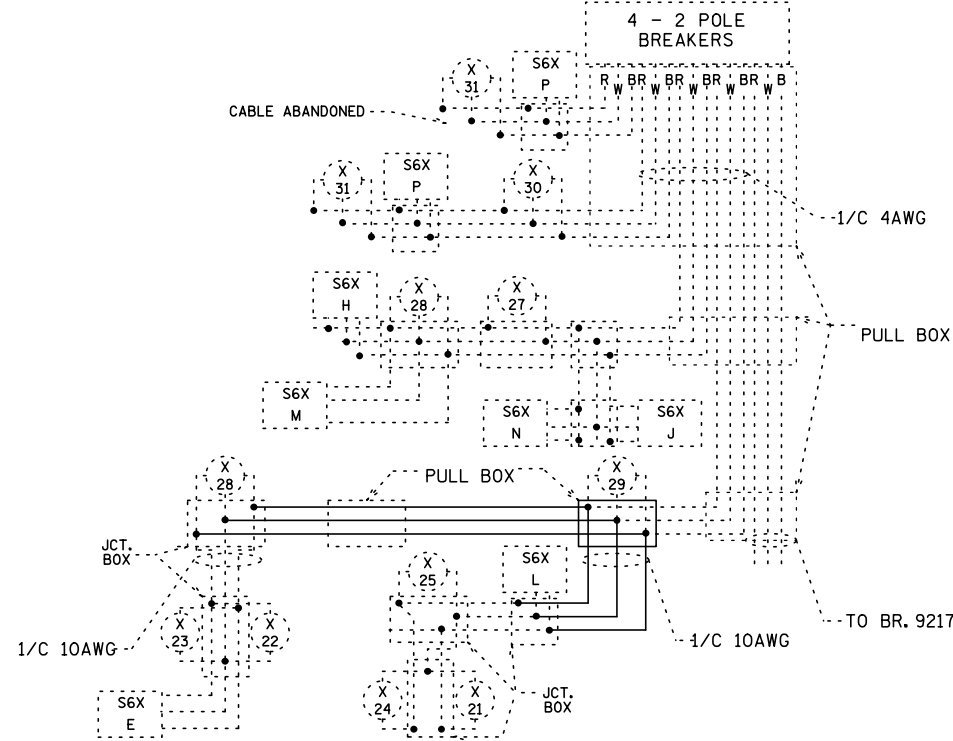

METER ADDRESS: S6X 4891 HWY 5 FORT SNELLING, 55450  
S6V 3701E 79TH ST BLOOMINGTON, 55425

LIGHTING SYSTEM A

BY	DATE	REVISIONS

FEEDPOINT: S6X, S6V		LOCATION: TH 5
CERTIFIED BY	<i>Michael P. Lubinsky</i>	LIC. NO. 19863
	LICENSED PROFESSIONAL ENGINEER	DATE: 29-JUL-2019

<b>LIGHTING PLAN</b>	
STATE PROJ.NO. 2732-105 (T.H. 5)	SHEET NO. SL10 OF SL13 SHEETS

DRAWN BY: BAM CKD BY: PB