


B AND R DENOTE CURRENT CARRYING CONDUCTORS
W DENOTES NEUTRAL CONDUCTOR

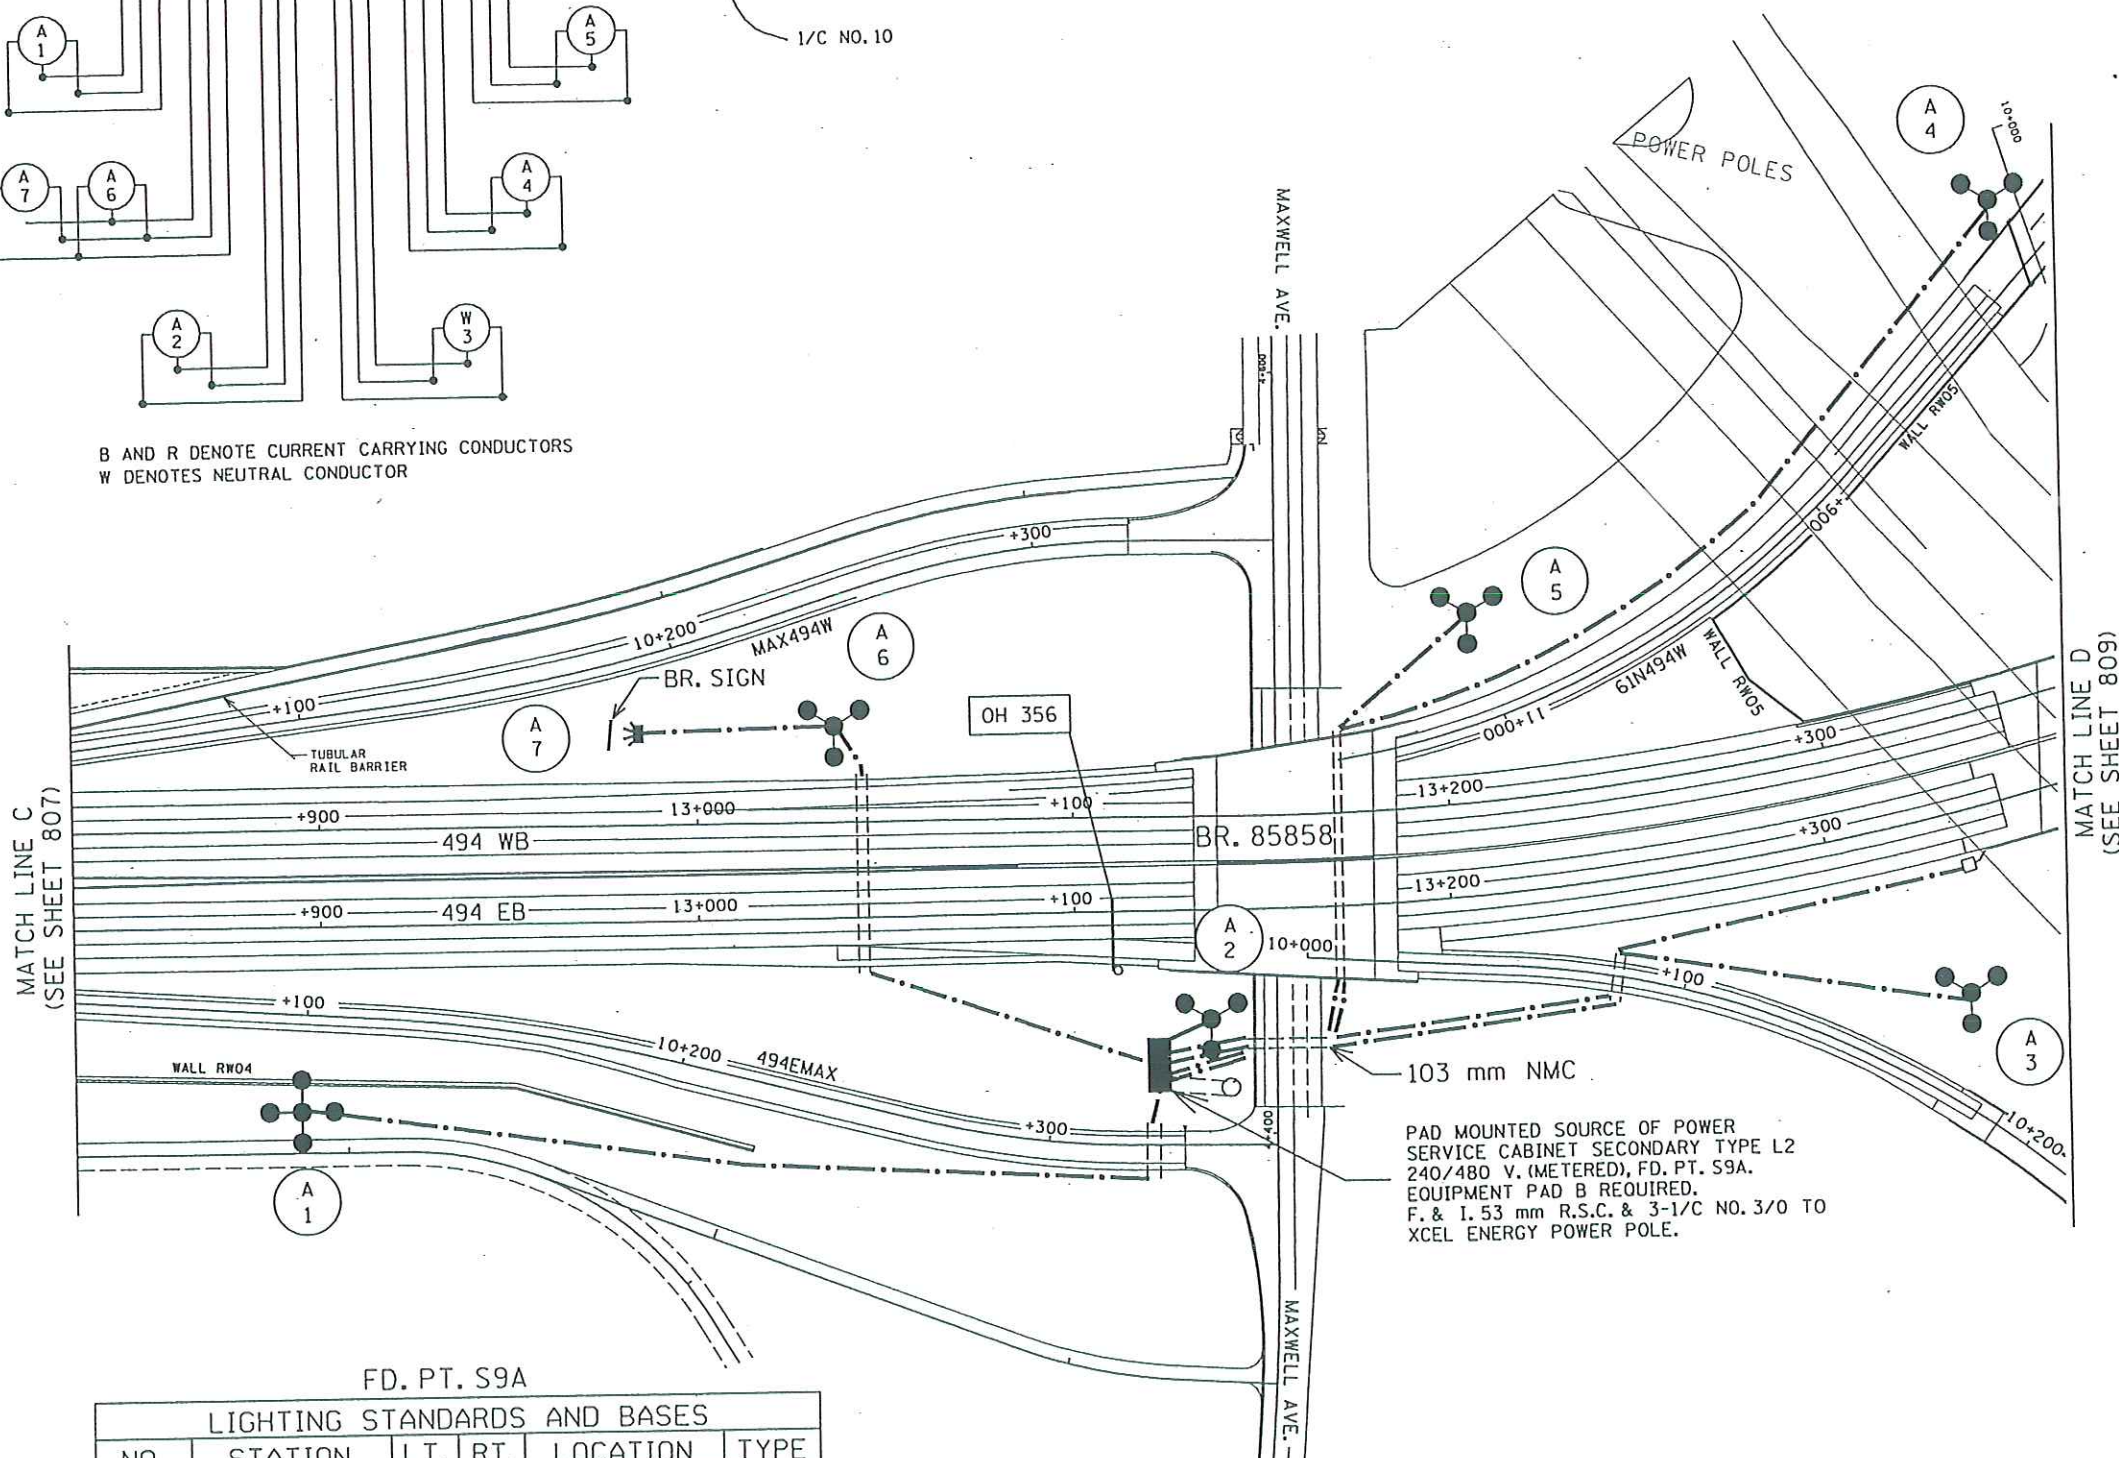

FD. PT. S9A

LIGHTING STANDARDS AND BASES

NO.	STATION	L.T.	RT.	LOCATION	TYPE
(7) 1	10+100		26m	RAMP 494EMAX	4-36.5
2	13+134		34m	T.H. 494 E.B.L.	3-36.5
3	13+328		47m	T.H. 494 E.B.L.	3-30.5
4	10+809		19m	RAMP 61N494W	3-30.5
5	11+000		28m	RAMP 61N494W	3-30.5
6	13+036	25m		T.H. 494 W.B.L.	3-30.5
(5) 7	AS SHOWN	-		BR. SIGN	A

(5) PLACE FLOODLIGHT AS DIRECTED BY MANUFACTURER
(7) SHIELD HOUSE SIDE

CERTIFIED BY

Anna Dehner
LICENSED PROFESSIONAL ENGINEER

LIC. NO. 40945

State Proj. No. 8285-80 (T.H. 494)



LIGHTING PLAN

Sheet No. 808 of 980 Sheets