


LEGEND

- INSTALL SALVAGED LIGHTING UNIT & SALVAGED FOUNDATION
- DIRECT BURIED LIGHTING CABLE 4/C 4 AWG
- 3" NMC
- PERMANENT GROUND ROD (25 OHMS OR LESS)
- INPLACE LIGHTING UNIT
- INPLACE DIRECT BURIED LIGHTING CABLE
- INPLACE CONDUIT
- INPLACE SERVICE CABINET
- INPLACE HANDHOLE(HH)
- INPLACE UNDERPASS LUMINAIRE
- LIGHTING UNIT IDENTIFIER

SPECIFIC NOTE:
 ① EXTEND EXISTING CONDUIT UNDER NEW SIDEWALK.

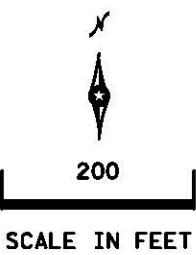

**FEEPPOINT T05A
LIGHTING UNIT LOCATION AND TYPE**

NO.	STATION	LT.	RT.	LOCATION	TYPE	FOUNDATION
1-10	INPLACE	X		WB TH36	9-49	H
11-12	INPLACE	X		NE RAMP	9-40	E
13	16+55	X		NE RAMP	9-40	E
14-15	INPLACE		X	NB FAIRVIEW	L	
16	102+73	X		NB FAIRVIEW	9-40	E
17	18+00	X		NE RAMP	9-40	E
18-19	INPLACE	X		NELoop	9-40	E
20-21	INPLACE	X		SB FAIRVIEW	L	

INPLACE FD. PT. T05A
SERVICE CABINET TYPE - L1
240/480V (METERED)

INPLACE FD. PT. T05C
SERVICE CABINET TYPE - L1
240/480V (METERED)

**FEEPPOINT T05C
LIGHTING UNIT LOCATION AND TYPE**



NO.	STATION	LT.	RT.	LOCATION	TYPE	FOUNDATION
1-11	INPLACE	X		EB36	9-49	H
12	INPLACE	X		SE LOOP	9-40	E
13	4+32	X		SE LOOP	9-40	E
14	97+86	X		NB FAIRVIEW	9-40	E
15	99+02	X		NB FAIRVIEW	9-40	E
16-17	INPLACE	X		NB FAIRVIEW	L	
18-19	INPLACE	X		SB FAIRVIEW	L	
20	95+58	X		NB FAIRVIEW	9-40	E
21	1+29	X		SE RAMP	9-40	E
22-23	INPLACE	X		SE RAMP	9-40	E

DASHED LINES DENOTE INPLACE ITEMS
 W DENOTES NEUTRAL CONDUCTOR
 B AND R DENOTE CURRENT CARRYING CONDUCTORS
 FD. PT. T05C
 240/480 VOLT

DASHED LINES DENOTE INPLACE ITEMS
 W DENOTES NEUTRAL CONDUCTOR
 B AND R DENOTE CURRENT CARRYING CONDUCTORS
 FD. PT. T05A
 240/480 VOLT

4 - 2 POLE BREAKERS

4 - 2 POLE BREAKERS

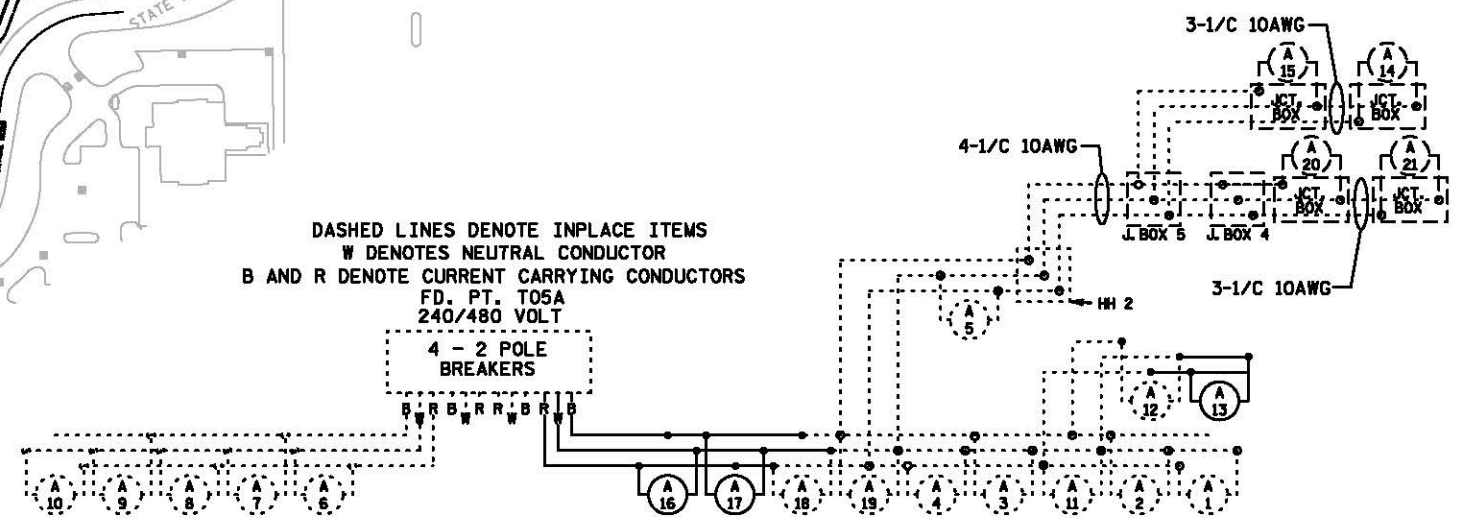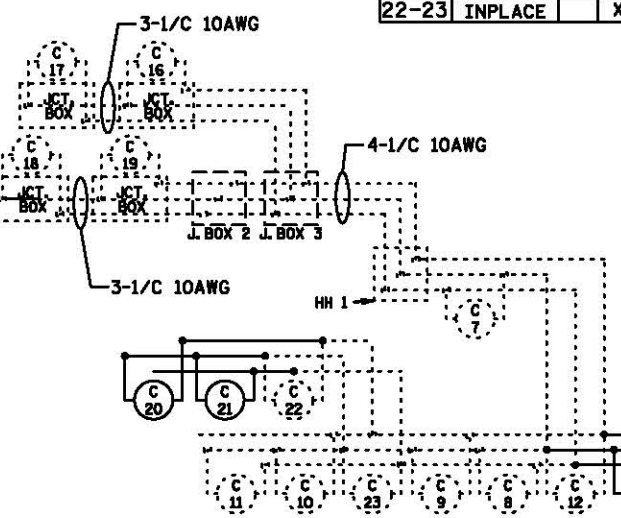

AS-BUILT

FEEPPOINT: T05A LOCATION: FAIRVIEW AVE
 METER ADDRESS: 2350 FAIRVIEW AVE ROSEVILLE, 55113

SAP 062-648-023, 160-020-047

FEEPPOINT: T05C LOCATION: FAIRVIEW AVE
 METER ADDRESS: 2250 FAIRVIEW AVE N. ROSEVILLE, 55113

LIGHTING PLAN

BY	DATE	REVISIONS
JU	1-1-24	REMOVED POLE 22, DOUBLE DAVIT ON SIGNAL POLE

CERTIFIED BY Gregory Ken LIC. NO. 26829 DATE: 4-OCT-2022
LICENSED PROFESSIONAL ENGINEER

STATE PROJ. NO. 6212-181 (T.H. 36) SHEET NO. SL4 OF SL4 SHEETS

PLOTTED/REVISED: 4-OCT-2022

I PLOT NAME: 16212-181_Lit_0
 PATH & FILENAME: Projects\DM_R05036\6212181\TrafficLighting\6212-181_Lit_0.dgn