

FD. PT. W6S
 PAD MOUNTED SERVICE CABINET
 240/480 V (METERED)
 SECONDARY TYPE L1
 EQUIPMENT PAD B
 2" R.S.C. & 3-1/C#2 TO INPLACE XCEL
 POLE MOUNTED TRANSFORMER

W6S METER ADDRESS: 200 COUNTY RD D W NEW BRIGHTON 55112

LIGHTING PLANS
 FD. PT. W6S LAYOUT

I-35W NORTH MNPASS DB (S.P. 6284-180)
 SHEET NO. LL34 OF LL67 SHEETS

5:45:43 PM
 12/17/2021
 C:\Projects\2018\18005\CONSTRUCTION\Plan Sheets\cd6284180_cb_11110.dgn


NO	DATE	DWN	CKD	REVISIONS
0	05/22/19	AKS	MPM	RFC DP T-6
1	12/18/19	AKS	MPM	RFC DP T-5
2	12/03/21			RECORD DRAWING



RECORD DRAWING NOTE: THESE RECORD DRAWINGS WERE DEVELOPED BASED ON THE PREVIOUS DRAWING REVISIONS AND INFORMATION TRANSMITTED FROM THE FIELD BY OTHERS. THE INFORMATION CONTAINED WITHIN THIS RECORD AS-BUILT PLAN REPRESENTS THE ACTUAL CONDITIONS FOR ALL CHANGES OF WHICH ALLIANT IS AWARE. FUTURE USERS OF THESE DRAWINGS SHOULD VERIFY AS-BUILT CONDITIONS IN THE FIELD IN ALL CIRCUMSTANCES.



200
SCALE IN FEET

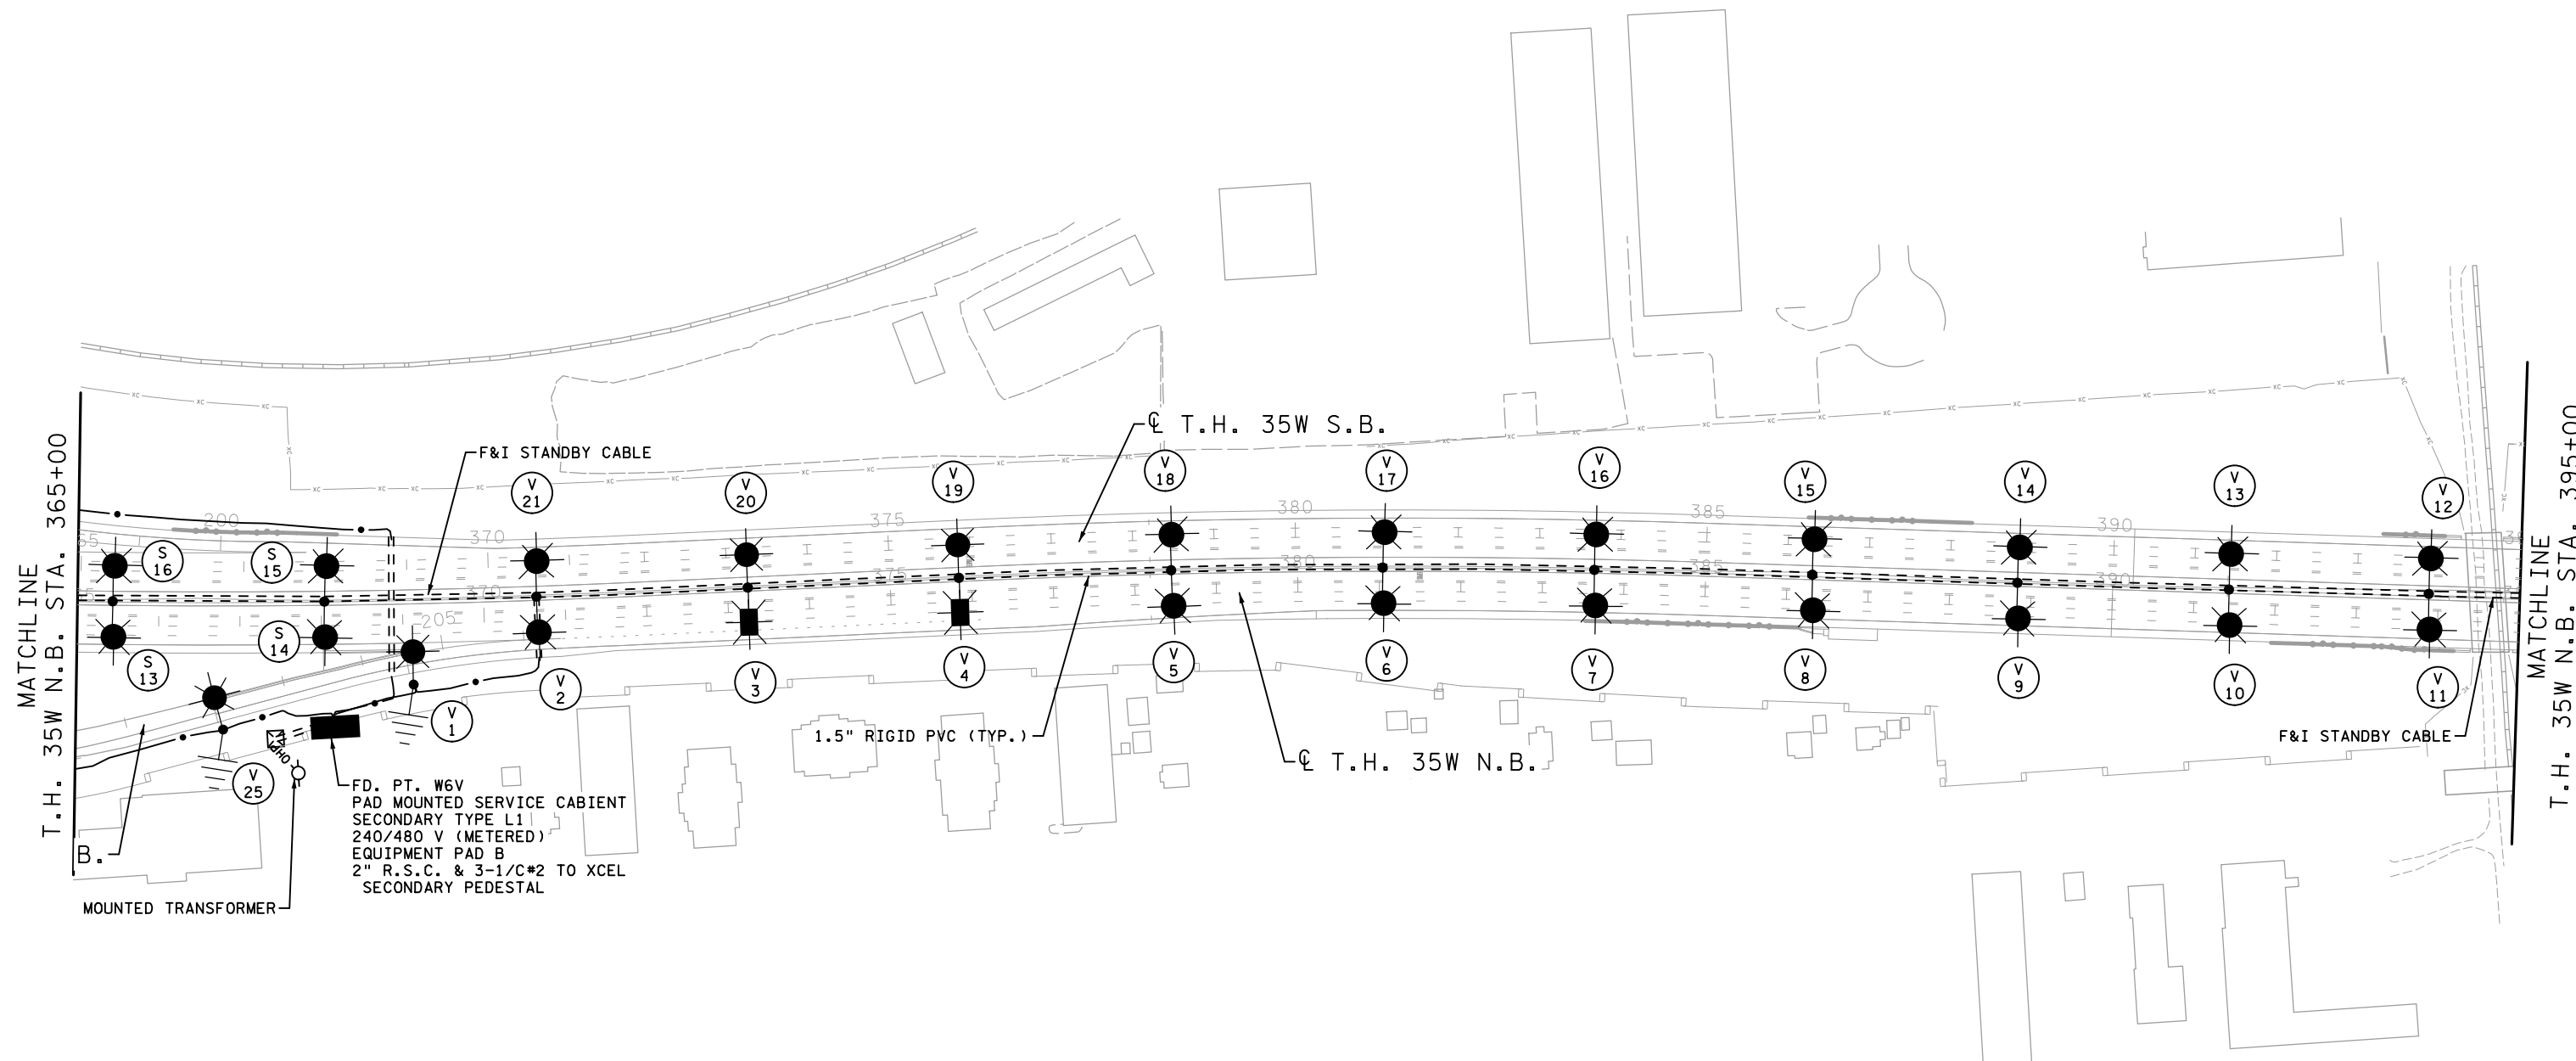

MATCHLINE
T.H. 35W N.B. STA. 365+00

MATCHLINE
T.H. 35W N.B. STA. 395+00

W6V METER ADDRESS: 392 CLEVELAND AVE SW NEW BRIGHTON 55112

2:47:15 PM
12/31/2021
C:\Projects\2018\18005\CONSTRUCTION\Plan Sheets\cd6284180_cb_11115.dgn

1	12/18/19	AKS	MPM	RFC DP T-5
2	05/27/20	AKS	MPM	FDC 194
3	12/03/21			RECORD DRAWING
NO	DATE	DWN	CKD	REVISIONS



RECORD DRAWING NOTE: THESE RECORD DRAWINGS WERE DEVELOPED BASED ON THE PREVIOUS DRAWING REVISIONS AND INFORMATION TRANSMITTED FROM THE FIELD BY OTHERS. THE INFORMATION CONTAINED WITHIN THIS RECORD AS-BUILT PLAN REPRESENTS THE ACTUAL CONDITIONS FOR ALL CHANGES OF WHICH ALLIANT IS AWARE. FUTURE USERS OF THESE DRAWINGS SHOULD VERIFY AS-BUILT CONDITIONS IN THE FIELD IN ALL CIRCUMSTANCES.


LIGHTING PLANS
FD. PT. W6V LAYOUT

I-35W NORTH MNPASS DB (S.P. 6284-180)
SHEET NO. LL36 OF LL67 SHEETS

FEEDPOINT W6V
LIGHTING STANDARDS AND FOUNDATIONS

NO.	STATION	LT.	RT.	LOCATION	TYPE	LUMINAIRE
1	204+57		-	C.R. 88 E.B.	9-49	49 FOOT
2	370+65	-		T.H. 35W N.B.	6BD-49	49 FOOT
21						49 FOOT
3	373+25	-		T.H. 35W N.B.	6BD-49	5 LANE
20						49 FOOT
4	375+85	-		T.H. 35W N.B.	6BD-49	5 LANE
19						49 FOOT
5	378+45	-		T.H. 35W N.B.	6BD-49	49 FOOT
18						49 FOOT
6	381+04	-		T.H. 35W N.B.	6BD-49	49 FOOT
17						49 FOOT
7	383+63	-		T.H. 35W N.B.	6BD-49	49 FOOT
16						49 FOOT
8	386+31	-		T.H. 35W N.B.	6BD-49	49 FOOT
15						49 FOOT
9	388+83	-		T.H. 35W N.B.	6BD-49	49 FOOT
14						49 FOOT
10	391+43	-		T.H. 35W N.B.	6BD-49	49 FOOT
13						49 FOOT
11	393+88	-		T.H. 35W N.B.	6BD-49	49 FOOT
12						49 FOOT
22	197+67	-		C.R. 88 W.B.	9-49	49 FOOT
23	197+44	-	-	C.R. 88 E.B.	9-40	40 FOOT
24	199+74	-	-	C.R. 88 E.B.	9-40	40 FOOT
25	202+14	-	-	C.R. 88 E.B.	9-40	40 FOOT
26	195+23	-	-	C.R. 88 W.B.	9-40	40 FOOT
27	192+77	-	-	C.R. 88 W.B.	9-40	40 FOOT
28	190+28	-	-	C.R. 88 W.B.	9-40	40 FOOT

B AND R DENOTE CURRENT CARRYING CONDUCTORS
W DENOTES NEUTRAL CONDUCTOR

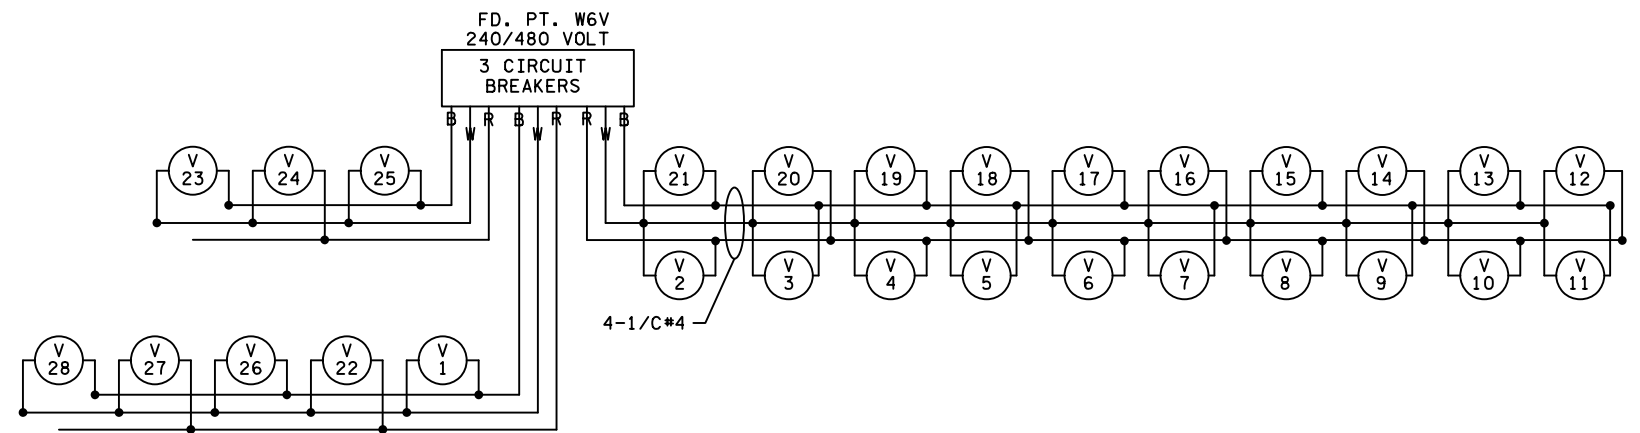

5:46:57 PM
 12/17/2021
 I:\Projects\2018\18005\CONSTRUCTION\Plan Sheets\cd6284180_cd_11116.dgn

0	05/22/19	AKS	MPM	RFC DP T-6
1	12/18/19	AKS	MPM	RFC DP T-5
2	12/03/21			RECORD DRAWING
NO	DATE	DWN	CKD	REVISIONS



RECORD DRAWING NOTE: THESE RECORD DRAWINGS WERE DEVELOPED BASED ON THE PREVIOUS DRAWING REVISIONS AND INFORMATION TRANSMITTED FROM THE FIELD BY OTHERS. THE INFORMATION CONTAINED WITHIN THIS RECORD AS-BUILT PLAN REPRESENTS THE ACTUAL CONDITIONS FOR ALL CHANGES OF WHICH ALLIANT IS AWARE. FUTURE USERS OF THESE DRAWINGS SHOULD VERIFY AS-BUILT CONDITIONS IN THE FIELD IN ALL CIRCUMSTANCES.

LIGHTING PLANS
FD. PT. W6V CHART & WIRING DIAGRAM

I-35W NORTH MNPASS DB (S.P. 6284-180)
SHEET NO. LL37 OF LL67 SHEETS