




200
SCALE IN FEET

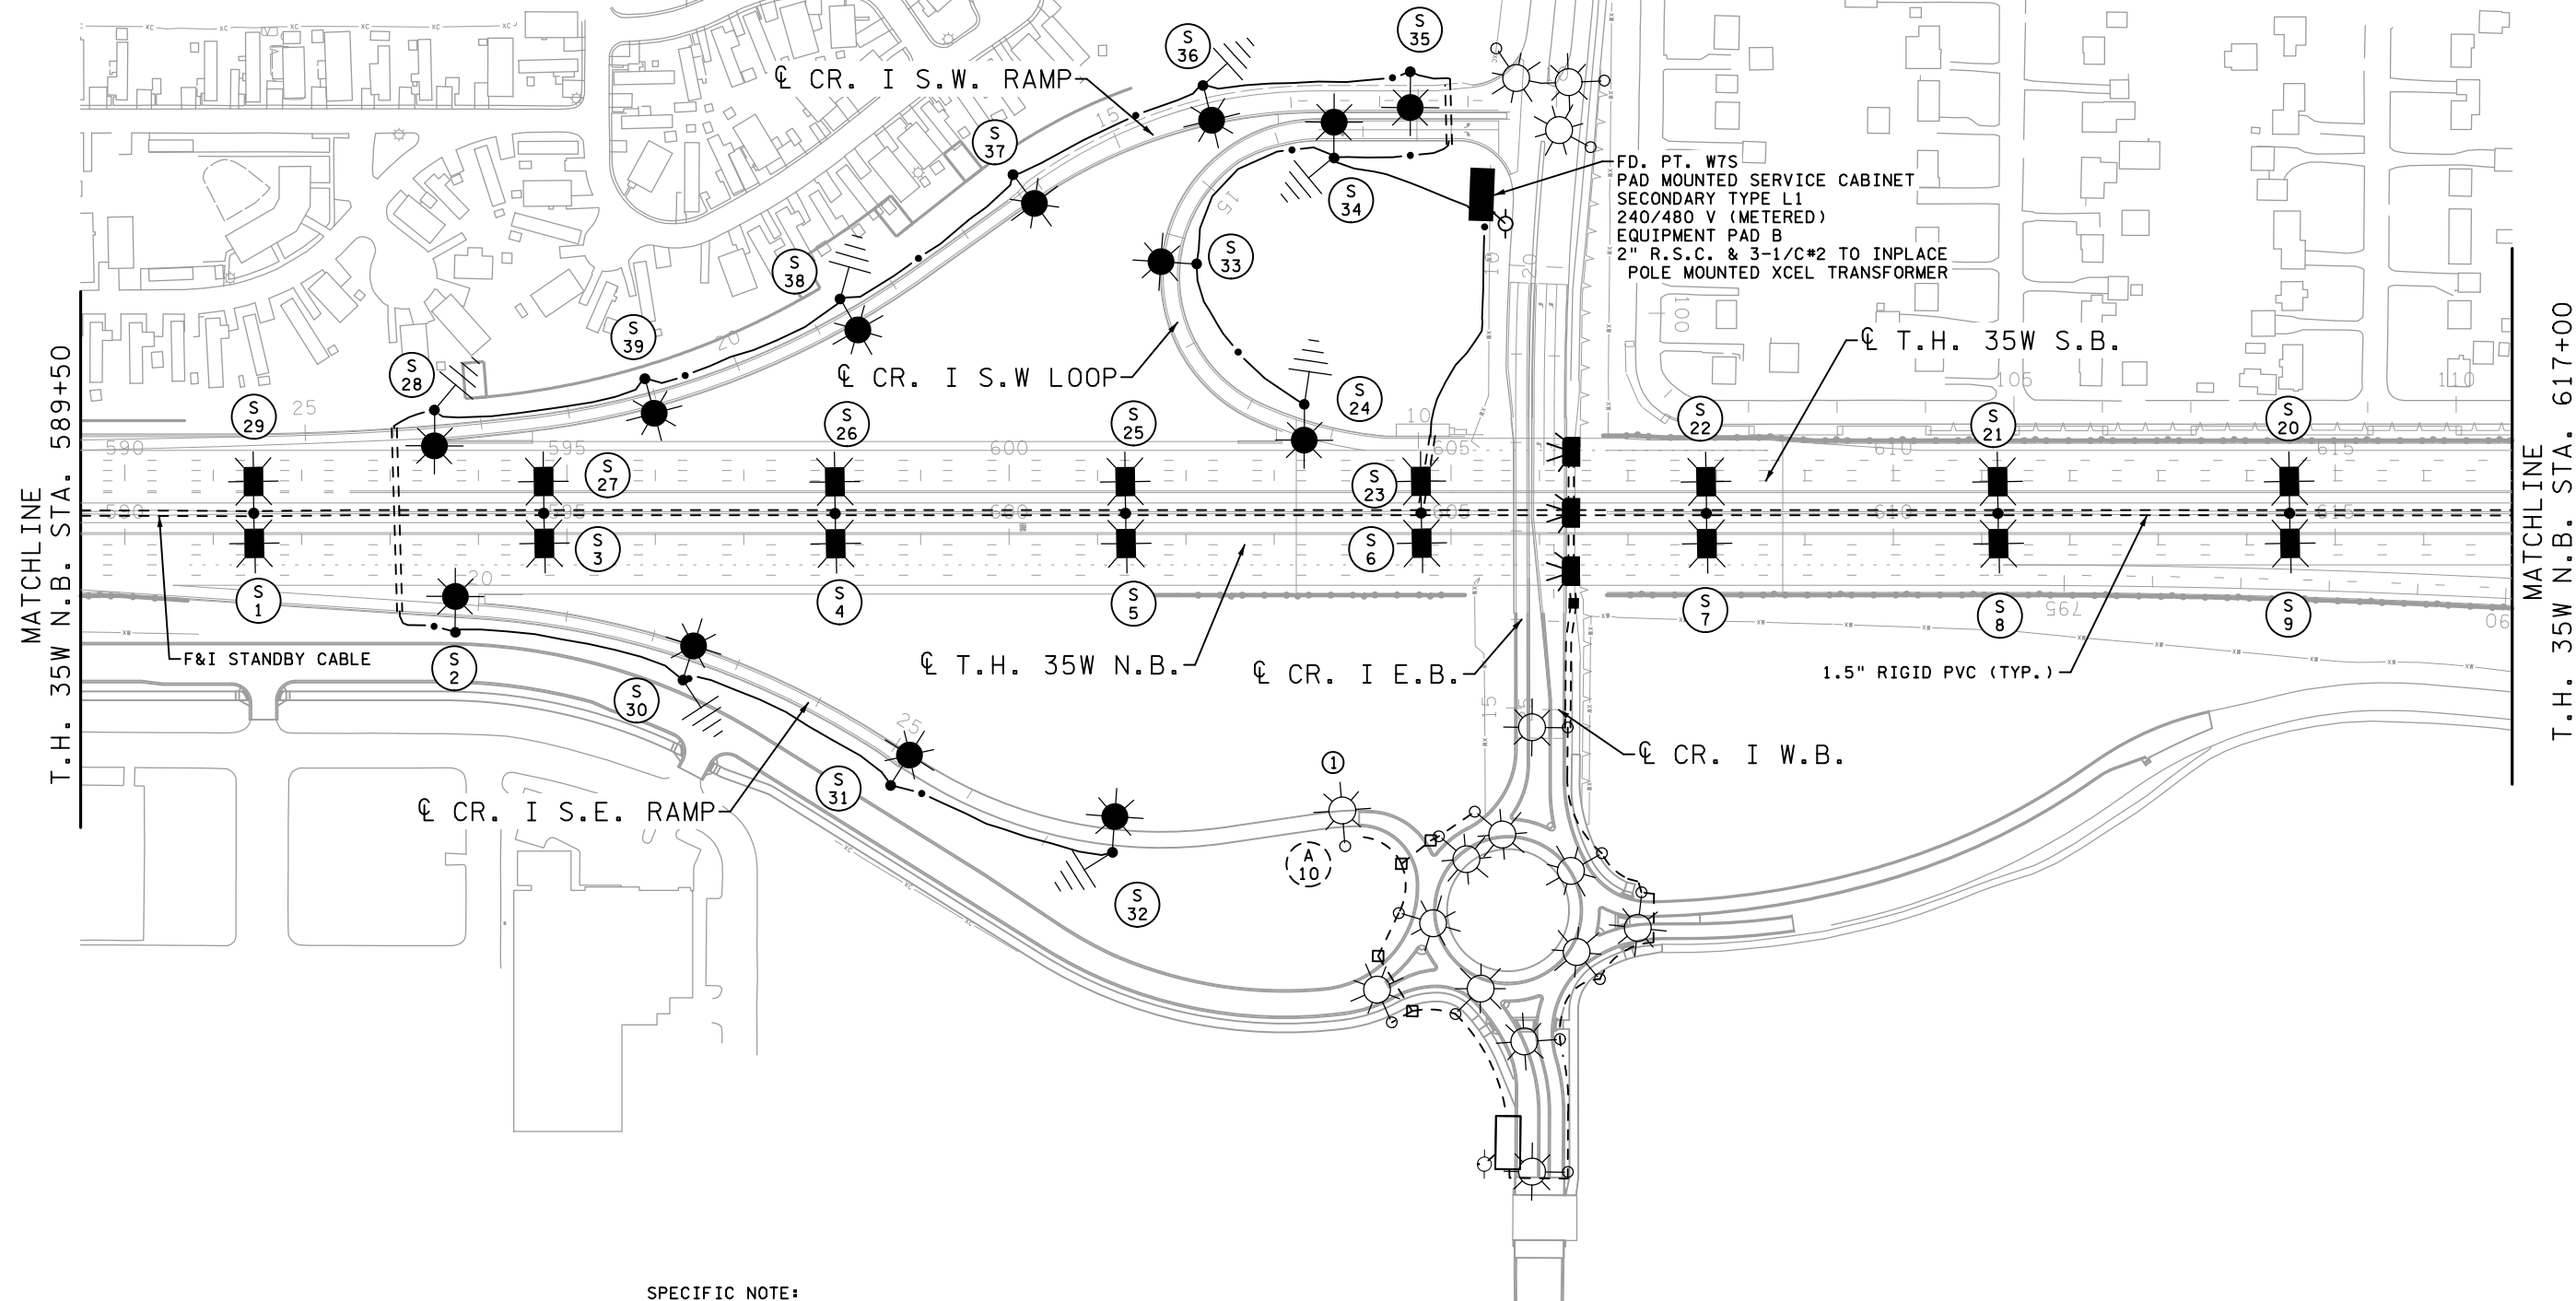

SPECIFIC NOTE:

- ① INPLACE RAMSEY COUNTY RD I RAB SYSTEM LIGHTING UNIT.

W7S METER ADDRESS: 2098 CTY RD I W. MOUNDS VIEW 55112

E:\48:07 PM 12/17/2021 12:17:20\Projects\2018\18005\CONSTRUCTION\Plan Sheets\cd6284180_cb_11155.dgn

1	09/20/19	AKS	MPM	FDC 125
2	12/18/19	AKS	MPM	REC DP T-5
3	12/03/21			RECORD DRAWING
NO	DATE	DWN	CKD	REVISIONS





RECORD DRAWING NOTE: THESE RECORD DRAWINGS WERE DEVELOPED BASED ON THE PREVIOUS DRAWING REVISIONS AND INFORMATION TRANSMITTED FROM THE FIELD BY OTHERS. THE INFORMATION CONTAINED WITHIN THIS RECORD AS-BUILT PLAN REPRESENTS THE ACTUAL CONDITIONS FOR ALL CHANGES OF WHICH ALLIANT IS AWARE. FUTURE USERS OF THESE DRAWINGS SHOULD VERIFY AS-BUILT CONDITIONS IN THE FIELD IN ALL CIRCUMSTANCES.

LIGHTING PLANS
FD. PT. W7S LAYOUT

I-35W NORTH MNPASS DB (S.P. 6284-180)
SHEET NO. LL52 OF LL67 SHEETS

MATCHLINE T.H. 10 E.B. STA. 761+50 MATCHLINE T.H. 10 W.B. N.W. RAMP STA. 13+25

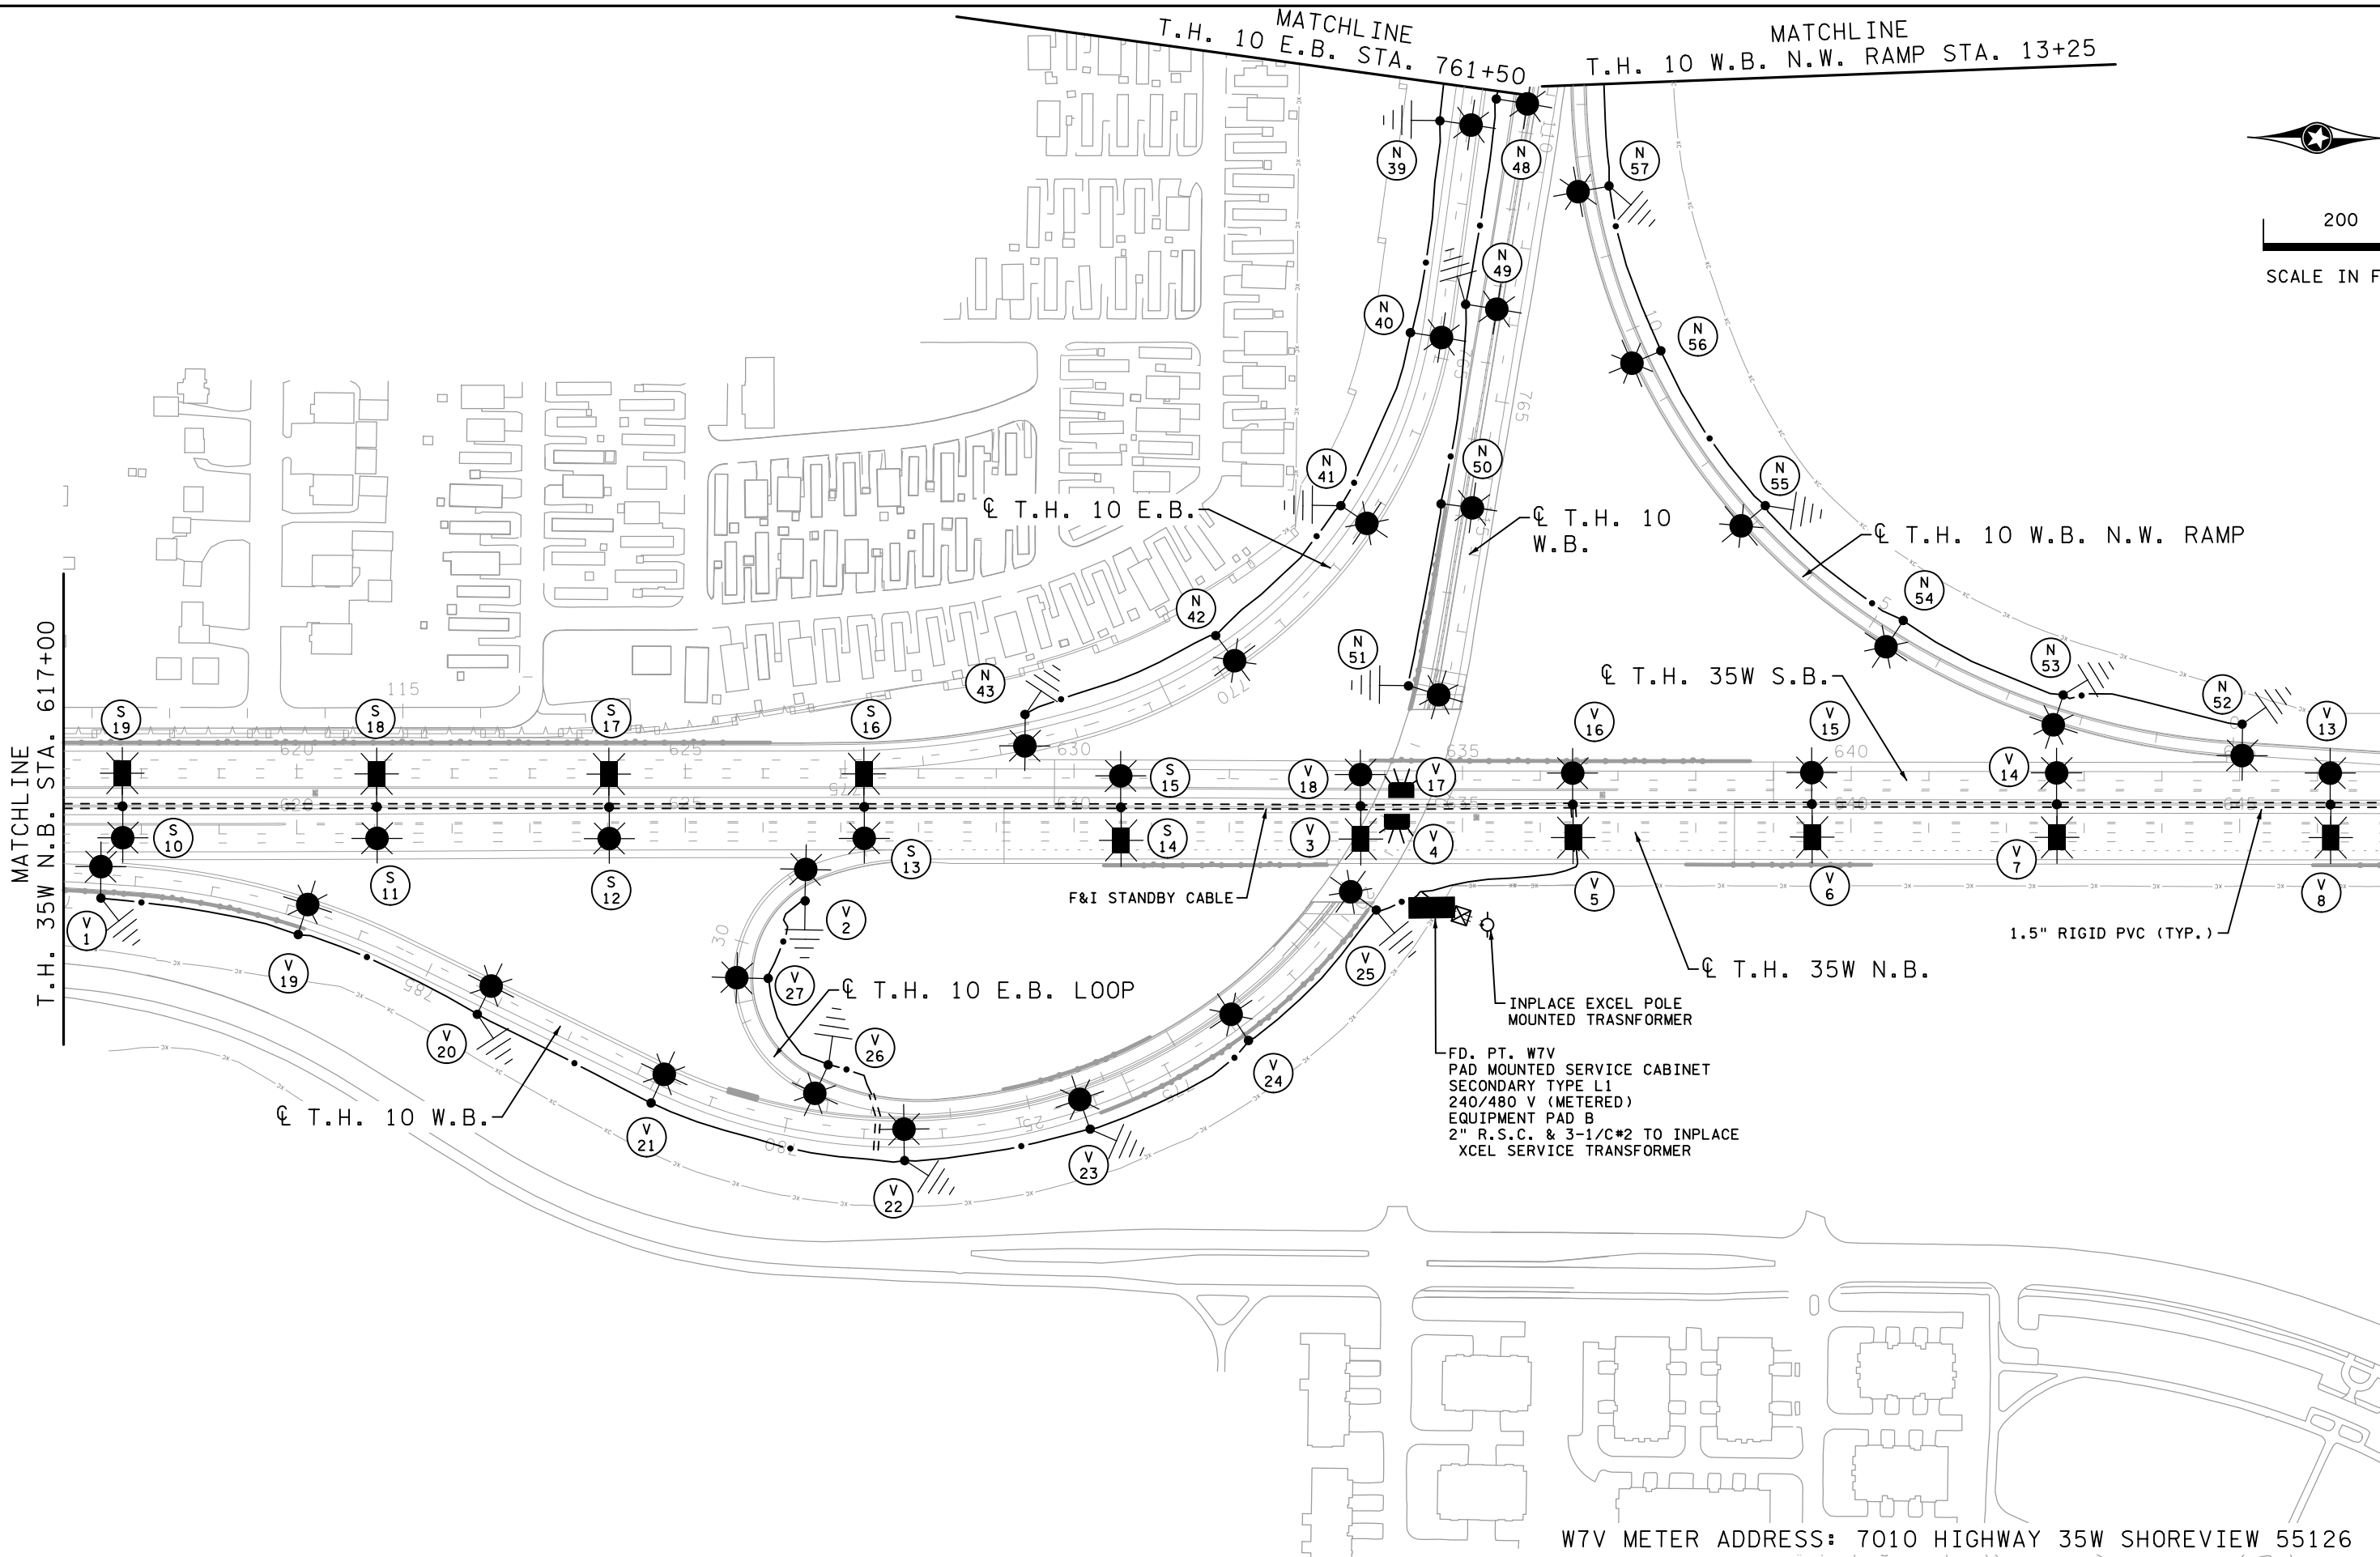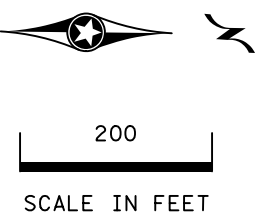

MATCHLINE T.H. 35W N.B. STA. 617+00

MATCHLINE T.H. 35W N.B. STA. 647+00

W7V METER ADDRESS: 7010 HIGHWAY 35W SHOREVIEW 55126

2:48:25 PM 12/3/2021 C:\Projects\2018\18005\CONSTRUCTION\Plan Sheets\cd6284180_cb_11160.dgn

2	12/18/19	AKS	MPM	RFC DP T-5
3	07/22/20	AKS	MPM	FDC 249
4	12/03/21			RECORD DRAWING
NO	DATE	DWN	CKD	REVISIONS



RECORD DRAWING NOTE: THESE RECORD DRAWINGS WERE DEVELOPED BASED ON THE PREVIOUS DRAWING REVISIONS AND INFORMATION TRANSMITTED FROM THE FIELD BY OTHERS. THE INFORMATION CONTAINED WITHIN THIS RECORD AS-BUILT PLAN REPRESENTS THE ACTUAL CONDITIONS FOR ALL CHANGES OF WHICH ALLIANT IS AWARE. FUTURE USERS OF THESE DRAWINGS SHOULD VERIFY AS-BUILT CONDITIONS IN THE FIELD IN ALL CIRCUMSTANCES.


LIGHTING PLANS
FD. PT. W7V LAYOUT

I-35W NORTH MNPASS DB (S.P. 6284-180)
SHEET NO. LL54 OF LL67 SHEETS

FEEDPOINT W7S
LIGHTING STANDARDS AND FOUNDATIONS

NO.	STATION	LT.	RT.	LOCATION	TYPE	LUMINAIRE
1	591+46	-		T.H. 35W N.B.	6BD-49	5 LANE
29						5 LANE
2	19+75		-	C.R. I S.E. RAMP	9-49	49 FOOT
3	594+74	-		T.H. 35W N.B.	6BD-49	5 LANE
27						5 LANE
4	598+03	-		T.H. 35W N.B.	6BD-49	5 LANE
26						5 LANE
5	601+32	-		T.H. 35W N.B.	6BD-49	5 LANE
25						5 LANE
6	604+66	-		T.H. 35W N.B.	6BD-49	5 LANE
23						5 LANE
7	607+89	-		T.H. 35W N.B.	6BD-49	5 LANE
22						5 LANE
8	611+18	-		T.H. 35W N.B.	6BD-49	5 LANE
21						5 LANE
9	614+48	-		T.H. 35W N.B.	6BD-49	5 LANE
20						5 LANE
10	617+76	-		T.H. 35W N.B.	6BD-49	49 FOOT
19						5 LANE
11	621+03	-		T.H. 35W N.B.	6BD-49	49 FOOT
18						5 LANE
12	624+02	-		T.H. 35W N.B.	6BD-49	49 FOOT
17						5 LANE
13	627+30	-		T.H. 35W N.B.	6BD-49	49 FOOT
16						5 LANE
14	630+60	-		T.H. 35W N.B.	6BD-49	5 LANE
15						49 FOOT
24	11+41		-	C.R. I S.W. LOOP	9-49	49 FOOT
28	23+50		-	C.R. I S.W. RAMP	9-49	49 FOOT
30	22+47		-	C.R. I S.E. RAMP	9-40	40 FOOT
31	25+19		-	C.R. I S.E. RAMP	9-40	40 FOOT
32	27+03		-	C.R. I S.E. RAMP	9-40	40 FOOT
33	14+01		-	C.R. I S.W. LOOP	9-40	40 FOOT
34	16+67		-	C.R. I S.W. LOOP	9-40	40 FOOT
35	11+65		-	C.R. I S.W. RAMP	9-40	40 FOOT
36	13+93		-	C.R. I S.W. RAMP	9-40	40 FOOT
37	16+18		-	C.R. I S.W. RAMP	9-40	40 FOOT
38	18+61		-	C.R. I S.W. RAMP	9-40	40 FOOT
39	21+06		-	C.R. I S.W. RAMP	9-40	40 FOOT

B AND R DENOTE CURRENT CARRYING CONDUCTORS
W DENOTES NEUTRAL CONDUCTOR

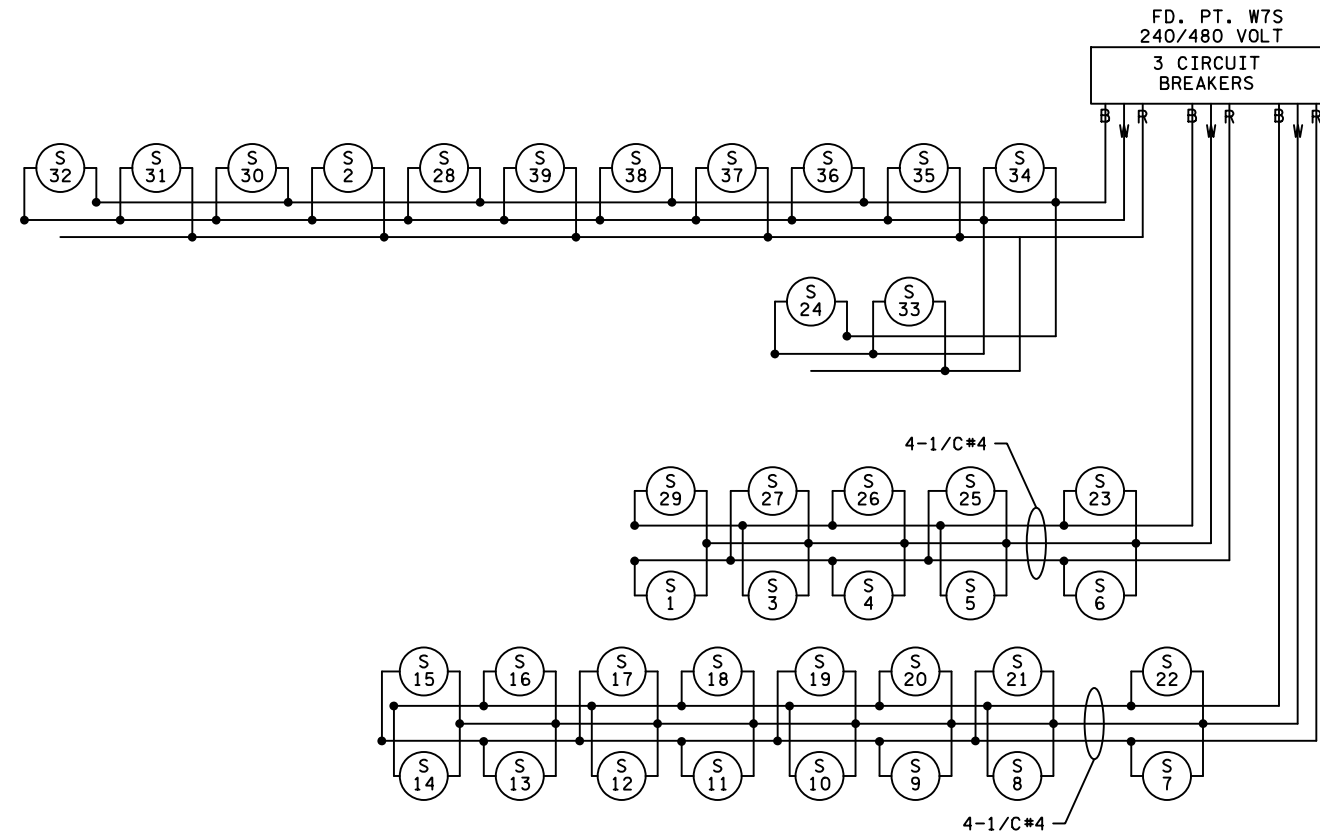

5:48:12 PM
 12/17/2021
 ..\Projects\2018\18005\CONSTRUCTION\Plan Sheets\cd6284180_cb_11156.dgn

NO	DATE	DWN	CKD	REVISIONS
0	05/22/19	AKS	MPM	RFC DP T-6
1	12/18/19	AKS	MPM	RFC DP T-5
2	12/03/21			RECORD DRAWING



RECORD DRAWING NOTE: THESE RECORD DRAWINGS WERE DEVELOPED BASED ON THE PREVIOUS DRAWING REVISIONS AND INFORMATION TRANSMITTED FROM THE FIELD BY OTHERS. THE INFORMATION CONTAINED WITHIN THIS RECORD AS-BUILT PLAN REPRESENTS THE ACTUAL CONDITIONS FOR ALL CHANGES OF WHICH ALLIANT IS AWARE. FUTURE USERS OF THESE DRAWINGS SHOULD VERIFY AS-BUILT CONDITIONS IN THE FIELD IN ALL CIRCUMSTANCES.

LIGHTING PLANS
FD. PT. W7S CHART & WIRING DIAGRAM

I-35W NORTH MNPASS DB (S.P. 6284-180)
SHEET NO. LL53 OF LL67 SHEETS