


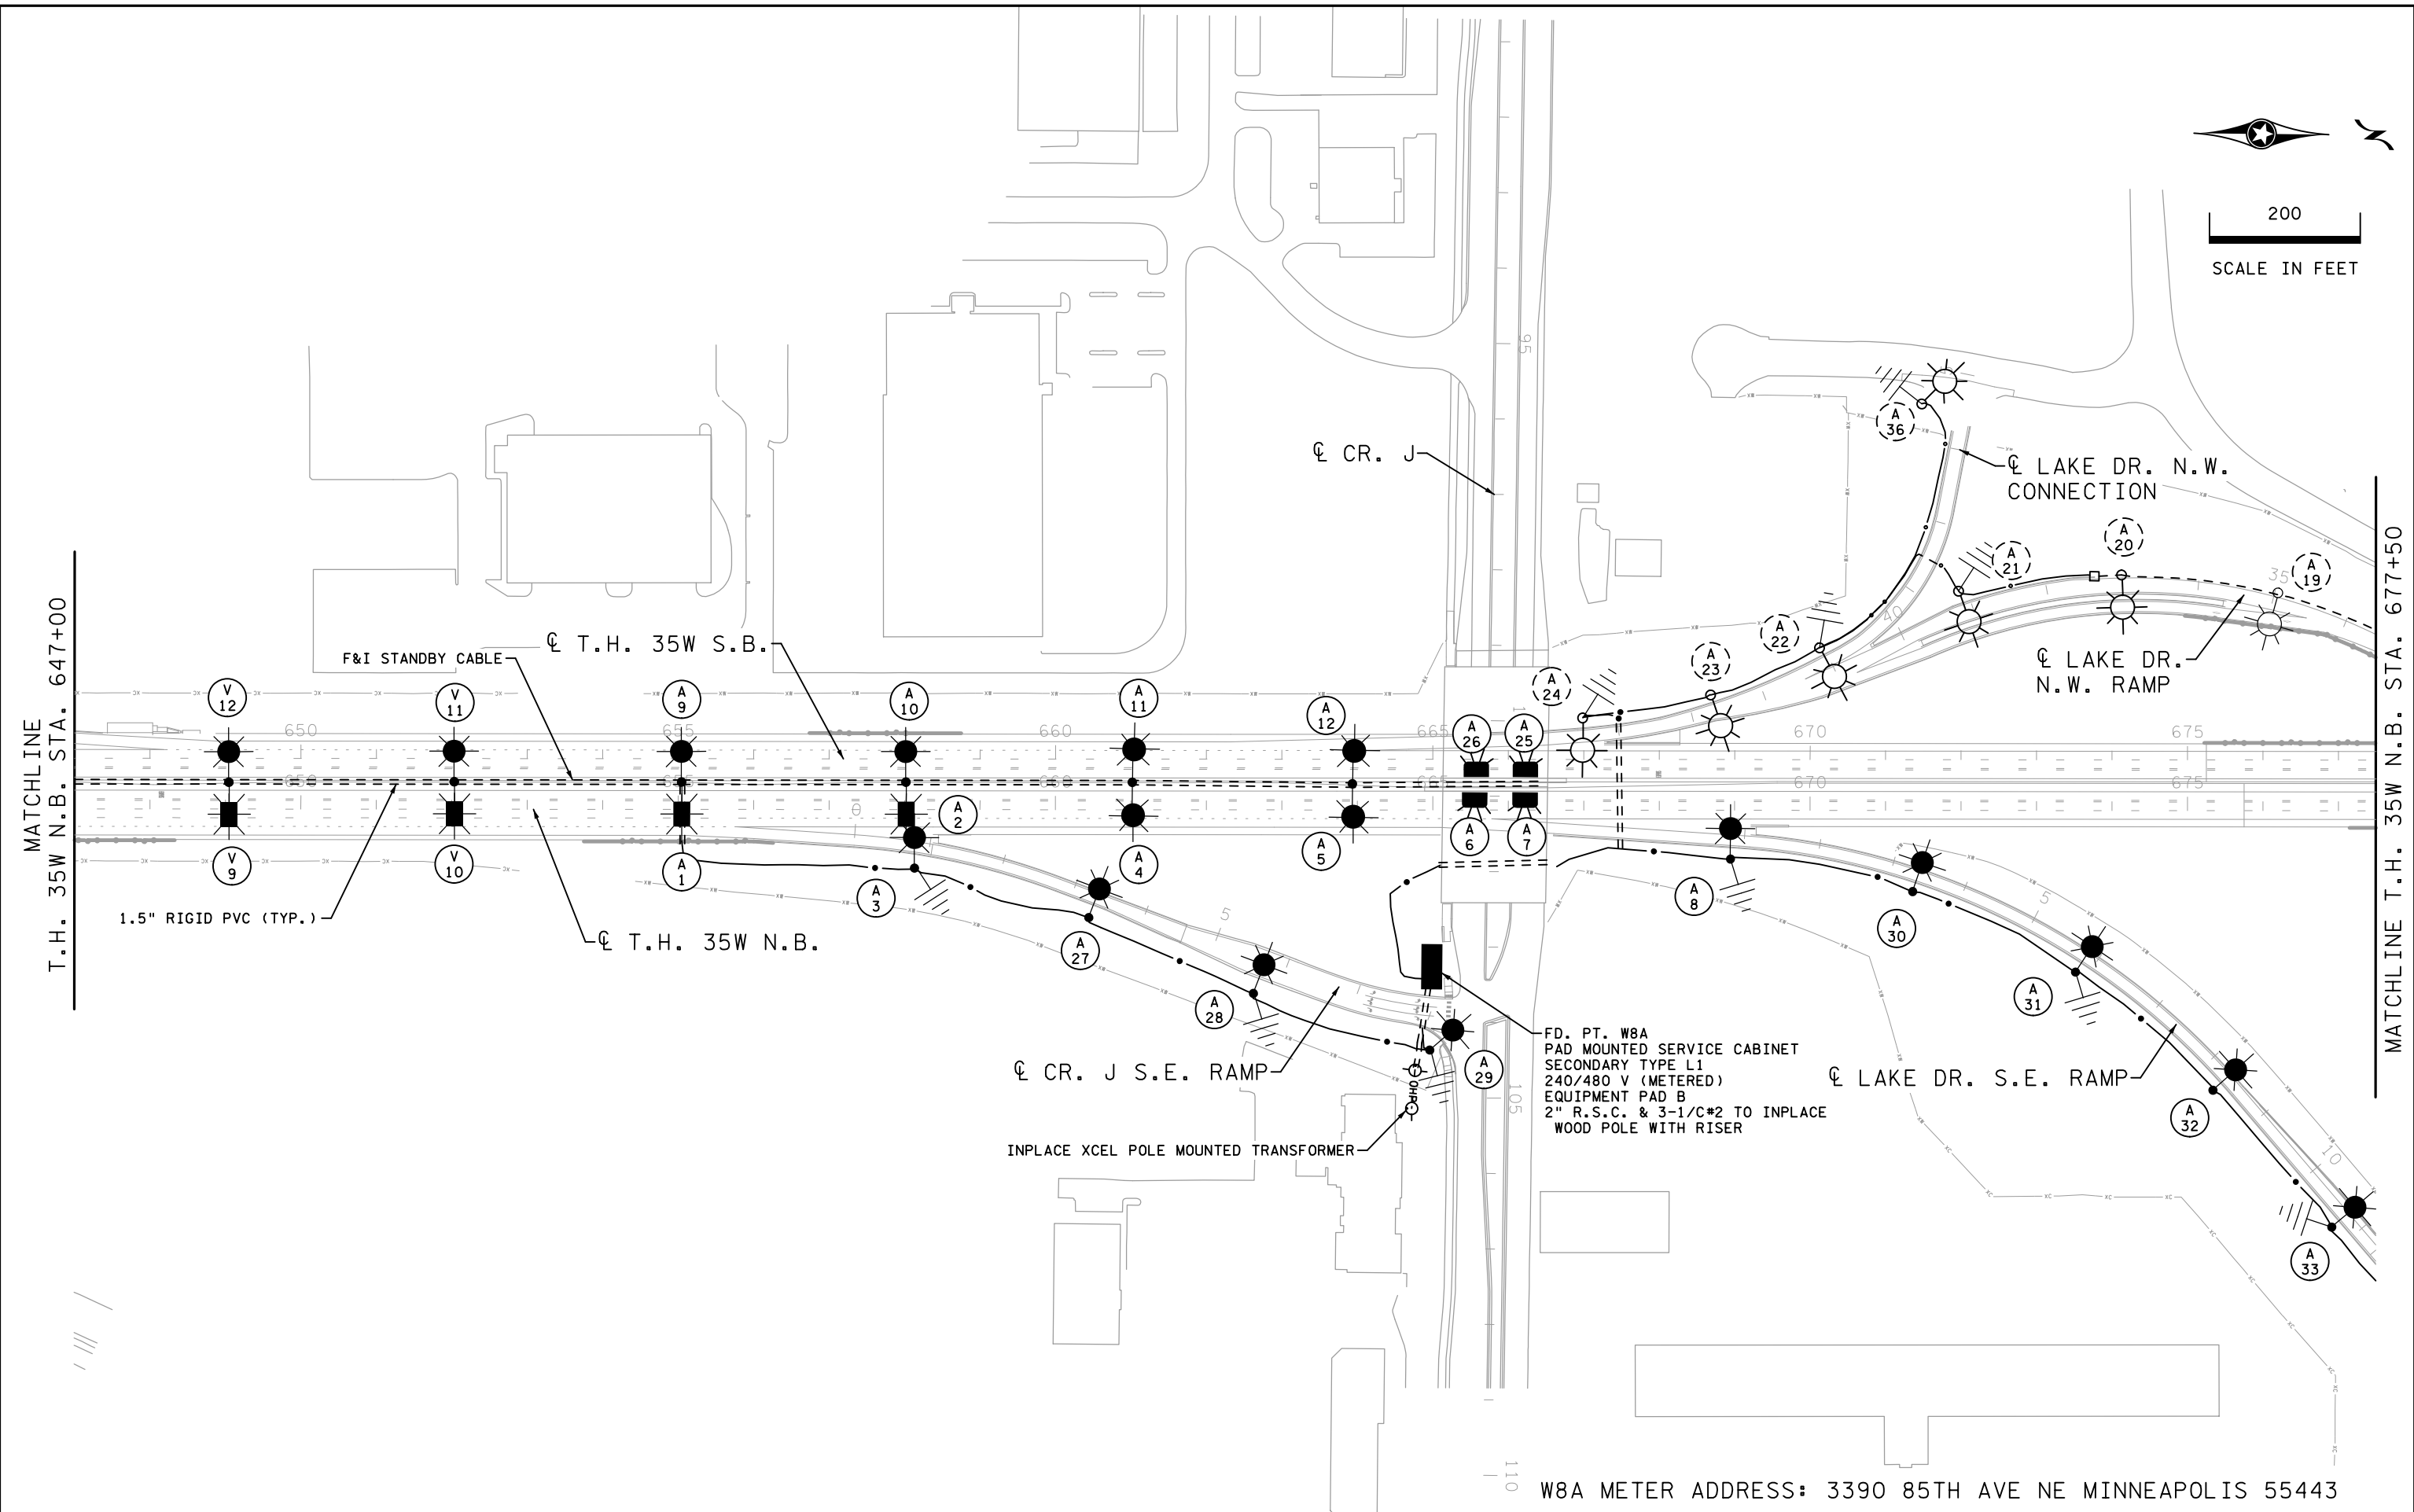

200  
SCALE IN FEET



FD. PT. W8A  
PAD MOUNTED SERVICE CABINET  
SECONDARY TYPE L1  
240/480 V (METERED)  
EQUIPMENT PAD B  
2" R.S.C. & 3-1/C#2 TO INPLACE  
WOOD POLE WITH RISER

INPLACE XCEL POLE MOUNTED TRANSFORMER

W8A METER ADDRESS: 3390 85TH AVE NE MINNEAPOLIS 55443

21:48:31 PM  
12/3/2021  
C:\Projects\2018\18005\CONSTRUCTION\Plan Sheets\cd6284180\_cb\_11165.dgn



3	1/14/20	LEW	MPM	RFC DP T-5
4	05/27/20	AKS	MPM	FDC 194
5	12/03/21			RECORD DRAWING
NO	DATE	DWN	CKD	REVISIONS



RECORD DRAWING NOTE: THESE RECORD DRAWINGS WERE DEVELOPED BASED ON THE PREVIOUS DRAWING REVISIONS AND INFORMATION TRANSMITTED FROM THE FIELD BY OTHERS. THE INFORMATION CONTAINED WITHIN THIS RECORD AS-BUILT PLAN REPRESENTS THE ACTUAL CONDITIONS FOR ALL CHANGES OF WHICH ALLIANT IS AWARE. FUTURE USERS OF THESE DRAWINGS SHOULD VERIFY AS-BUILT CONDITIONS IN THE FIELD IN ALL CIRCUMSTANCES.

LIGHTING PLANS  
FD. PT. W8A LAYOUT

I-35W NORTH MNPASS DB (S.P. 6284-180)  
SHEET NO. LL56 OF LL67 SHEETS

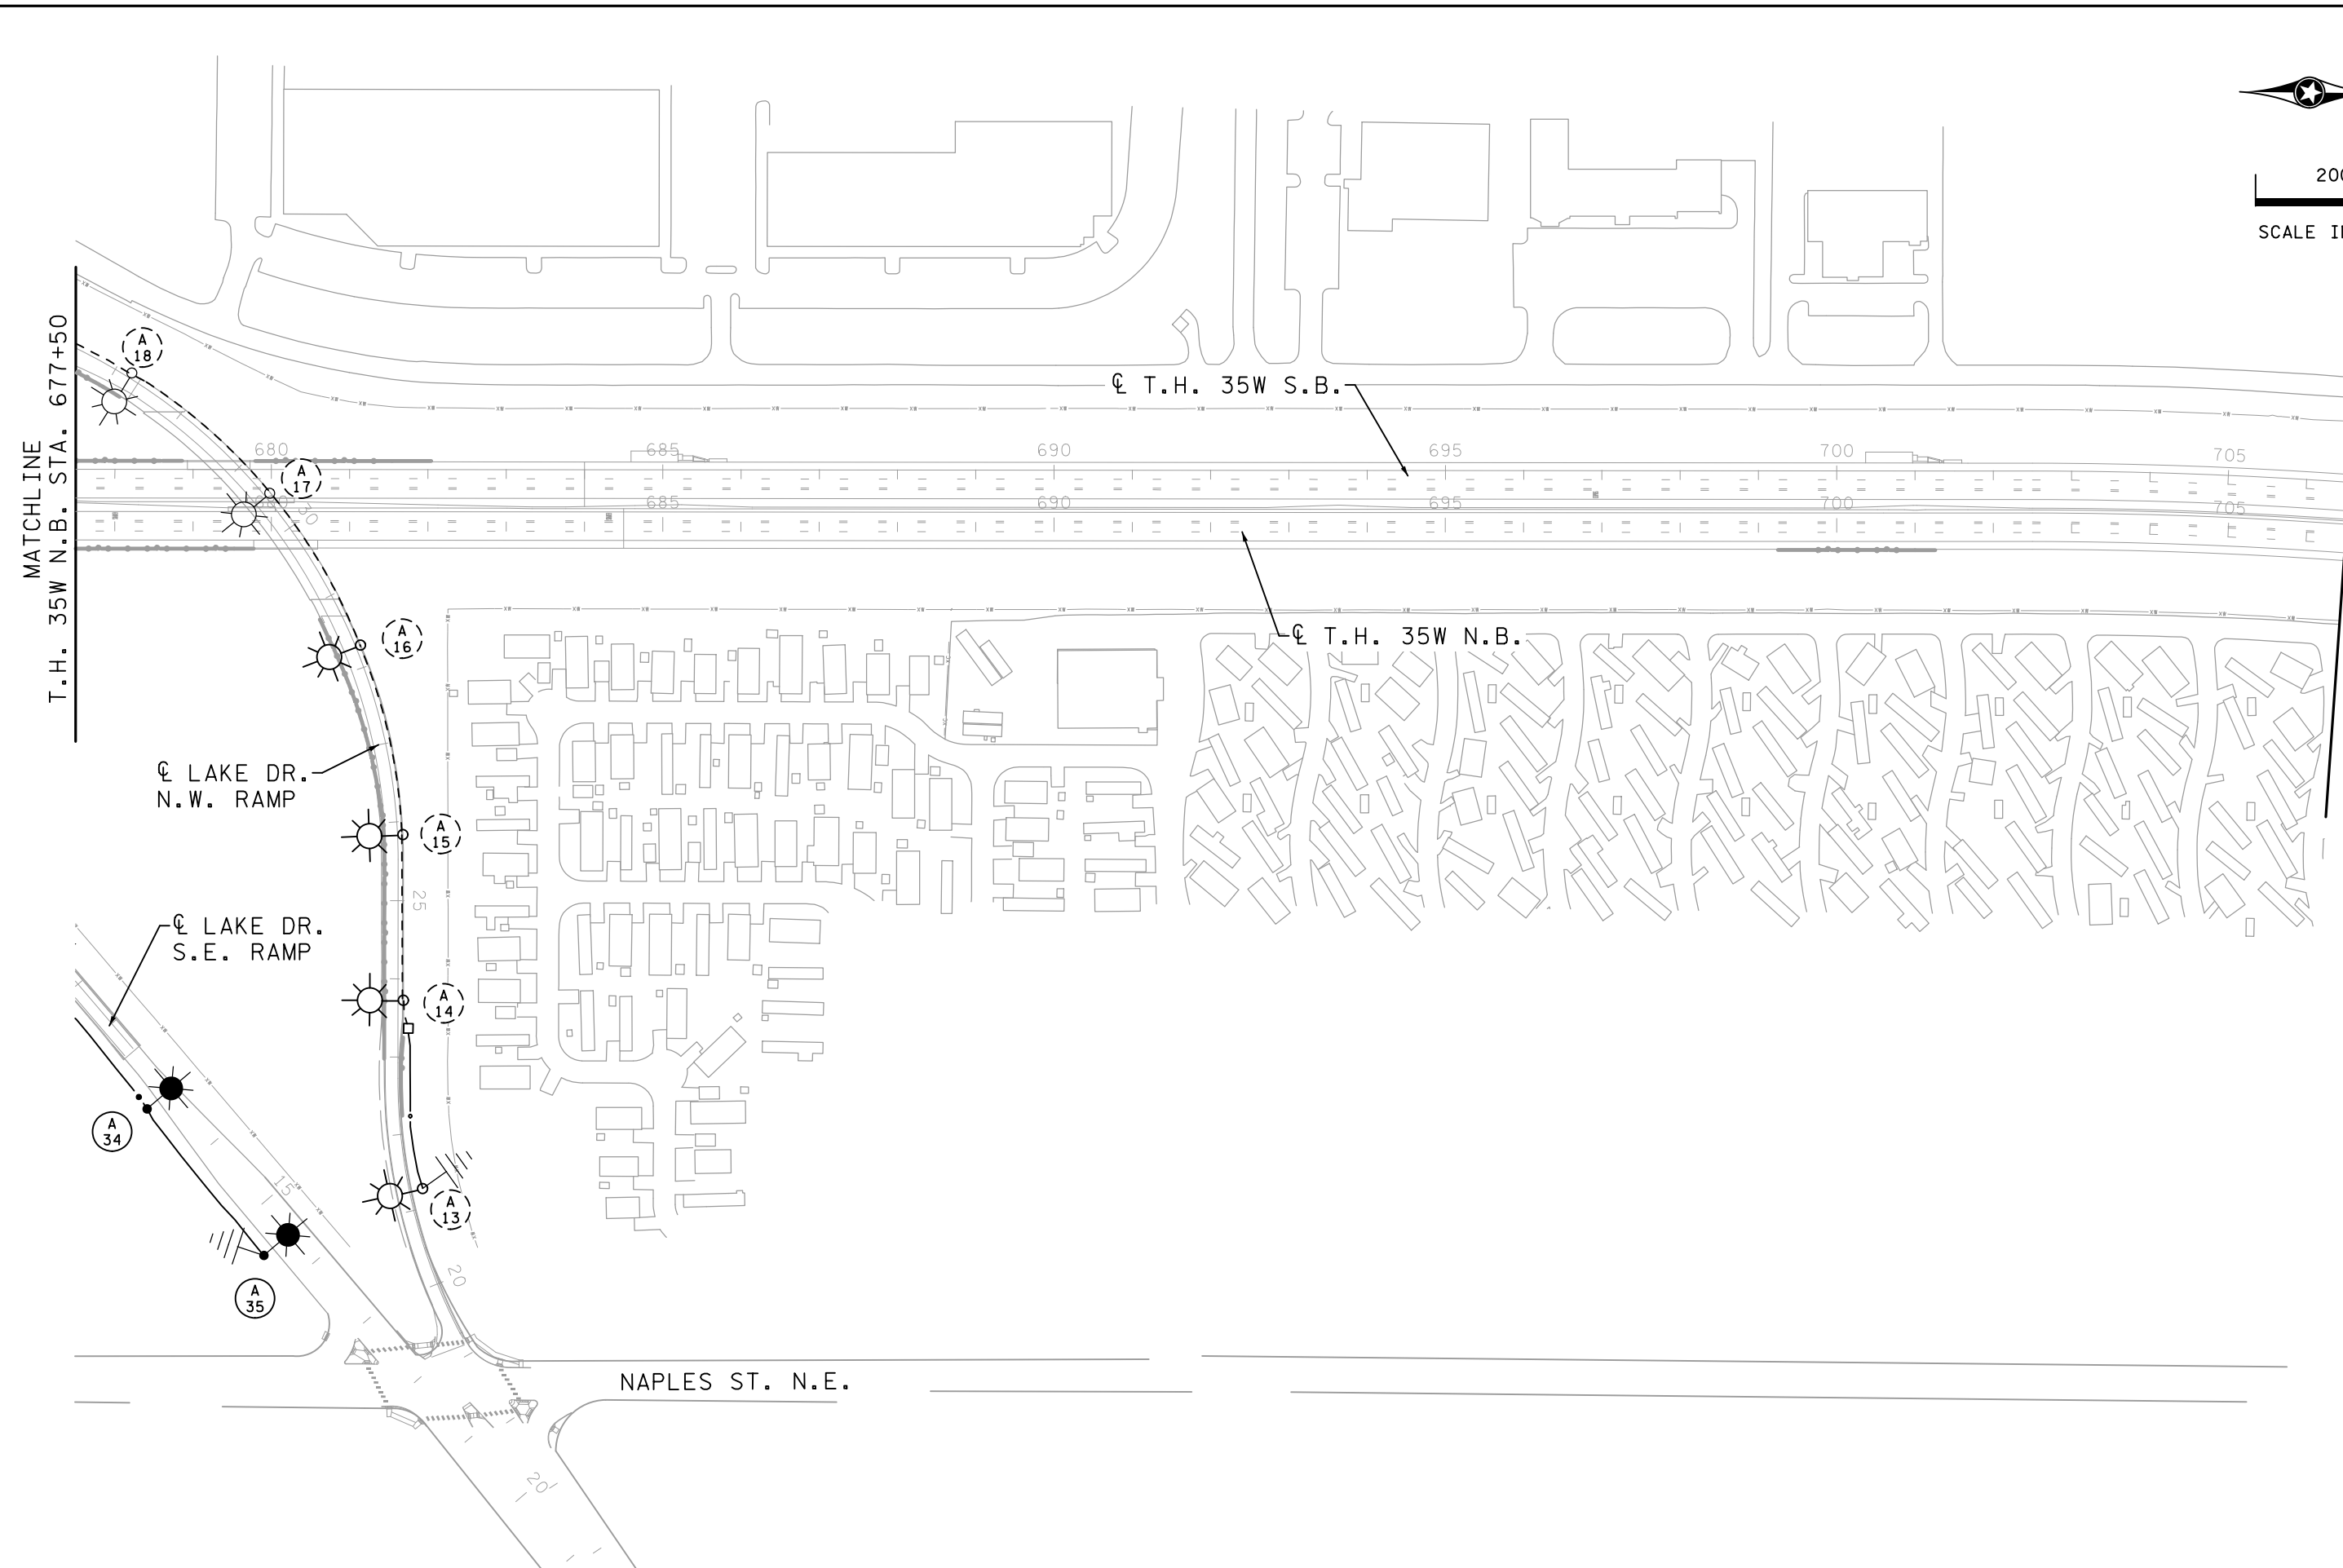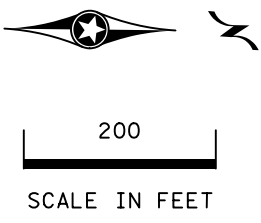

5:48:35 PM  
 12/17/2021  
 C:\Projects\2018\18005\CONSTRUCTION\Plan Sheets\cd6284180\_cb\_11170.dgn

0	05/22/19	AKS	MPM	RFC DP T-6
1	12/18/19	AKS	MPM	RFC DP T-5
2	12/03/21			RECORD DRAWING
NO	DATE	DWN	CKD	REVISIONS



RECORD DRAWING NOTE: THESE RECORD DRAWINGS WERE DEVELOPED BASED ON THE PREVIOUS DRAWING REVISIONS AND INFORMATION TRANSMITTED FROM THE FIELD BY OTHERS. THE INFORMATION CONTAINED WITHIN THIS RECORD AS-BUILT PLAN REPRESENTS THE ACTUAL CONDITIONS FOR ALL CHANGES OF WHICH ALLIANT IS AWARE. FUTURE USERS OF THESE DRAWINGS SHOULD VERIFY AS-BUILT CONDITIONS IN THE FIELD IN ALL CIRCUMSTANCES.

LIGHTING PLANS  
 FD. PT. W8A LAYOUT

**I-35W NORTH MNPASS DB (S.P. 6284-180)**  
 SHEET NO. LL57 OF LL67 SHEETS

