



SEE LEGEND SHEET 8



PLOTTED/REVISED: 7/17/2013

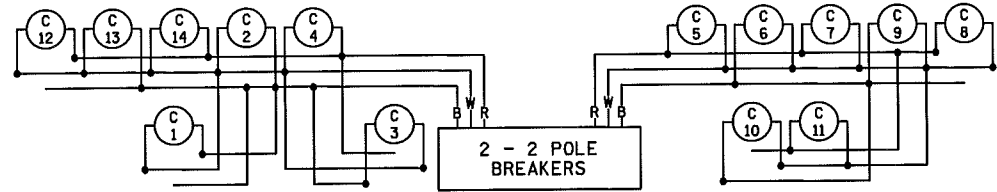

240/480 VOLT
FD. PT. W9C
B AND R DENOTE CURRENT CARRYING CONDUCTORS
W DENOTES NEUTRAL CONDUCTOR
DASHED LINES DENOTE INPLACE ITEMS

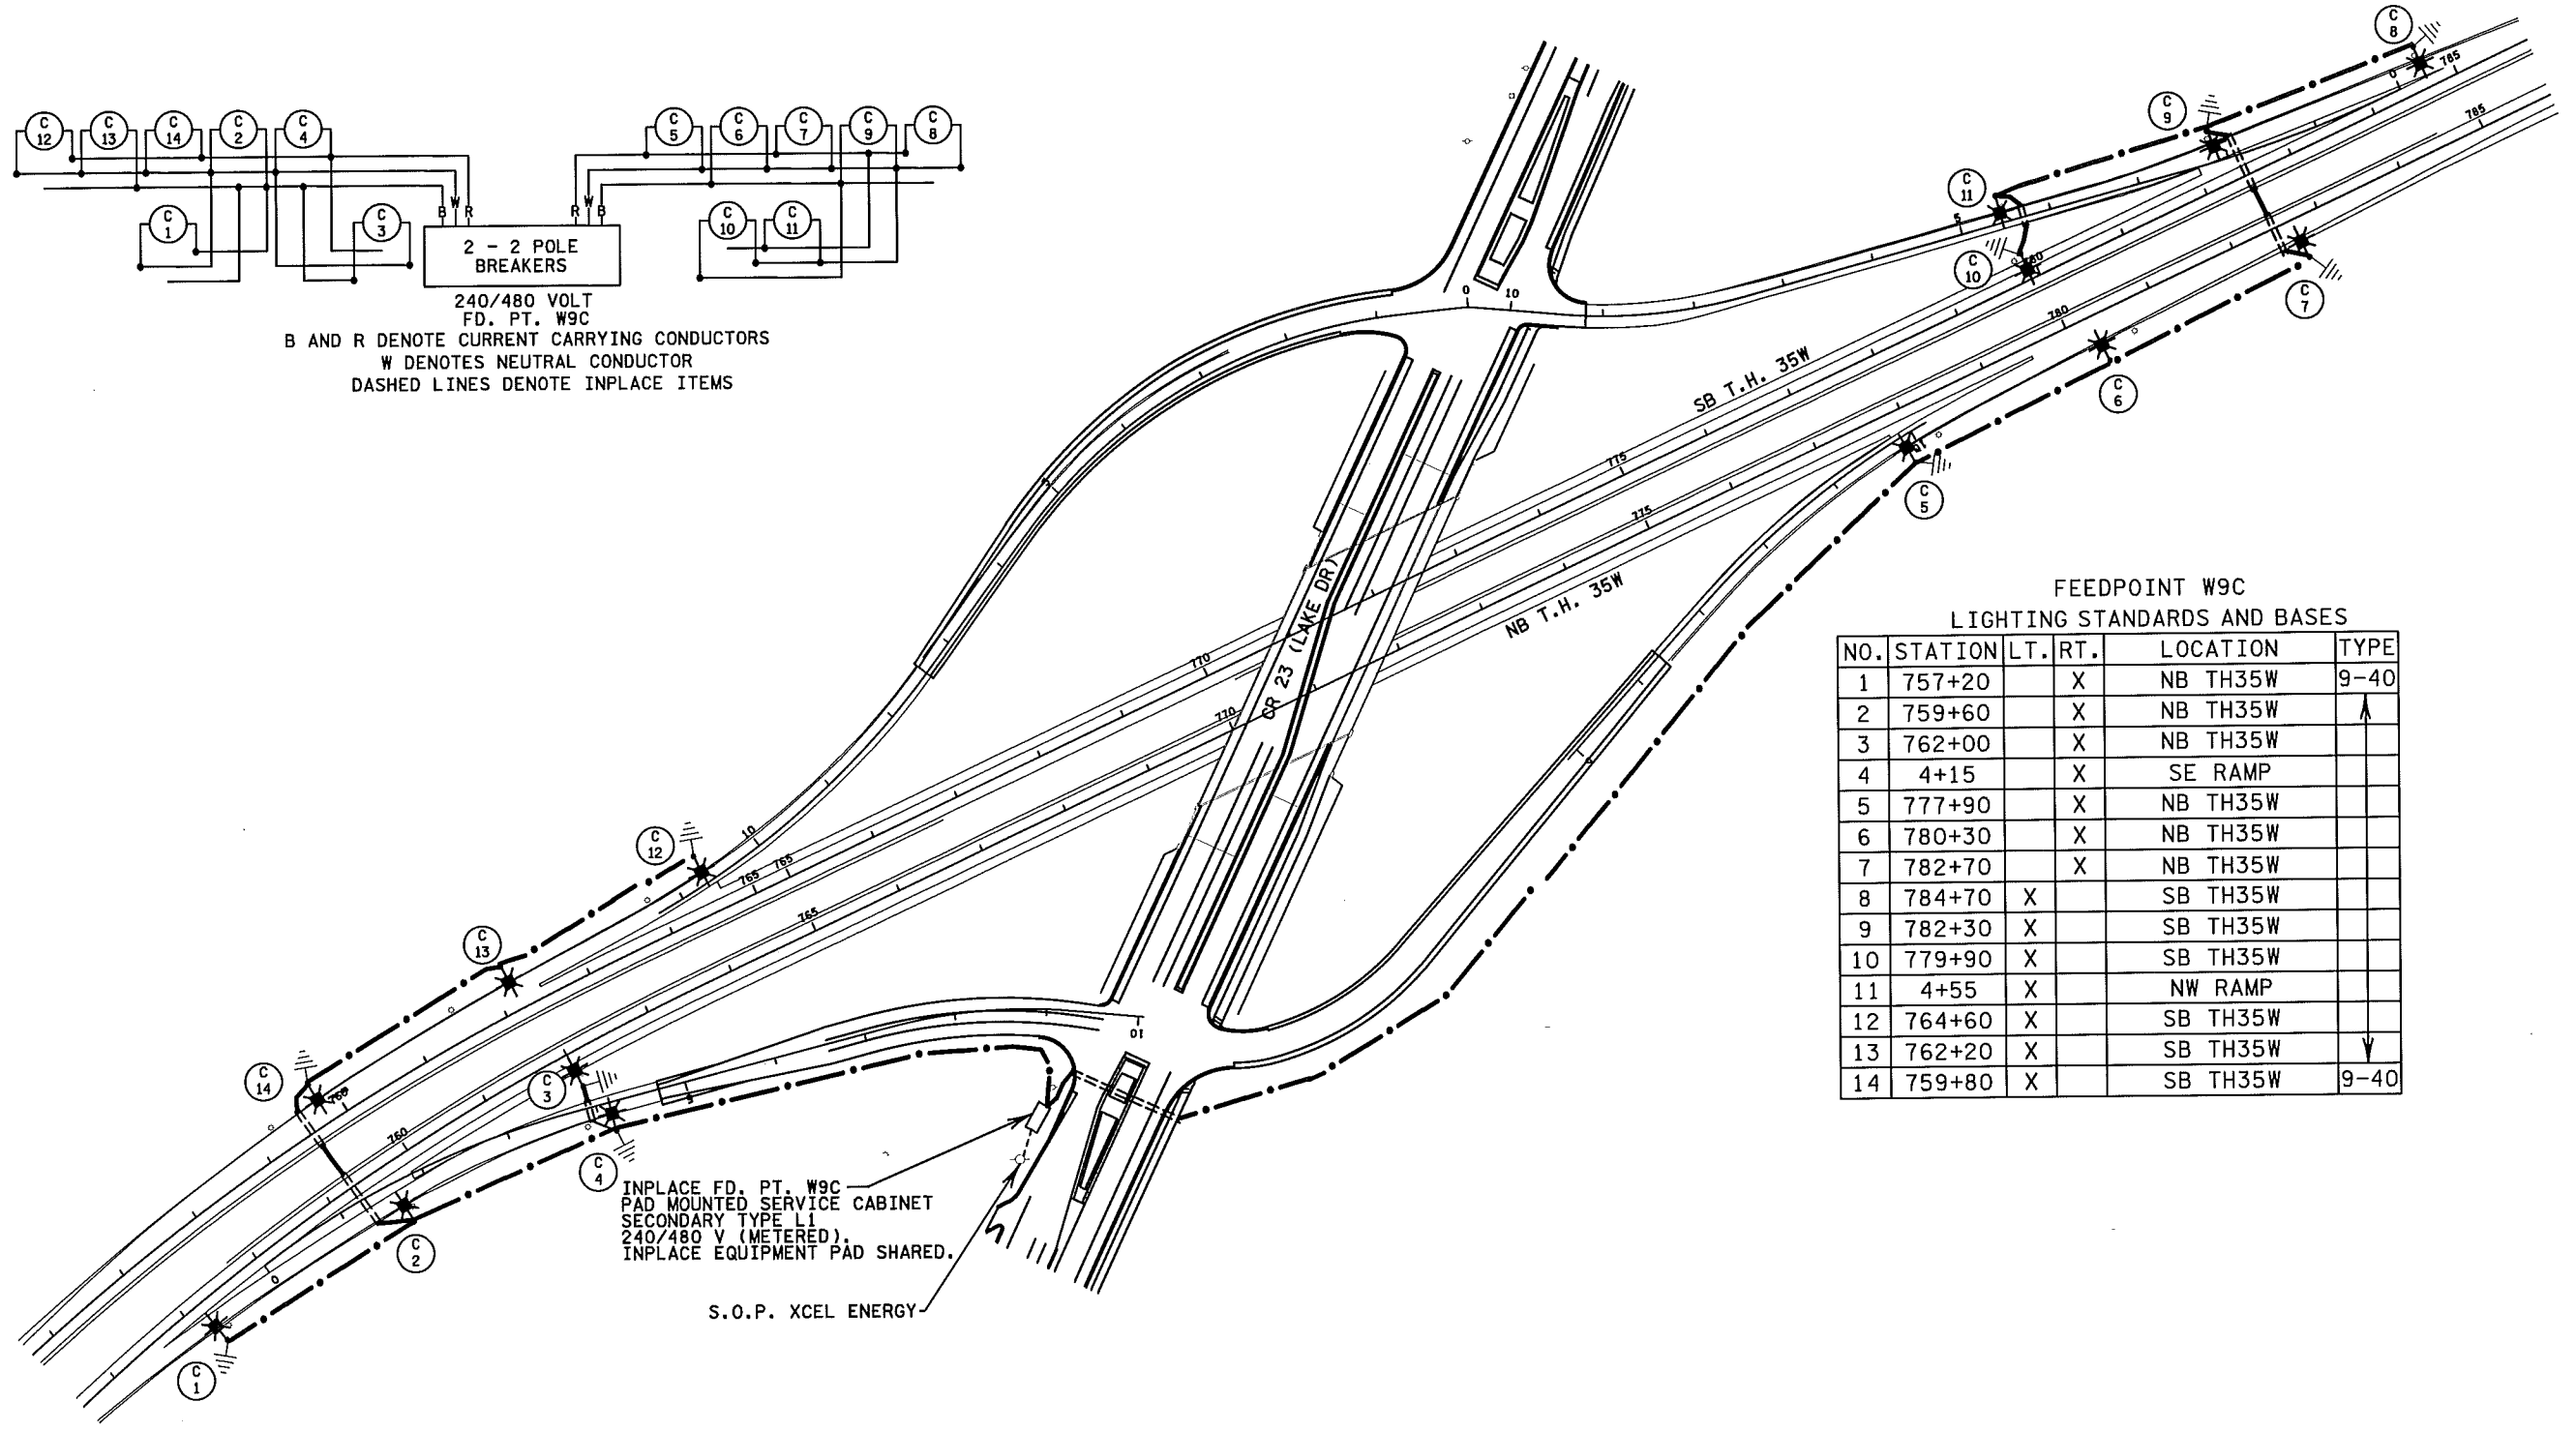

FEEDPOINT W9C
LIGHTING STANDARDS AND BASES

NO.	STATION	LT.	RT.	LOCATION	TYPE
1	757+20		X	NB TH35W	9-40
2	759+60		X	NB TH35W	↑
3	762+00		X	NB TH35W	
4	4+15		X	SE RAMP	
5	777+90		X	NB TH35W	
6	780+30		X	NB TH35W	
7	782+70		X	NB TH35W	
8	784+70	X		SB TH35W	
9	782+30	X		SB TH35W	
10	779+90	X		SB TH35W	
11	4+55	X		NW RAMP	
12	764+60	X		SB TH35W	
13	762+20	X		SB TH35W	↓
14	759+80	X		SB TH35W	9-40

DISTRICT #: METRO
I/PLOT NAME: 10280-68/102
PATH & FILENAME: IP_PWP-d1526699\0280-68/102.dgn

FEED POINT W9C

BY	DATE	REVISIONS	FEEDPOINT: W9C	LOCATION: T.H. 35W	LIGHTING PLAN	
			METER ADDRESS: 7510 LAKE DR. LINO LAKES 55014		STATE PROJ.NO.0280-68 (T.H.35W) SHEET NO. 10 OF 10 SHEETS	
DRAWN BY: PB CKD BY: GB DATE: 7/2013			CERTIFIED BY: <i>Michael P. Sabinsky</i> LIC. NO. 19863 DATE: 7/17/2013			