
 

 
 

 
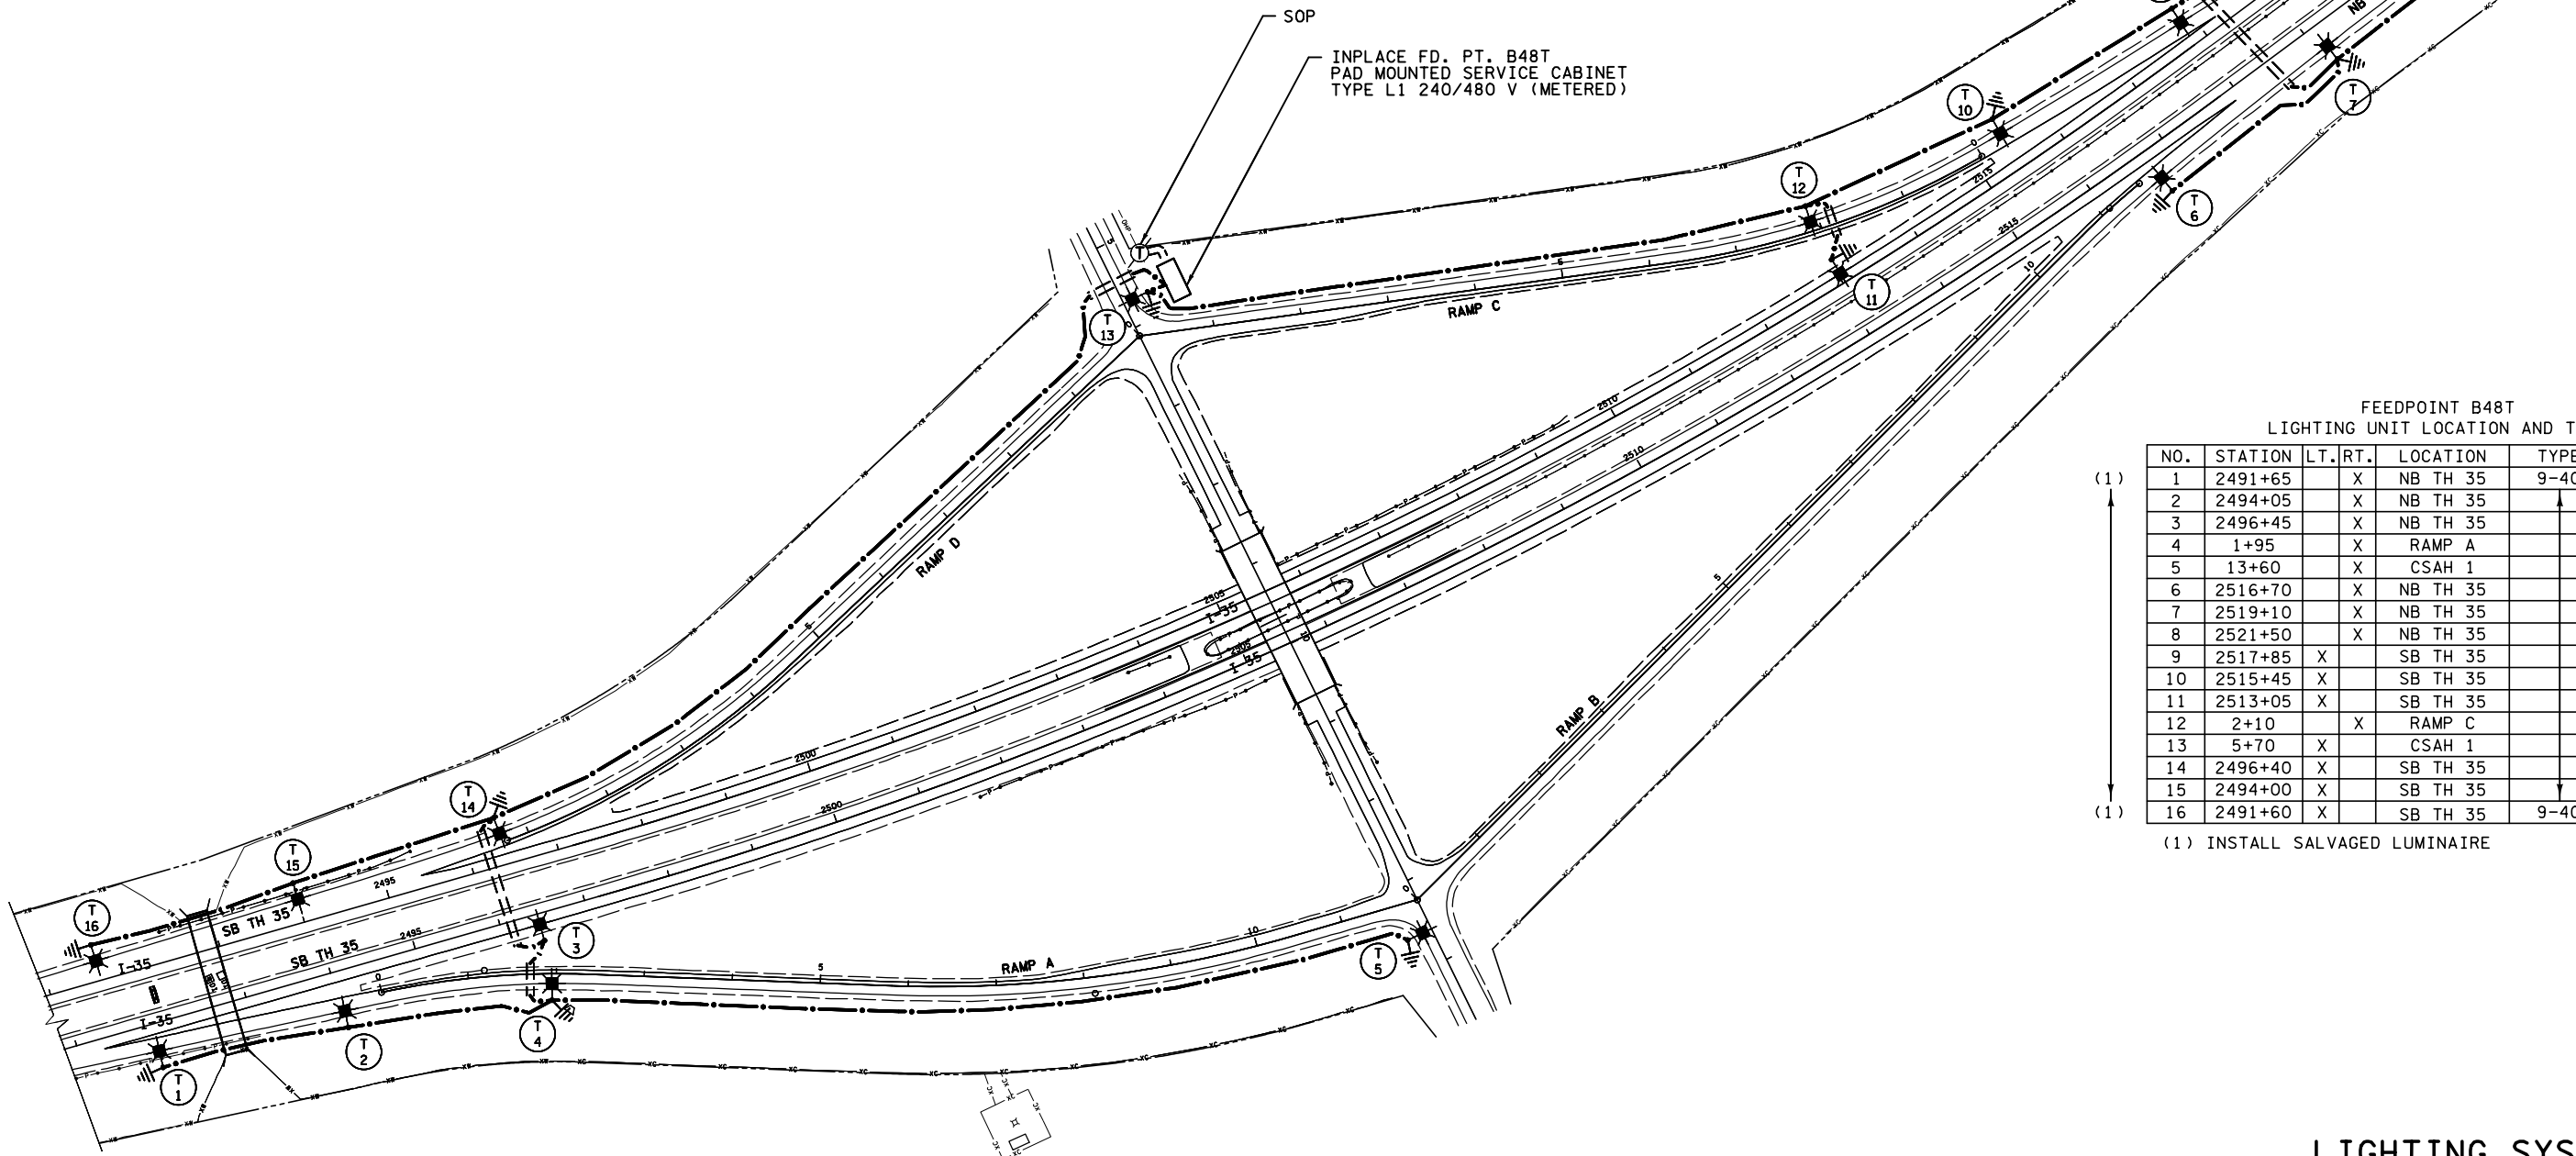
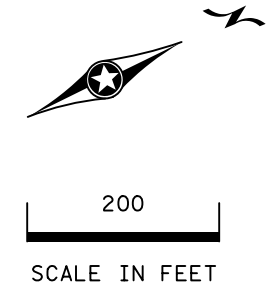
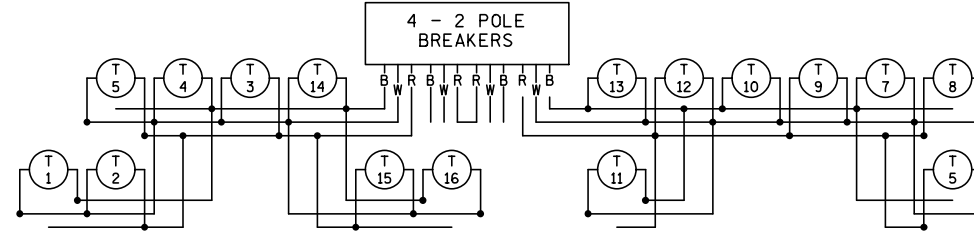


LEGEND

-  LIGHTING UNIT
-  PERMANENT GROUND ROD (25 OHMS OR LESS)
-  DIRECT BURIED LIGHTING CABLE 4/C 4 AWG
-  3" PVC DIRECTIONAL BORED (UNLESS OTHERWISE NOTED)
-  INPLACE FD. PT. CABINET
-  LIGHTING UNIT IDENTIFIER
-  RIGHT OF WAY

W DENOTES NEUTRAL CONDUCTOR
 B AND R DENOTE CURRENT CARRYING CONDUCTORS
 FD. PT. B48T
 240/480 VOLT



FEEDPOINT B48T
LIGHTING UNIT LOCATION AND TYPE

| NO. | STATION | LT. | RT. | LOCATION | TYPE | FOUNDATION |
|-----|---------|-----|-----|----------|------|------------|
| 1 | 2491+65 | | X | NB TH 35 | 9-40 | E |
| 2 | 2494+05 | | X | NB TH 35 | | |
| 3 | 2496+45 | | X | NB TH 35 | | |
| 4 | 1+95 | | X | RAMP A | | |
| 5 | 13+60 | | X | CSAH 1 | | |
| 6 | 2516+70 | | X | NB TH 35 | | |
| 7 | 2519+10 | | X | NB TH 35 | | |
| 8 | 2521+50 | | X | NB TH 35 | | |
| 9 | 2517+85 | X | | SB TH 35 | | |
| 10 | 2515+45 | X | | SB TH 35 | | |
| 11 | 2513+05 | X | | SB TH 35 | | |
| 12 | 2+10 | | X | RAMP C | | |
| 13 | 5+70 | X | | CSAH 1 | | |
| 14 | 2496+40 | X | | SB TH 35 | | |
| 15 | 2494+00 | X | | SB TH 35 | | |
| 16 | 2491+60 | X | | SB TH 35 | 9-40 | E |

(1) INSTALL SALVAGED LUMINAIRE

LIGHTING SYSTEM "A"

| BY | DATE | REVISIONS |
|----|------|-----------|
| | | |
| | | |
| | | |

FEEDPOINT: B48T LOCATION: CSAH 1/W 4TH ST
 METER ADDRESS: 1401 W 4TH ST, RUSH CITY, MN 55069

CERTIFIED BY *Michael P. Lubensky* LIC. NO. 19863 DATE: 14-NOV-2018
LICENSED PROFESSIONAL ENGINEER

LIGHTING PLAN

STATE PROJ. NO. 1380-86 (T.H. 35) SHEET NO. 6 OF 7 SHEETS
 STATE PROJ. NO. 0202-99 (T.H. 10)

DISTRICT #: Metro
 I/PLOT NAME: t1380-86.rush.city.lt.lt
 PATH & FILENAME: Projects\DM_R0S\035\380\086\Traffic\Lighting\1380-86.rush.city.lt.lt.dgn
 PLOTTED/REVISED: 14-NOV-2018