


 
 

 
 

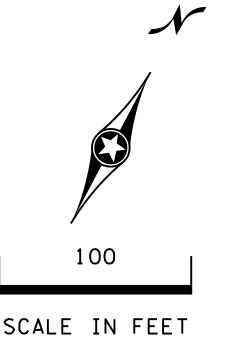


LEGEND

-  LIGHTING UNIT
-  FD. PT. CABINET
-  DIRECT BURIED CABLE 4 CONDUCTOR NO. 4
-  3" NMC DIRECTIONAL BORE (UNLESS OTHERWISE NOTED)
-  PERMANENT GROUND ROD (25 OHMS OR LESS)
-  LIGHTING UNIT IDENTIFIER
-  OVERHEAD POWER LINES
-  UTILITY POLE
-  INPLACE R/W





PLOTTED/REVISED: 6-FEB-2019

I/PLOT NAME: 17008-111.lt,AB
PATH & FILENAME: Projects\DM_R05\697008\111\TrafficLighting\17008-111.lt,AB.dgn

FEEDPOINT R20A
LIGHTING UNIT LOCATION AND TYPE

NO.	STATION	LT.	RT.	LOCATION	TYPE	FOUNDATION
1	1068+81	X		NB169	9-40 LED	DESIGN E
2	1078+95		X	NB169	9-40 LED	DESIGN E
3	1081+33		X	NB169	9-40 LED	DESIGN E
4	1087+93	X		NB169	9-40 LED	DESIGN E
5	1081+32	X		SB169	9-40 LED	DESIGN E
6	1078+95	X		SB169	9-40 LED	DESIGN E

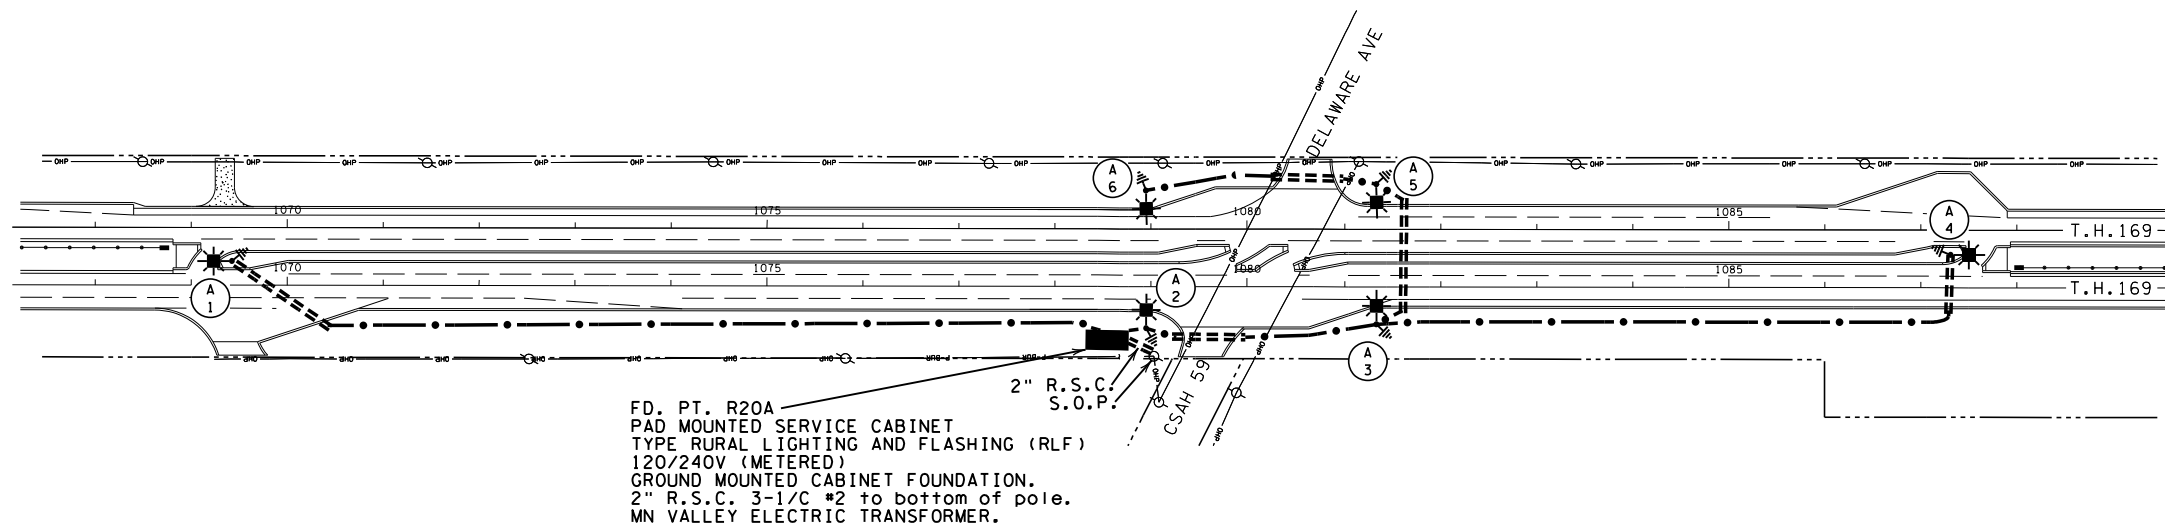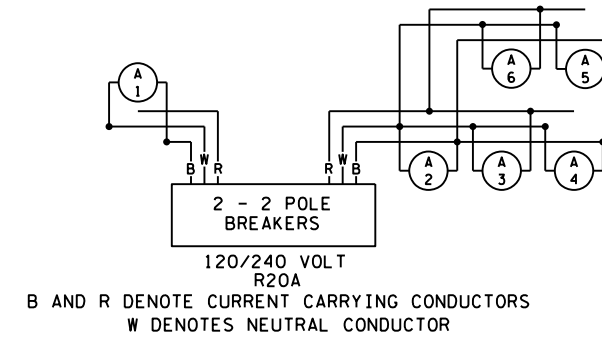

BY	DATE	REVISIONS
DRAWN BY: PB		CKD BY: GK

FEEDPOINT: R20A LOCATION: DELAWARE AVE/CSAH 59
METER ADDRESS: 20199 JOHNSON MEMORIAL ROAD, JORDAN 55352

CERTIFIED BY *Michael P. Lubensky* LIC. NO. 19863 DATE: 6-FEB-2019
LICENSED PROFESSIONAL ENGINEER

LIGHTING PLAN

STATE PROJ. NO. 7008-111 (T.H. 169) SHEET NO. SL4 OF SL4 SHEETS